
 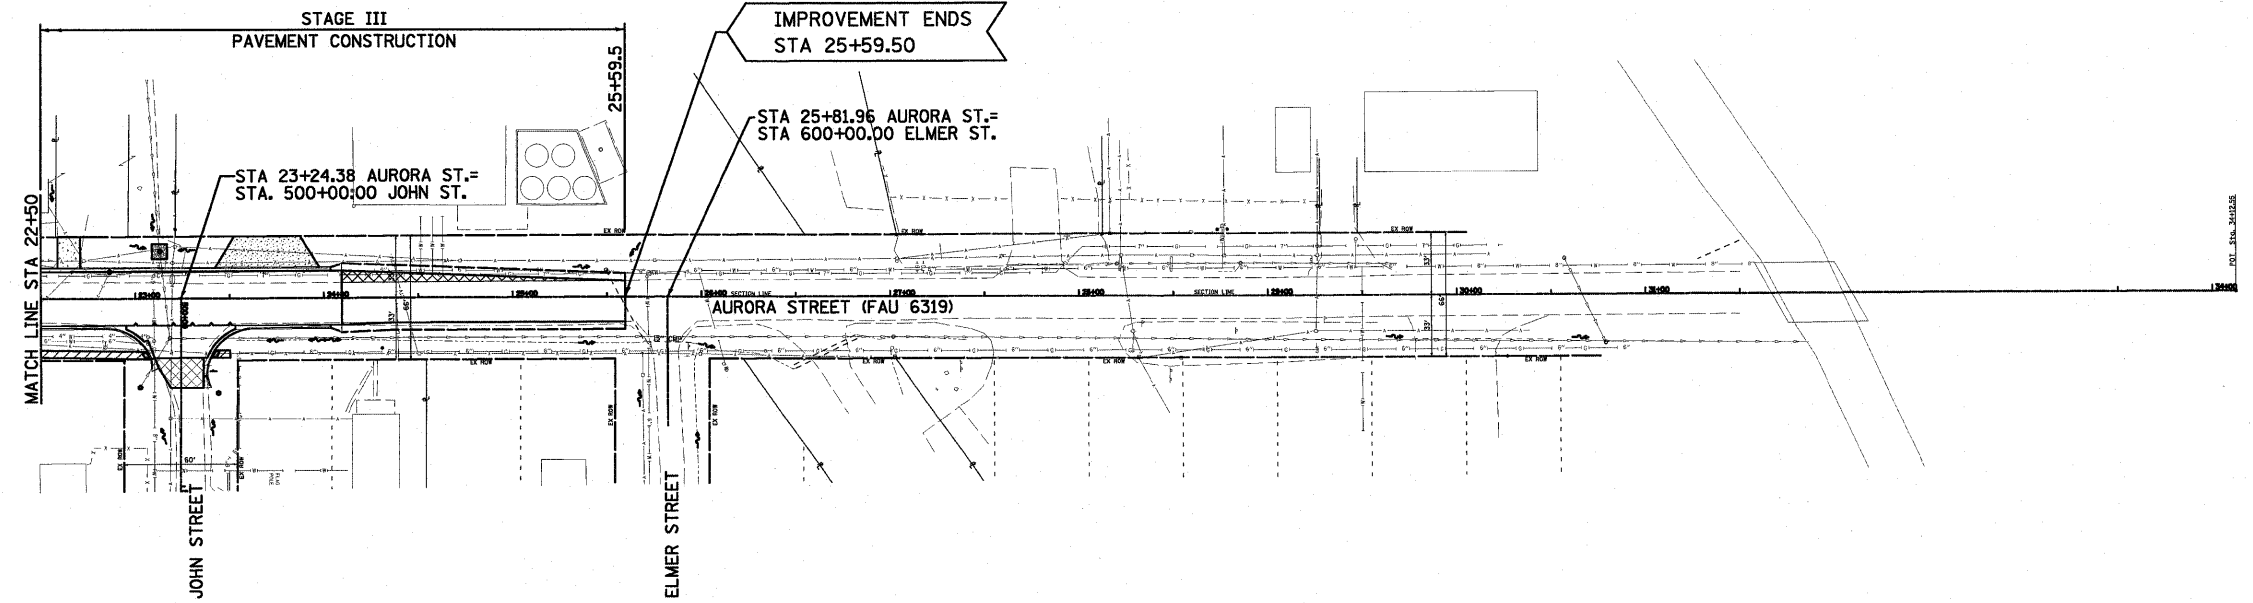


IMPROVEMENT BEGINS
STA 10+18.00

STA 10+00.00 AURORA ST.=
STA 100+00.00 INDIANA AVE.

STA 15+79.20 AURORA ST.=
STA 300+00.00
WABASH AVE. (WEST)

STA 15+92.78 AURORA ST.=
STA. 300+00.00 WABASH AVE. (EAST)



IMPROVEMENT ENDS
STA 25+59.50

STA 25+81.96 AURORA ST.=
STA 600+00.00 ELMER ST.

MATCH LINE STA 22+50

STA 23+24.38 AURORA ST.=
STA. 500+00.00 JOHN ST.

**ROADWAY PAVEMENT AND CURB & GUTTER
CONSTRUCTION STAGING REQUIREMENTS**

1. THIS SHEET SHALL BE REFERENCED WITH THE APPLICABLE SPECIAL PROVISIONS FOR COMPLETION DATE, AGGREGATE FOR TEMPORARY ACCESS, TRAFFIC CONTROL AND SEQUENCE OF OPERATIONS.

FILE NAME =
0080539_Stage.dgn

USER NAME = #USER#
PLOT SCALE = #SCALE#
PLOT DATE = 3/25/2010

DESIGNED - DWR/JDA
DRAWN - JTC
CHECKED - ERB
DATE - 03/25/10

REVISED -
REVISED -
REVISED -
REVISED -

**STATE OF ILLINOIS
DEPARTMENT OF TRANSPORTATION**

Farnsworth GROUP
301 W. WASHINGTON STREET, PONTIAC, IL 61764
TEL: 815-844-9071 / 815-844-3147 FAX: www.f-w.com

**CITY OF PONTIAC - AURORA STREET (FAU 6319)
STAGE CONSTRUCTION PLAN**

SCALE: 1"=50' SHEET NO. OF SHEETS STA. 10+18 TO STA. 25+59.50

F.A.U. RTE.	SECTION	COUNTY	TOTAL SHEETS	SHEET NO.
6319	08-00091-00-RP	LIVINGSTON	31	6
CONTRACT NO. 87404				
FED. ROAD DIST. NO. ILLINOIS FED. AID PROJECT				