



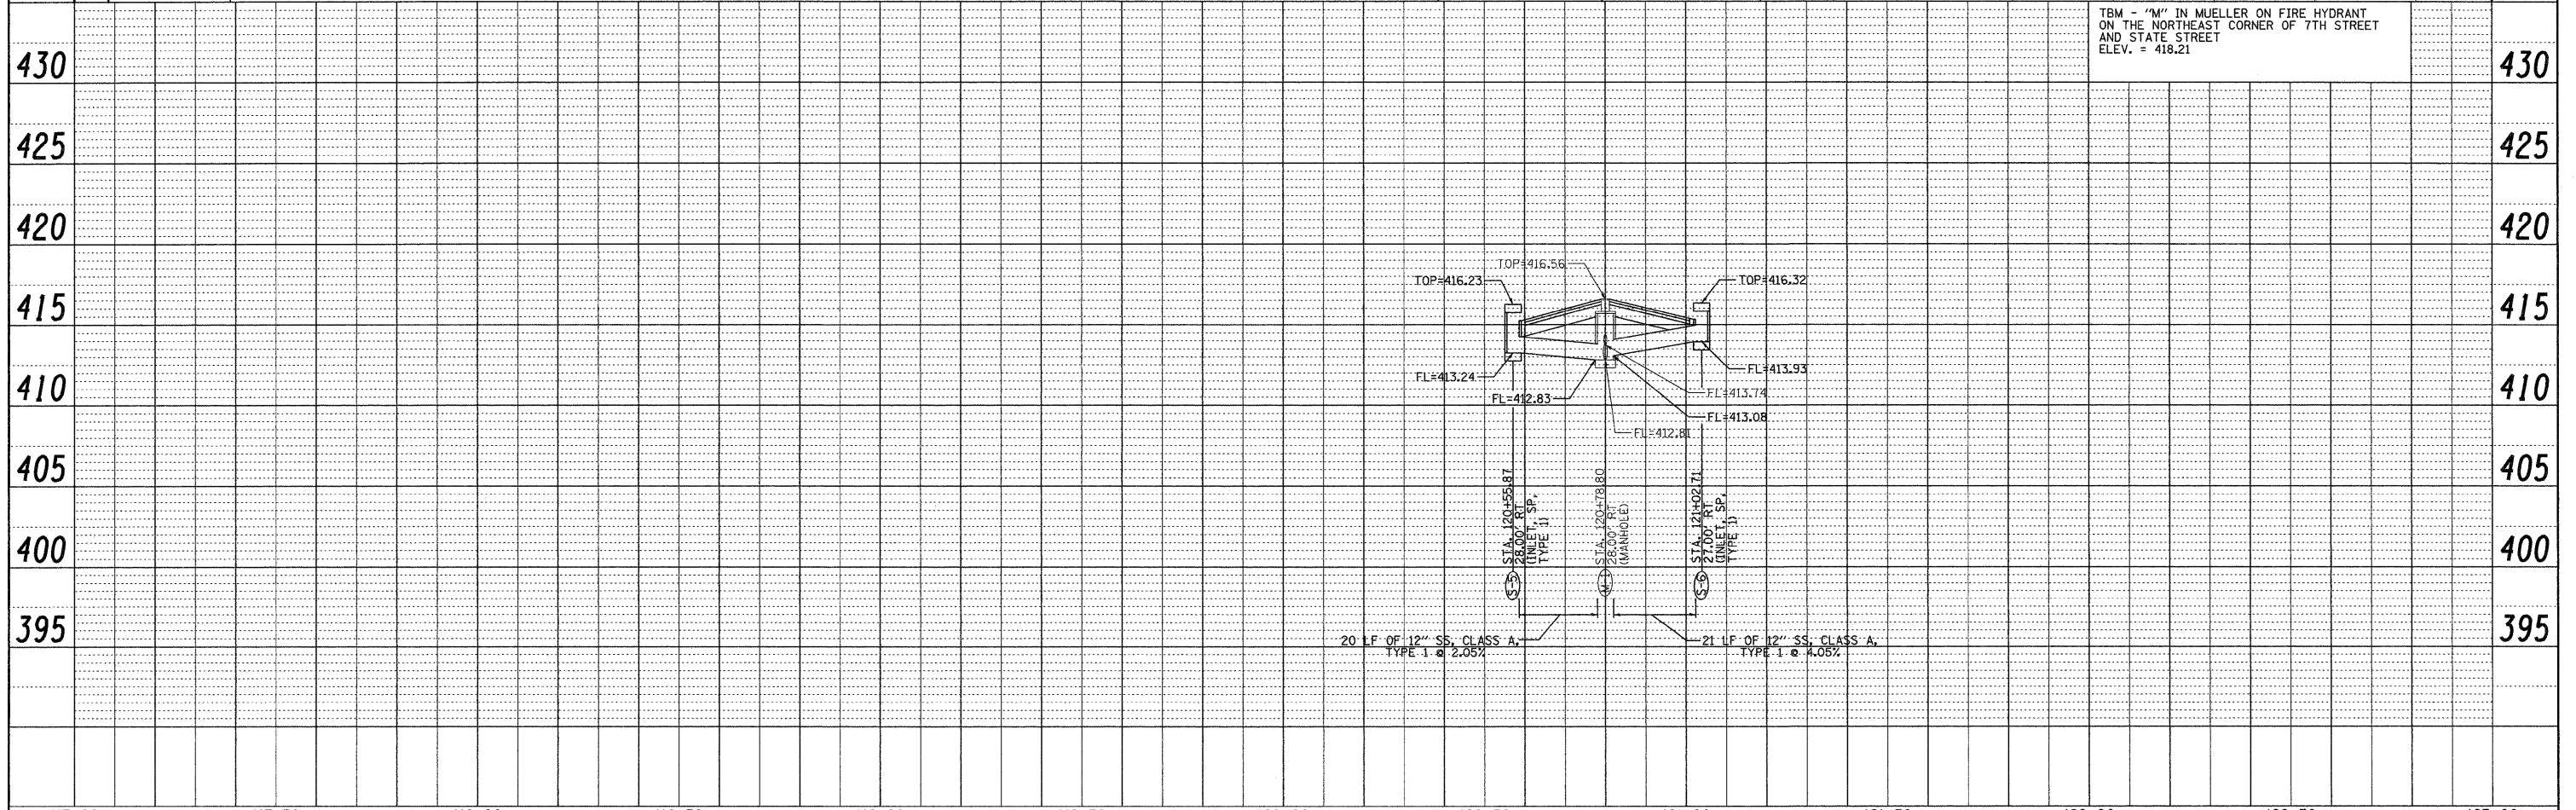

PLAN	SURVEYED	DATE
	PLOTTED	
	CHECKED	
	BY	
	NO. OF DAYS CHECKED	
	CADD FILE NAME	
	NO.	

PROFILE	SURVEYED	DATE
	PLOTTED	
	CHECKED	
	BY	
	NO. OF DAYS CHECKED	
	STRUCTURE NOTATIONS CHKD	
	NO.	

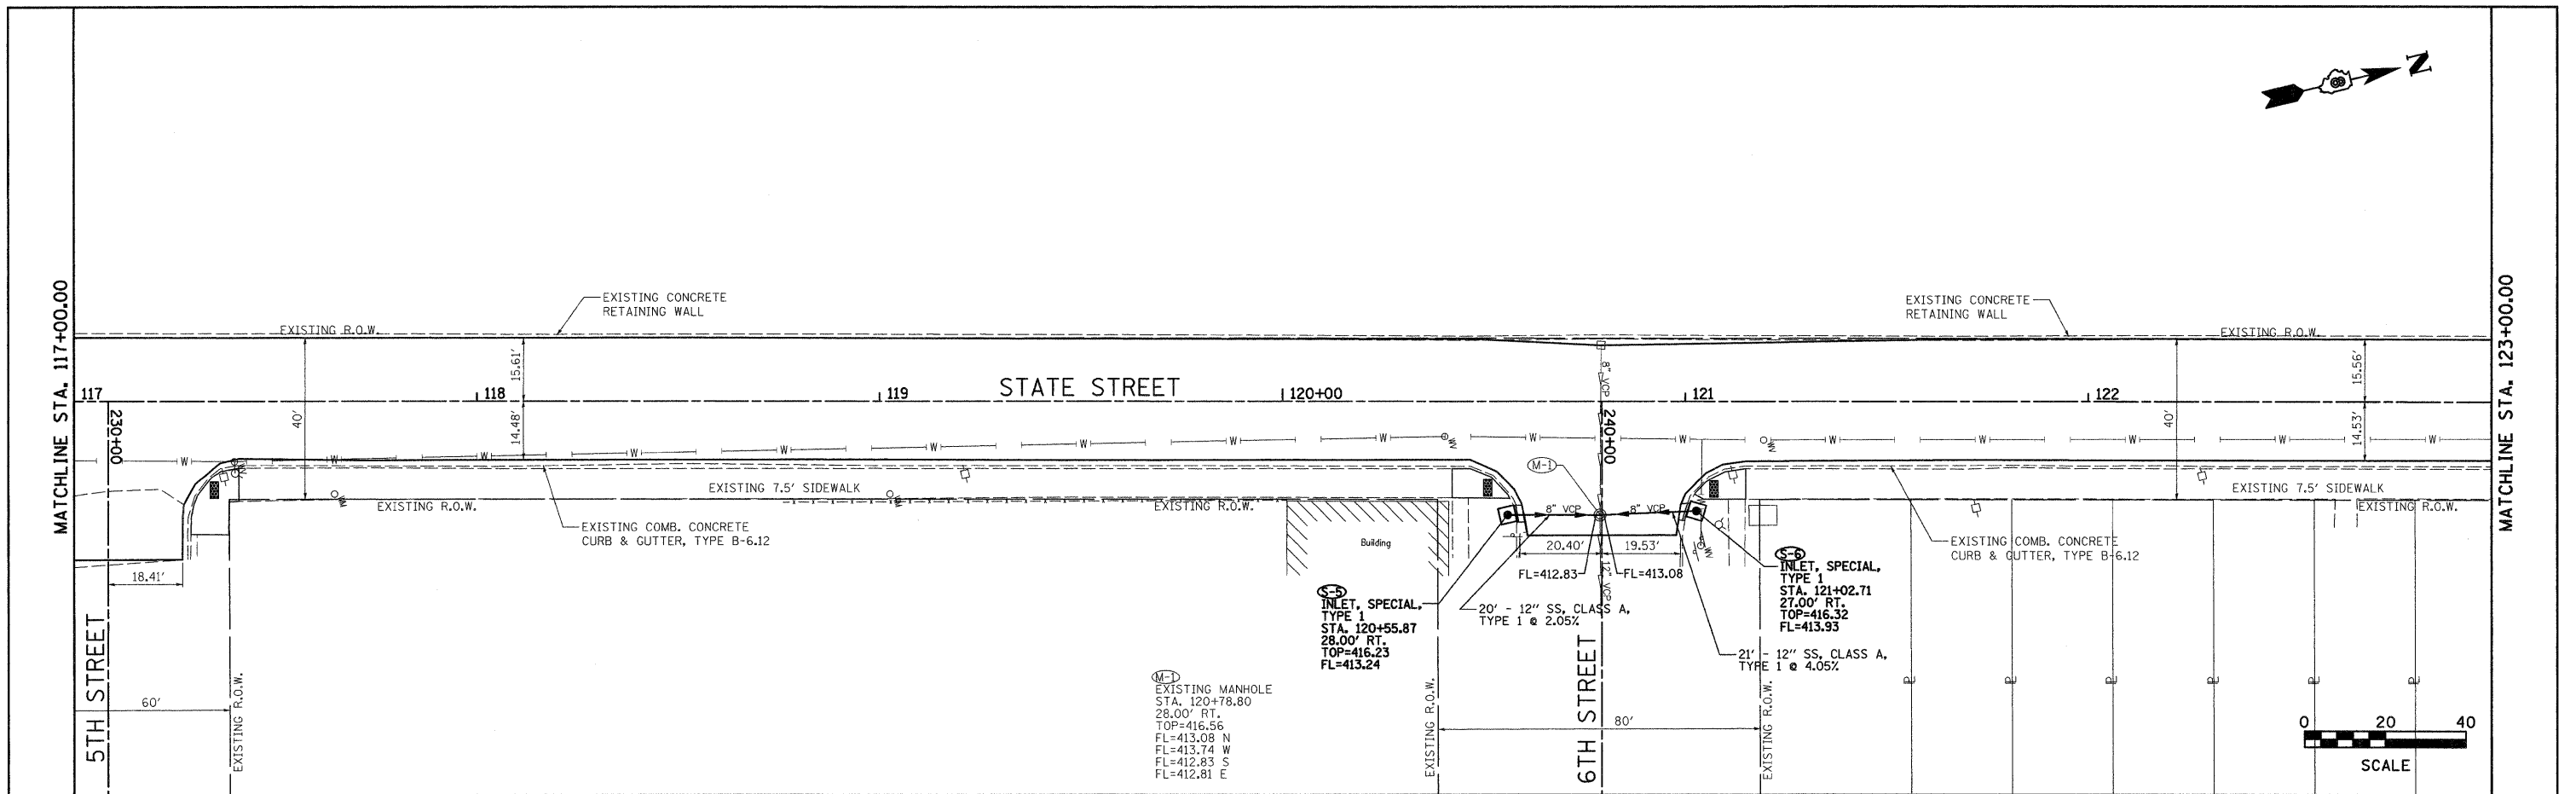

TBM - "M" IN MUELLER ON FIRE HYDRANT ON THE NORTHEAST CORNER OF 7TH STREET AND STATE STREET ELEV. = 418.21

117+00	117+50	118+00	118+50	119+00	119+50	120+00	120+50	121+00	121+50	122+00	122+50	123+00					
FILE NAME =		USER NAME = ramesh		DESIGNED -		REVISED -		F.A.U. RTE.		SECTION		COUNTY		TOTAL SHEETS		SHEET NO.	
#FILE#		PLOT SCALE = #SCALE#		DRAWN -		REVISED -		9096		05-00021-02-RS		MADISON		37		29	
		PLOT DATE = 4/8/2018		CHECKED -		REVISED -		SCALE: 1" = 20'		SHEET NO. OF SHEETS		STA. TO STA.		CONTRACT NO. 97441		ILLINOIS FED. AID PROJECT	
				DATE -		REVISED -											

CITY OF MADISON  
STATE STREET

DRAINAGE PLAN & PROFILE