


PLAN	DATE	BY
DESIGNED		
PLANNED		
NOTED		
FILED		
FILE NAME		

PROFILE	DATE	BY
DESIGNED		
PLANNED		
NOTED		
FILED		
FILE NAME		

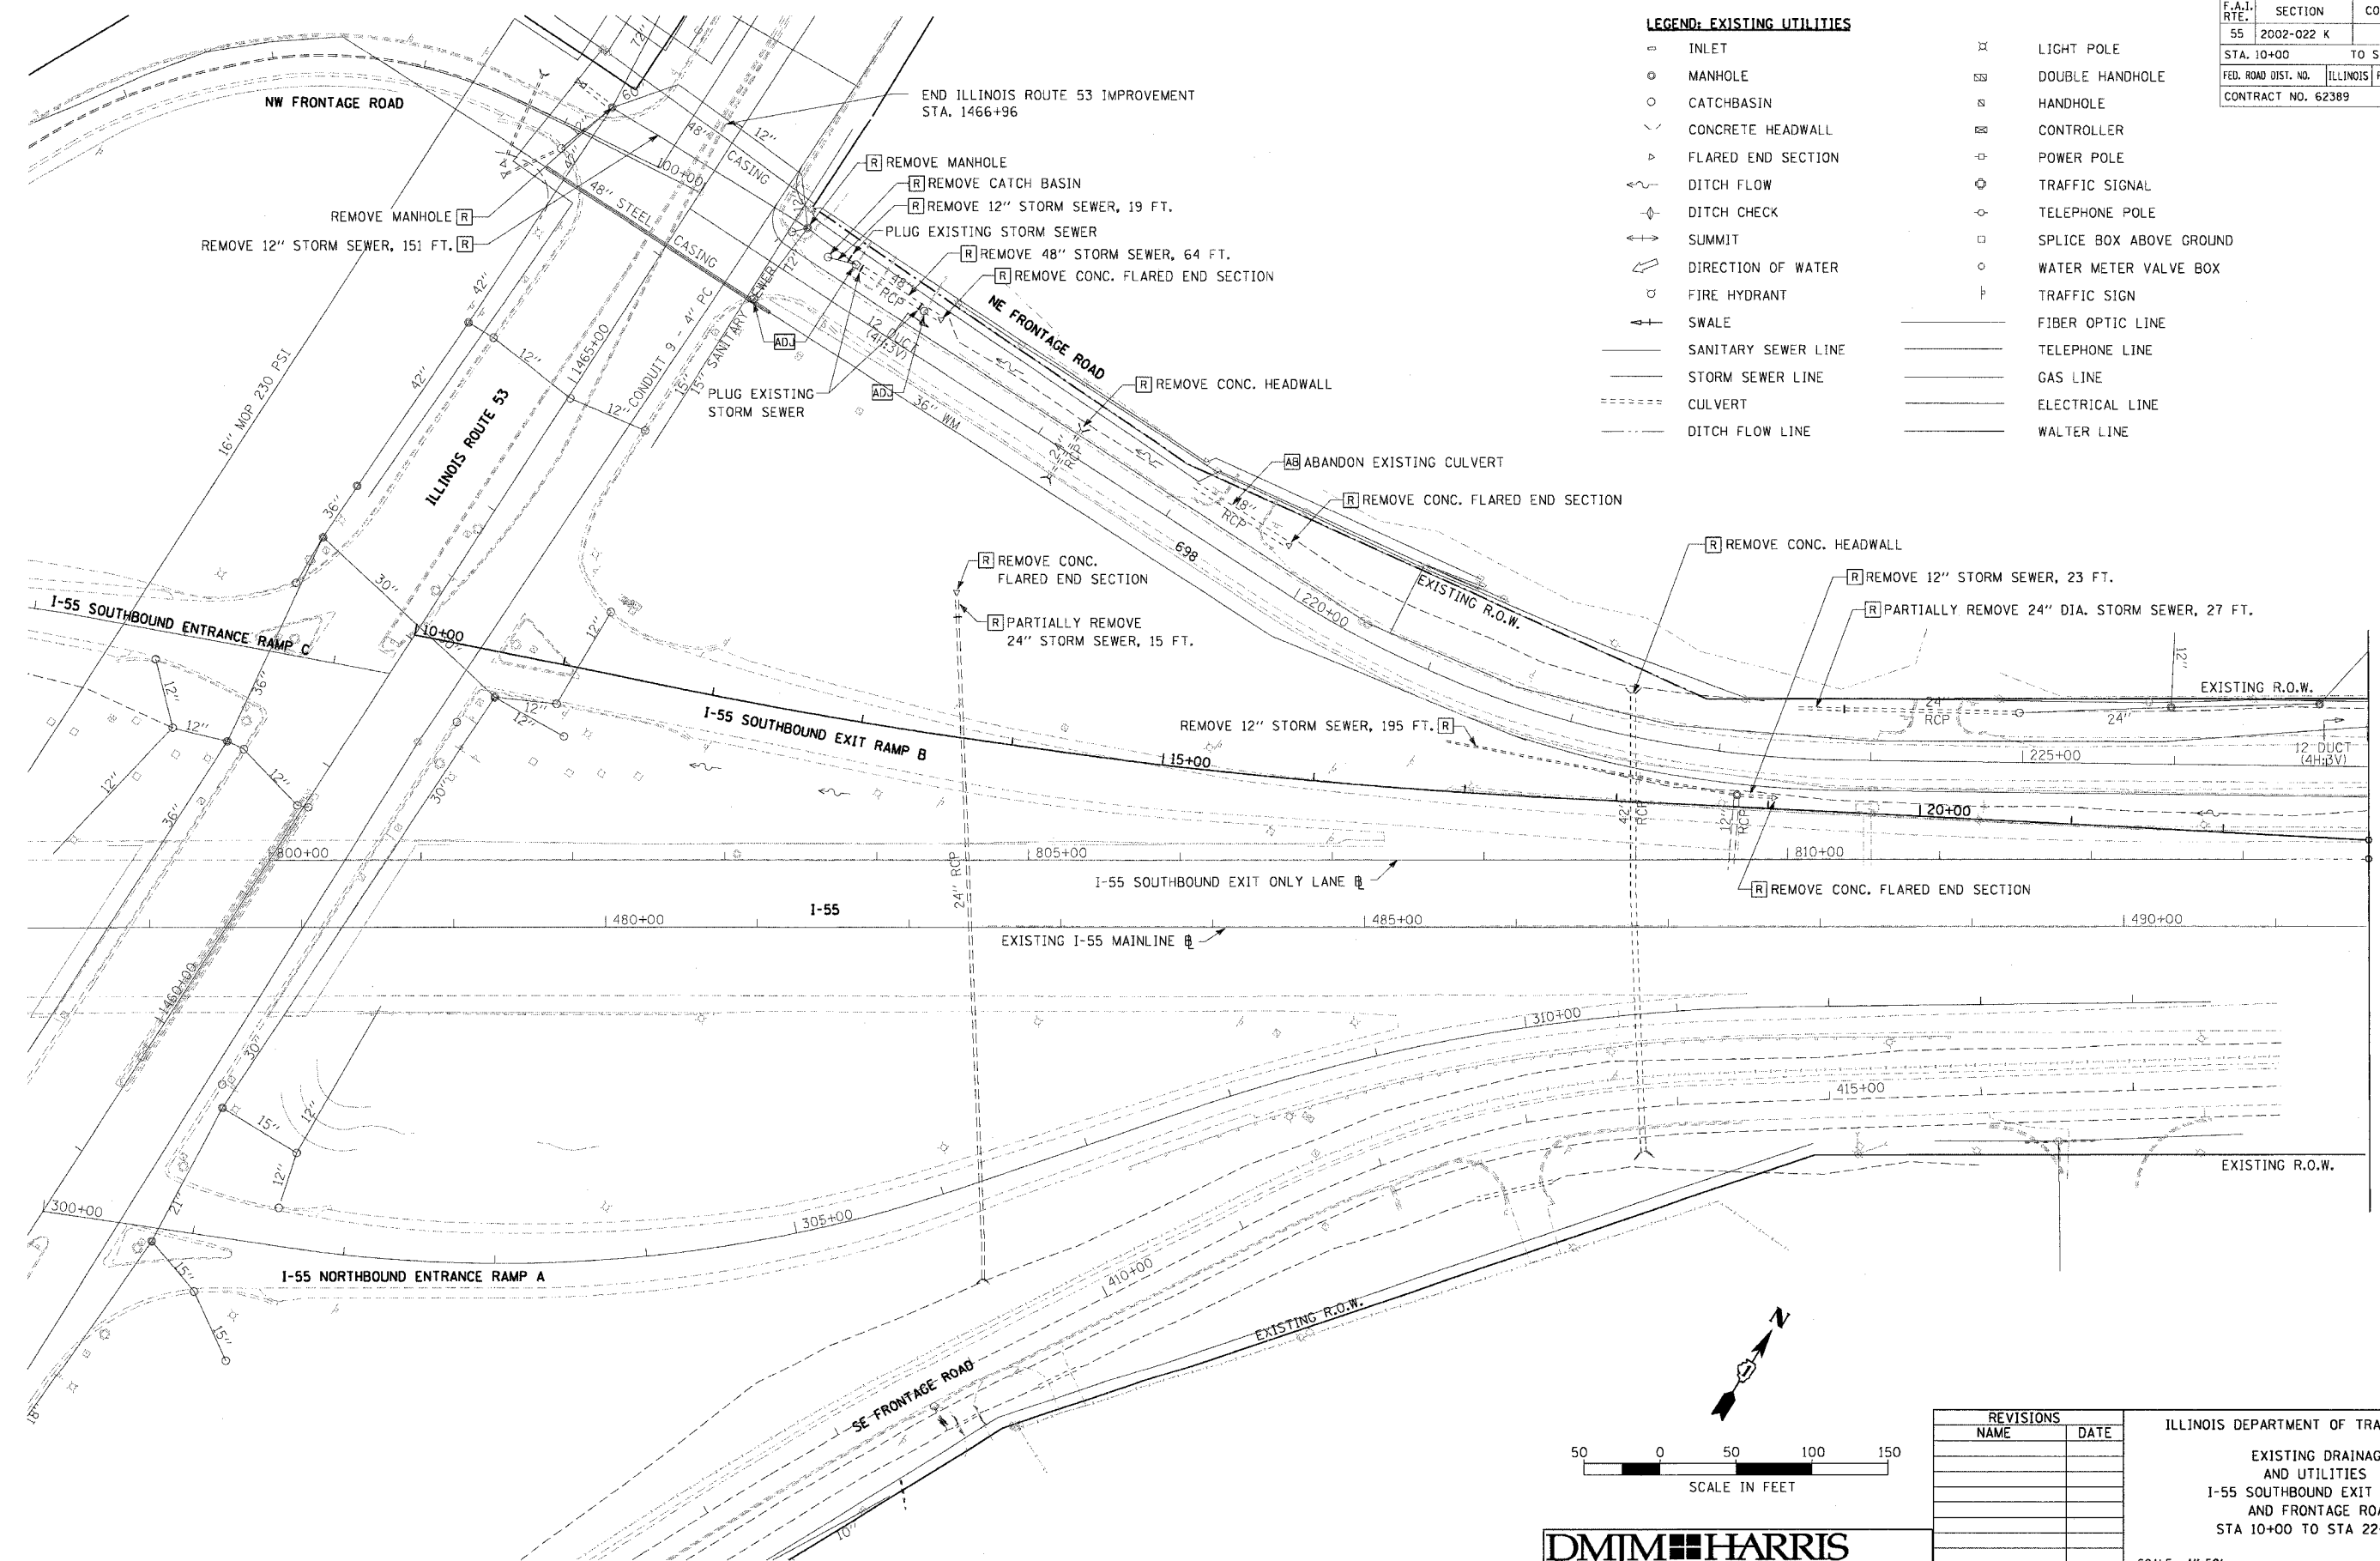

LEGEND: EXISTING UTILITIES

INLET	LIGHT POLE
MANHOLE	DOUBLE HANDHOLE
CATCHBASIN	HANDHOLE
CONCRETE HEADWALL	CONTROLLER
FLARED END SECTION	POWER POLE
DITCH FLOW	TRAFFIC SIGNAL
DITCH CHECK	TELEPHONE POLE
SUMMIT	SPLICE BOX ABOVE GROUND
DIRECTION OF WATER	WATER METER VALVE BOX
FIRE HYDRANT	TRAFFIC SIGN
SWALE	FIBER OPTIC LINE
SANITARY SEWER LINE	TELEPHONE LINE
STORM SEWER LINE	GAS LINE
CULVERT	ELECTRICAL LINE
DITCH FLOW LINE	WALTER LINE

F.A.I. RTE.	SECTION	COUNTY	TOTAL SHEETS	SHEET NO.
55	2002-022 K	WILL	172	42
STA. 10+00 TO STA. 22+96.05				
FED. ROAD DIST. NO. ILLINOIS FED. AID PROJECT				
CONTRACT NO. 62389				

DMJM HARRIS
303 East Wacker Drive, Suite 600
Chicago, Illinois, 60601 Phone: 312.321.6101 Fax: 312.396.2392



REVISIONS	
NAME	DATE

ILLINOIS DEPARTMENT OF TRANSPORTATION
EXISTING DRAINAGE
AND UTILITIES
I-55 SOUTHBOUND EXIT RAMP B
AND FRONTAGE ROAD
STA 10+00 TO STA 22+96.05

SCALE: 1"=50'
DATE: 11/8/2004
DRAWN BY: CC
CHECKED BY: RI


OCTOBER, 2004

F.A.I. RTE.	SECTION	COUNTY	TOTAL SHEETS	SHEET NO.
55	2002-022 K	WILL	172	43
STA. 10+00 TO STA. 22+96.05				
FED. ROAD DIST. NO. ILLINOIS FED. AID PROJECT				
CONTRACT NO. 62389				

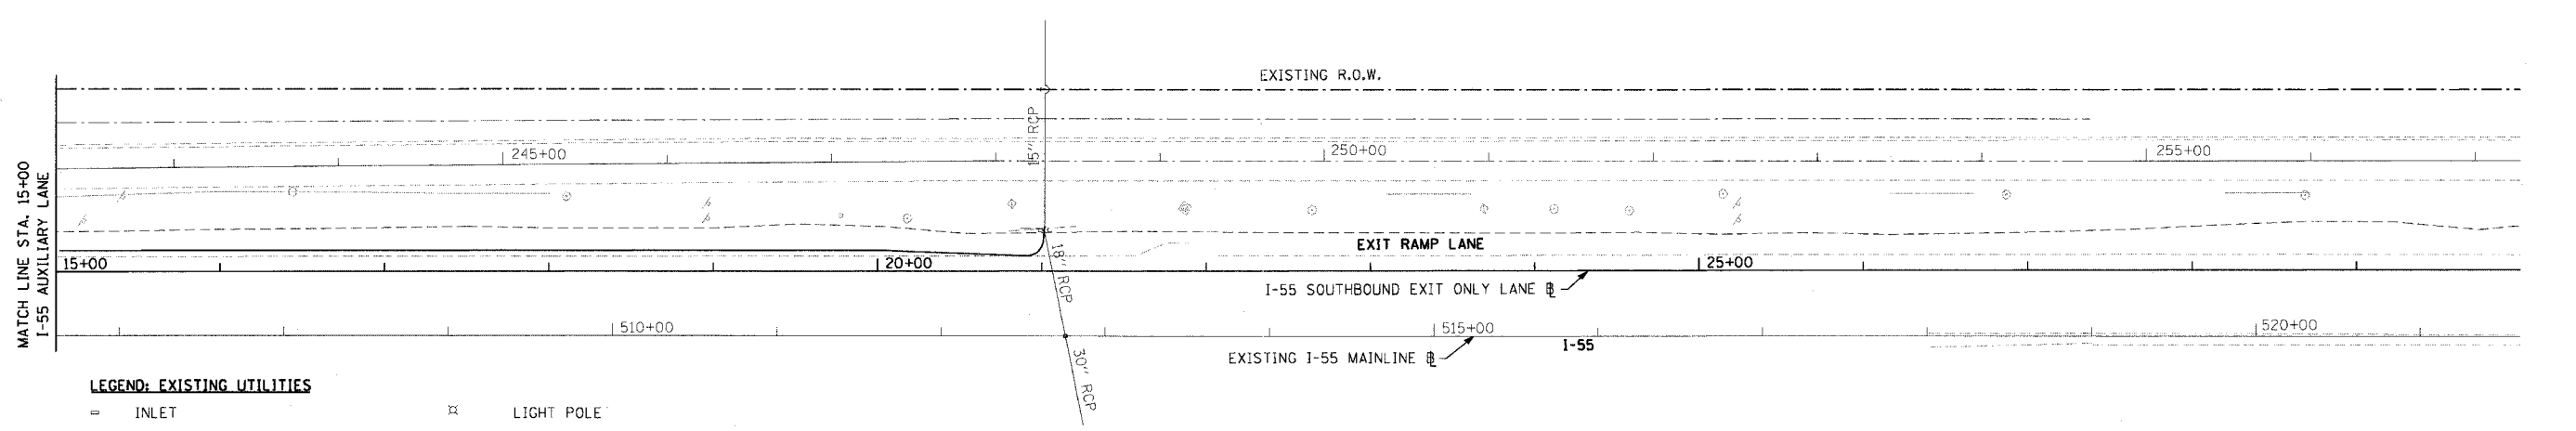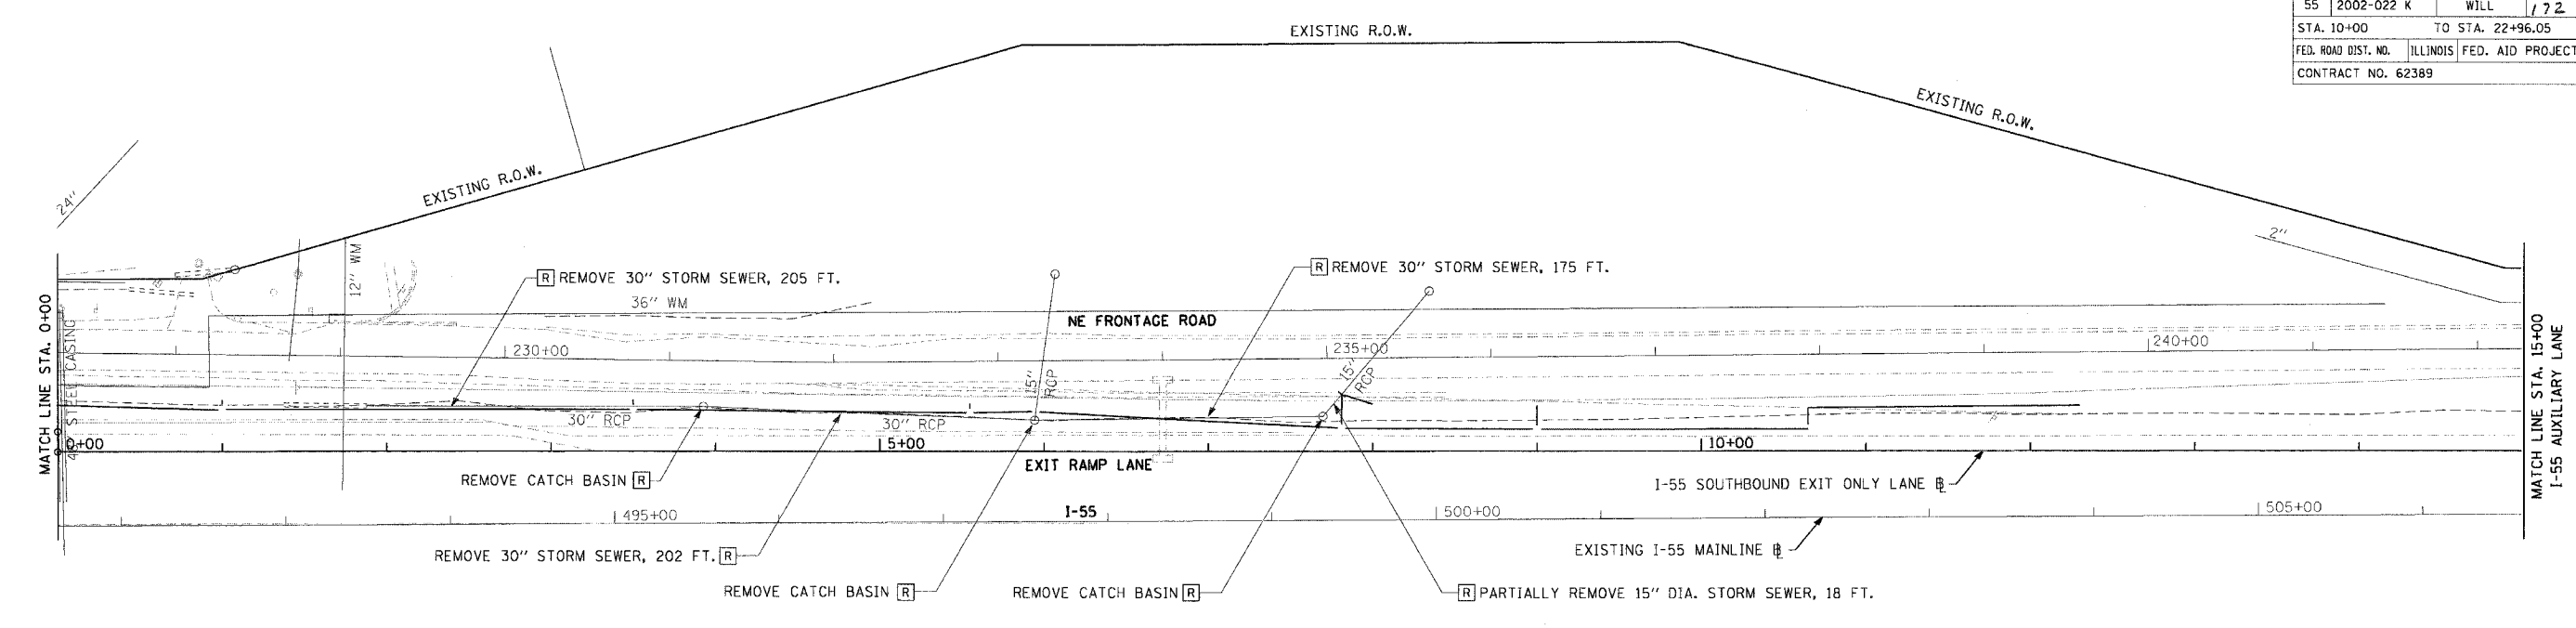

LEGEND: EXISTING UTILITIES

INLET	LIGHT POLE
MANHOLE	DOUBLE HANDHOLE
CATCHBASIN	HANDHOLE
CONCRETE HEADWALL	CONTROLLER
FLARED END SECTION	POWER POLE
DITCH FLOW	TRAFFIC SIGNAL
DITCH CHECK	TELEPHONE POLE
SUMMIT	SPLICE BOX ABOVE GROUND
DIRECTION OF WATER	WATER METER VALVE BOX
FIRE HYDRANT	TRAFFIC SIGN
SWALE	FIBER OPTIC LINE
SANITARY SEWER LINE	TELEPHONE LINE
STORM SEWER LINE	GAS LINE
CULVERT	ELECTRICAL LINE
DITCH FLOW LINE	WATER LINE

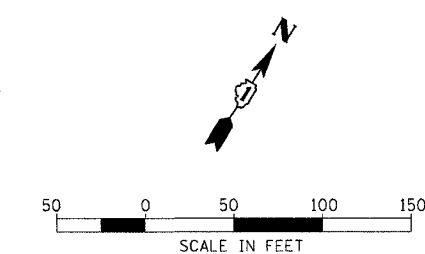

DMJM HARRIS
 303 East Wacker Drive, Suite 600
 Chicago, Illinois, 60601 Phone: 312.321.6101 Fax: 312.396.2392

REVISIONS	
NAME	DATE

ILLINOIS DEPARTMENT OF TRANSPORTATION

EXISTING DRAINAGE AND UTILITIES
 I-55 EXIT RAMP LANE
 STA 0+00 TO STA 22+00

SCALE: 1"=50'
 DATE: 11/8/2004


DRAWN BY: CC
 CHECKED BY: RI

OCTOBER, 2004

PLAN	SURVEYED	BY	DATE

PROFILE	SURVEYED	BY	DATE

F.A.I. RTE.	SECTION	COUNTY	TOTAL SHEETS	SHEET NO.
55	2002-022 K	WILL	172	44
STA. 1454+20 TO STA. 1466+96				
FED. ROAD DIST. NO. ILLINOIS FED. AID PROJECT				
CONTRACT NO. 62389				

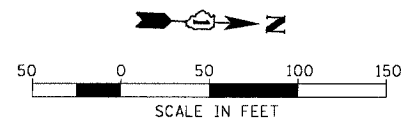


LEGEND: EXISTING UTILITIES

- INLET
- MANHOLE
- CATCHBASIN
- CONCRETE HEADWALL
- FLARED END SECTION
- DITCH FLOW
- DITCH CHECK
- SUMMIT
- DIRECTION OF WATER
- FIRE HYDRANT
- SWALE
- SANITARY SEWER LINE
- STORM SEWER LINE
- CULVERT
- DITCH FLOW LINE
- LIGHT POLE
- DOUBLE HANDHOLE
- HANDHOLE
- CONTROLLER
- POWER POLE
- TRAFFIC SIGNAL
- TELEPHONE POLE
- SPLICE BOX ABOVE GROUND
- WATER METER VALVE BOX
- TRAFFIC SIGN
- FIBER OPTIC LINE
- TELEPHONE LINE
- GAS LINE
- ELECTRICAL LINE
- WALTER LINE

PLAN	DATE	BY
SURVEYED		
NOTED		
FILE NAME		

PROFILE	DATE	BY
SURVEYED		
NOTED		
FILE NAME		

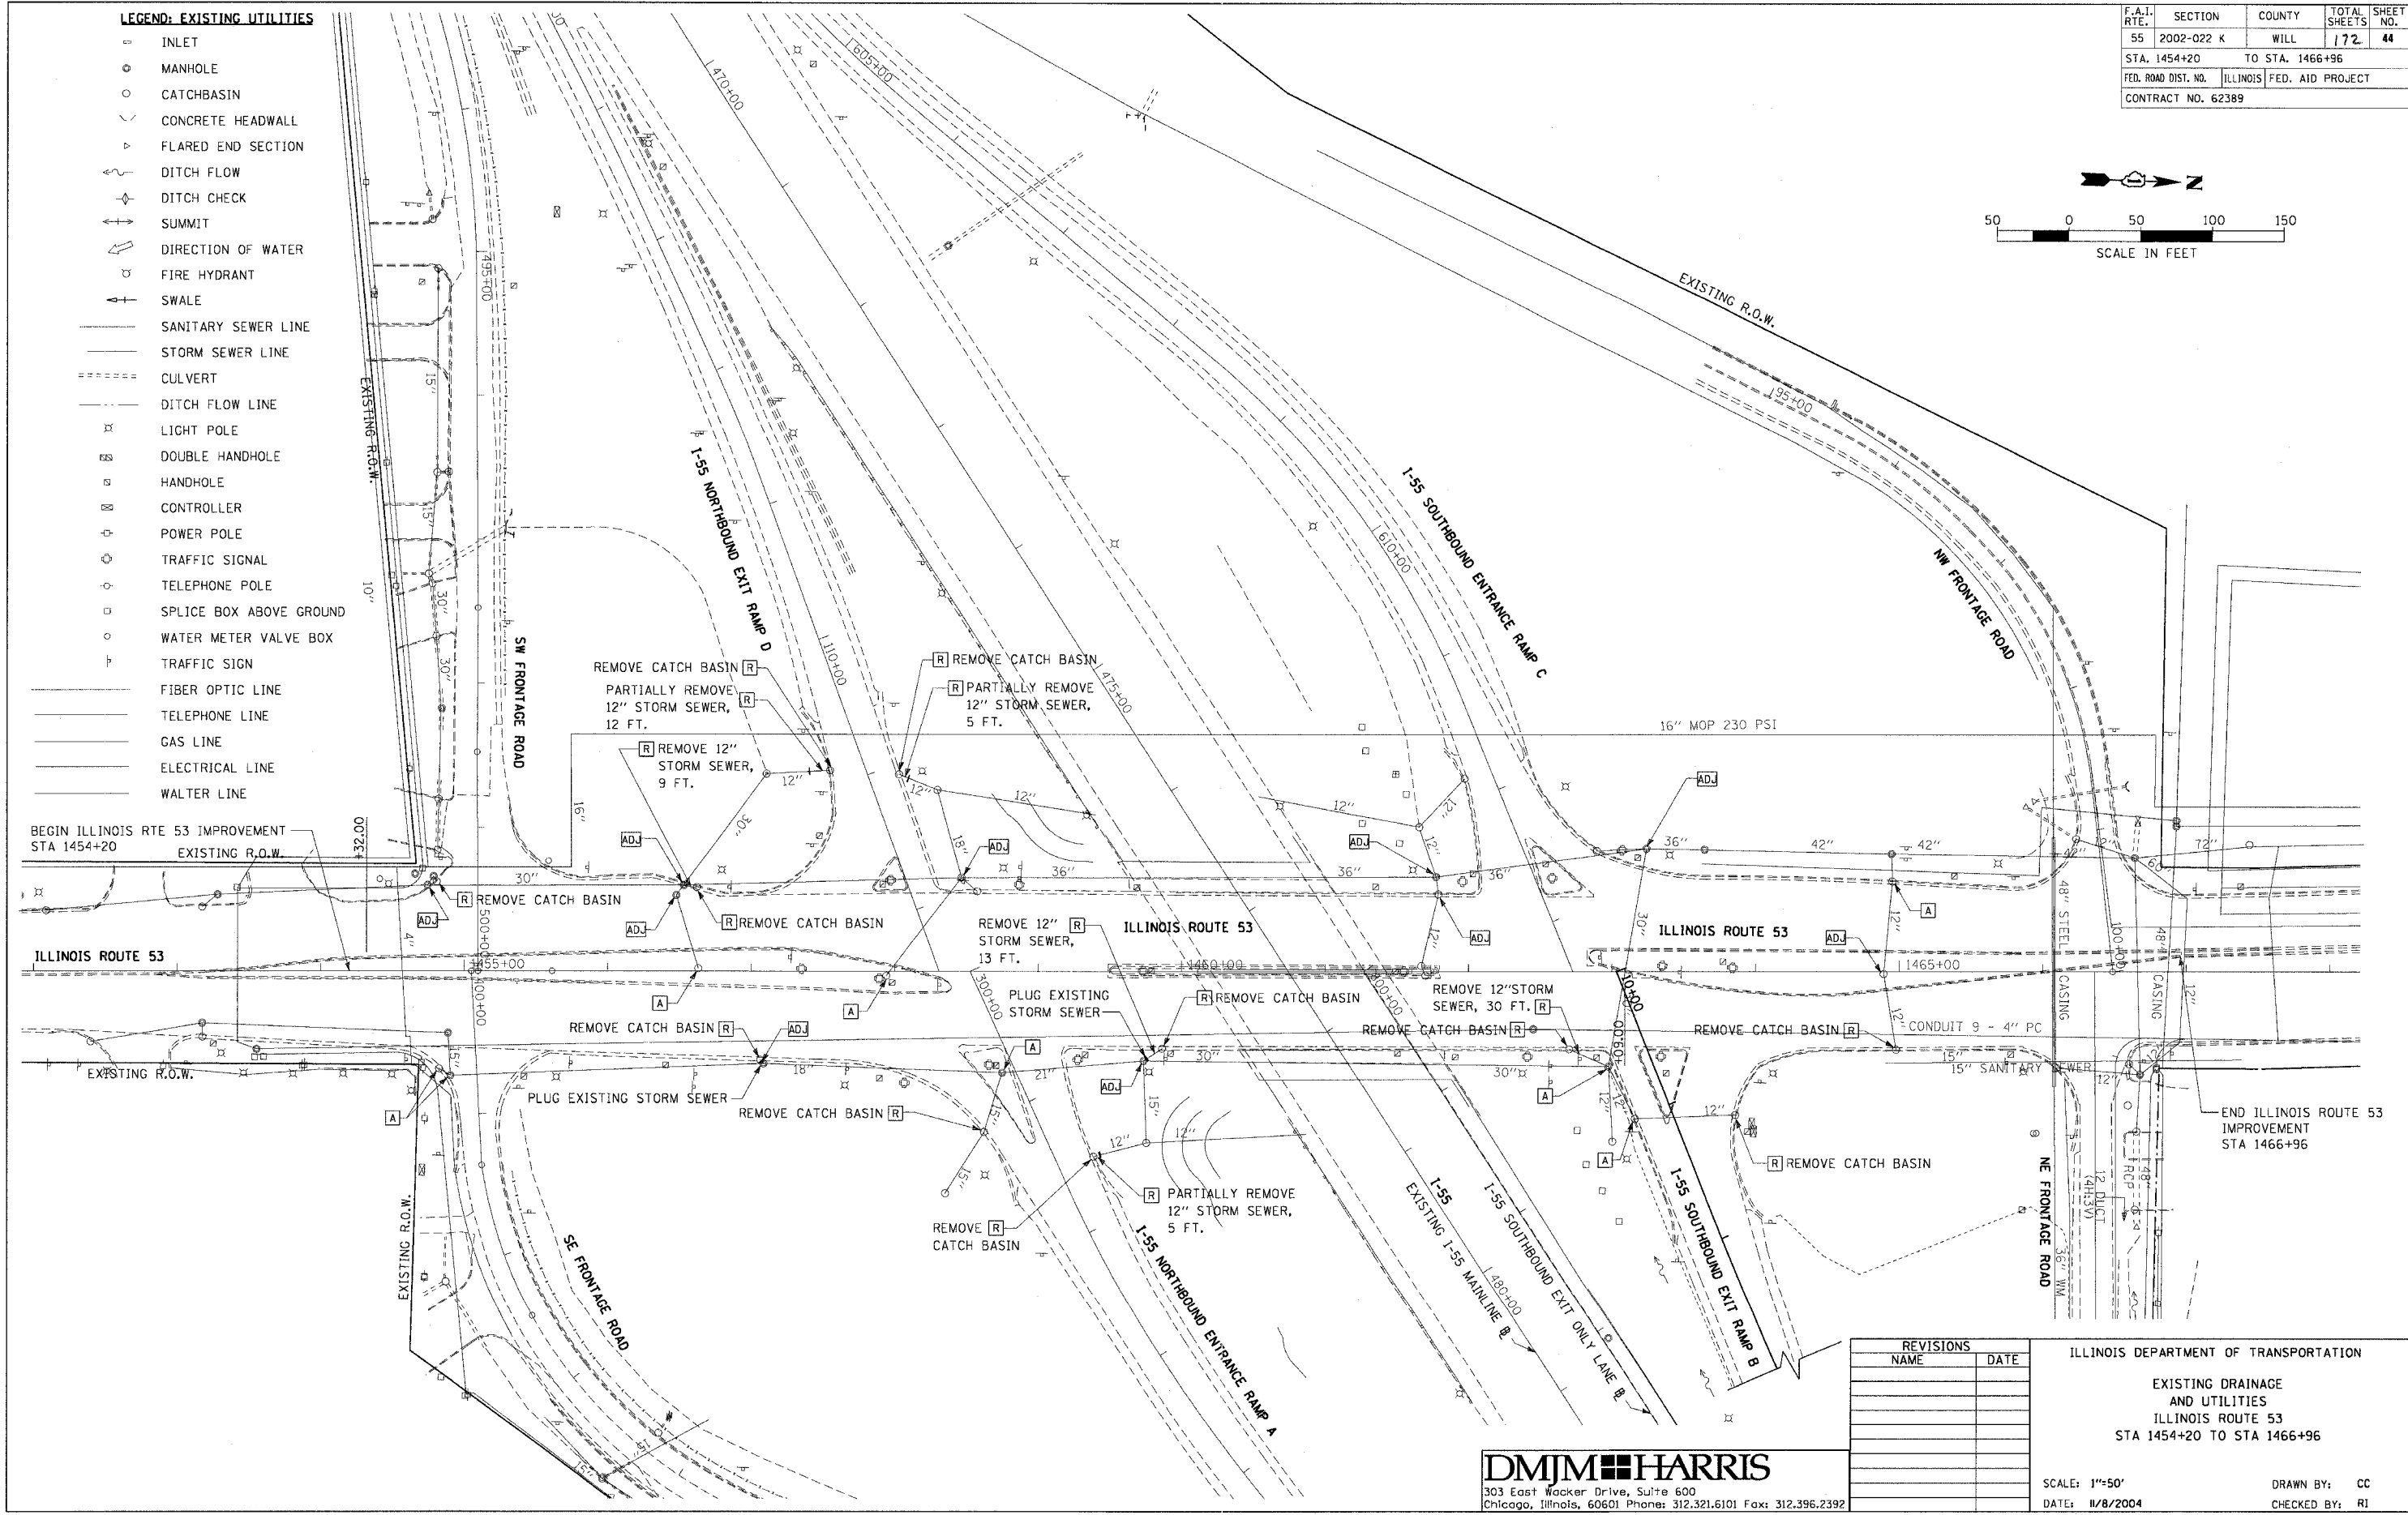

REVISIONS	
NAME	DATE

ILLINOIS DEPARTMENT OF TRANSPORTATION

EXISTING DRAINAGE
AND UTILITIES
ILLINOIS ROUTE 53
STA 1454+20 TO STA 1466+96


SCALE: 1"=50'
DATE: 11/8/2004

DRAWN BY: CC
CHECKED BY: RI

DMJM HARRIS
303 East Wacker Drive, Suite 600
Chicago, Illinois, 60601 Phone: 312.321.6101 Fax: 312.396.2392

LEGEND: PROPOSED UTILITIES

- | | | | |
|-----------|--------------------|----|------|
| PLAN | SURVEYED | BY | DATE |
| NOTE BOOK | PLOTTED | | |
| NO. | ALIGNMENT CHECKED | | |
| | RT. OF WAY CHECKED | | |
| | CADD FILE NAME | | |

 ILLINOIS DEPARTMENT OF TRANSPORTATION

PROPOSED DRAINAGE PLAN
I-55 SOUTHBOUND EXIT RAMP B
STA 10+00 TO STA 22+96.05

SCALE: 1"=50'
DATE: 12/23/2004

DRAWN BY: CC
CHECKED BY: RI

OCTOBER, 2004

DMJM HARRIS



303 East Wacker Drive, Suite 600
Chicago, Illinois 60601 Phone: 312.321.6101 Fax: 312.395.2392

PLAN	SURVEYED	BY	DATE
NOTE BOOK	ALIGNED		
NO.	RT. OF WAY CHECKED		
	CADD FILE NAME		

OCTOBER, 2004

PLAN	SURVEYED	BY	DATE
NOTE BOOK	PLOTTED		
	ALIGNMENT CHECKED		
	RT. OF WAY CHECKED		
NO. _____	CADD FILE NAME		

PROFILE	SURVEYED	BY	DATE
NOTE BOOK	PLOTTED		
NO.	GRADES CHECKED		
	B.M. NOTED		
	STRUCTURE NOTAT'NS CHK'D		

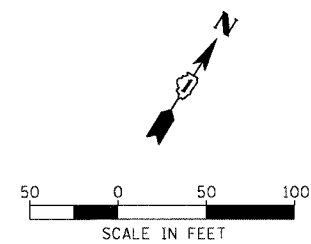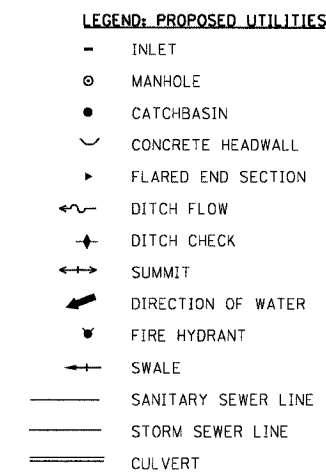[illegible]

ILLINOIS DEPARTMENT OF TRANSPORTATION

PROPOSED DRAINAGE PLAN
I-55 NORTHBOUND EXIT RAMP D
STA 105+45 TO STA 111+85
I-55 NORTHBOUND ENTRANCE RAMP A
STA 301+57 TO STA 303+61



SCALE: 1"=50' DRAWN BY: CC
DATE: 11/8/2004 CHECKED BY: RI

DMJM ■ HARRIS
 303 East Wacker Drive, Suite 600
 Chicago, Illinois, 60601 Phone: 312.321.6101 Fax: 312.396.2392

F.A.I. RTE.	SECTION	COUNTY	TOTAL SHEETS	SHEET NO.
55	2002-022 K	WILL	172	50
STA. 10+00		TO STA. 22+96.05		
FED. ROAD DIST. NO.		ILLINOIS	FED. AID PROJECT	
CONTRACT NO. 62389				

PLAN	DATE	BY
SURVEYED		
DESIGNED		
CHECKED		
IN CHARGE		
NOTE BOOK		
NO.		

PROFILE	DATE	BY
SURVEYED		
DESIGNED		
CHECKED		
IN CHARGE		
NOTE BOOK		
NO.		

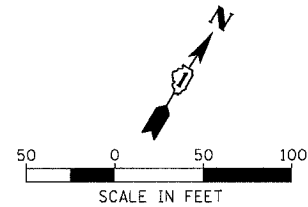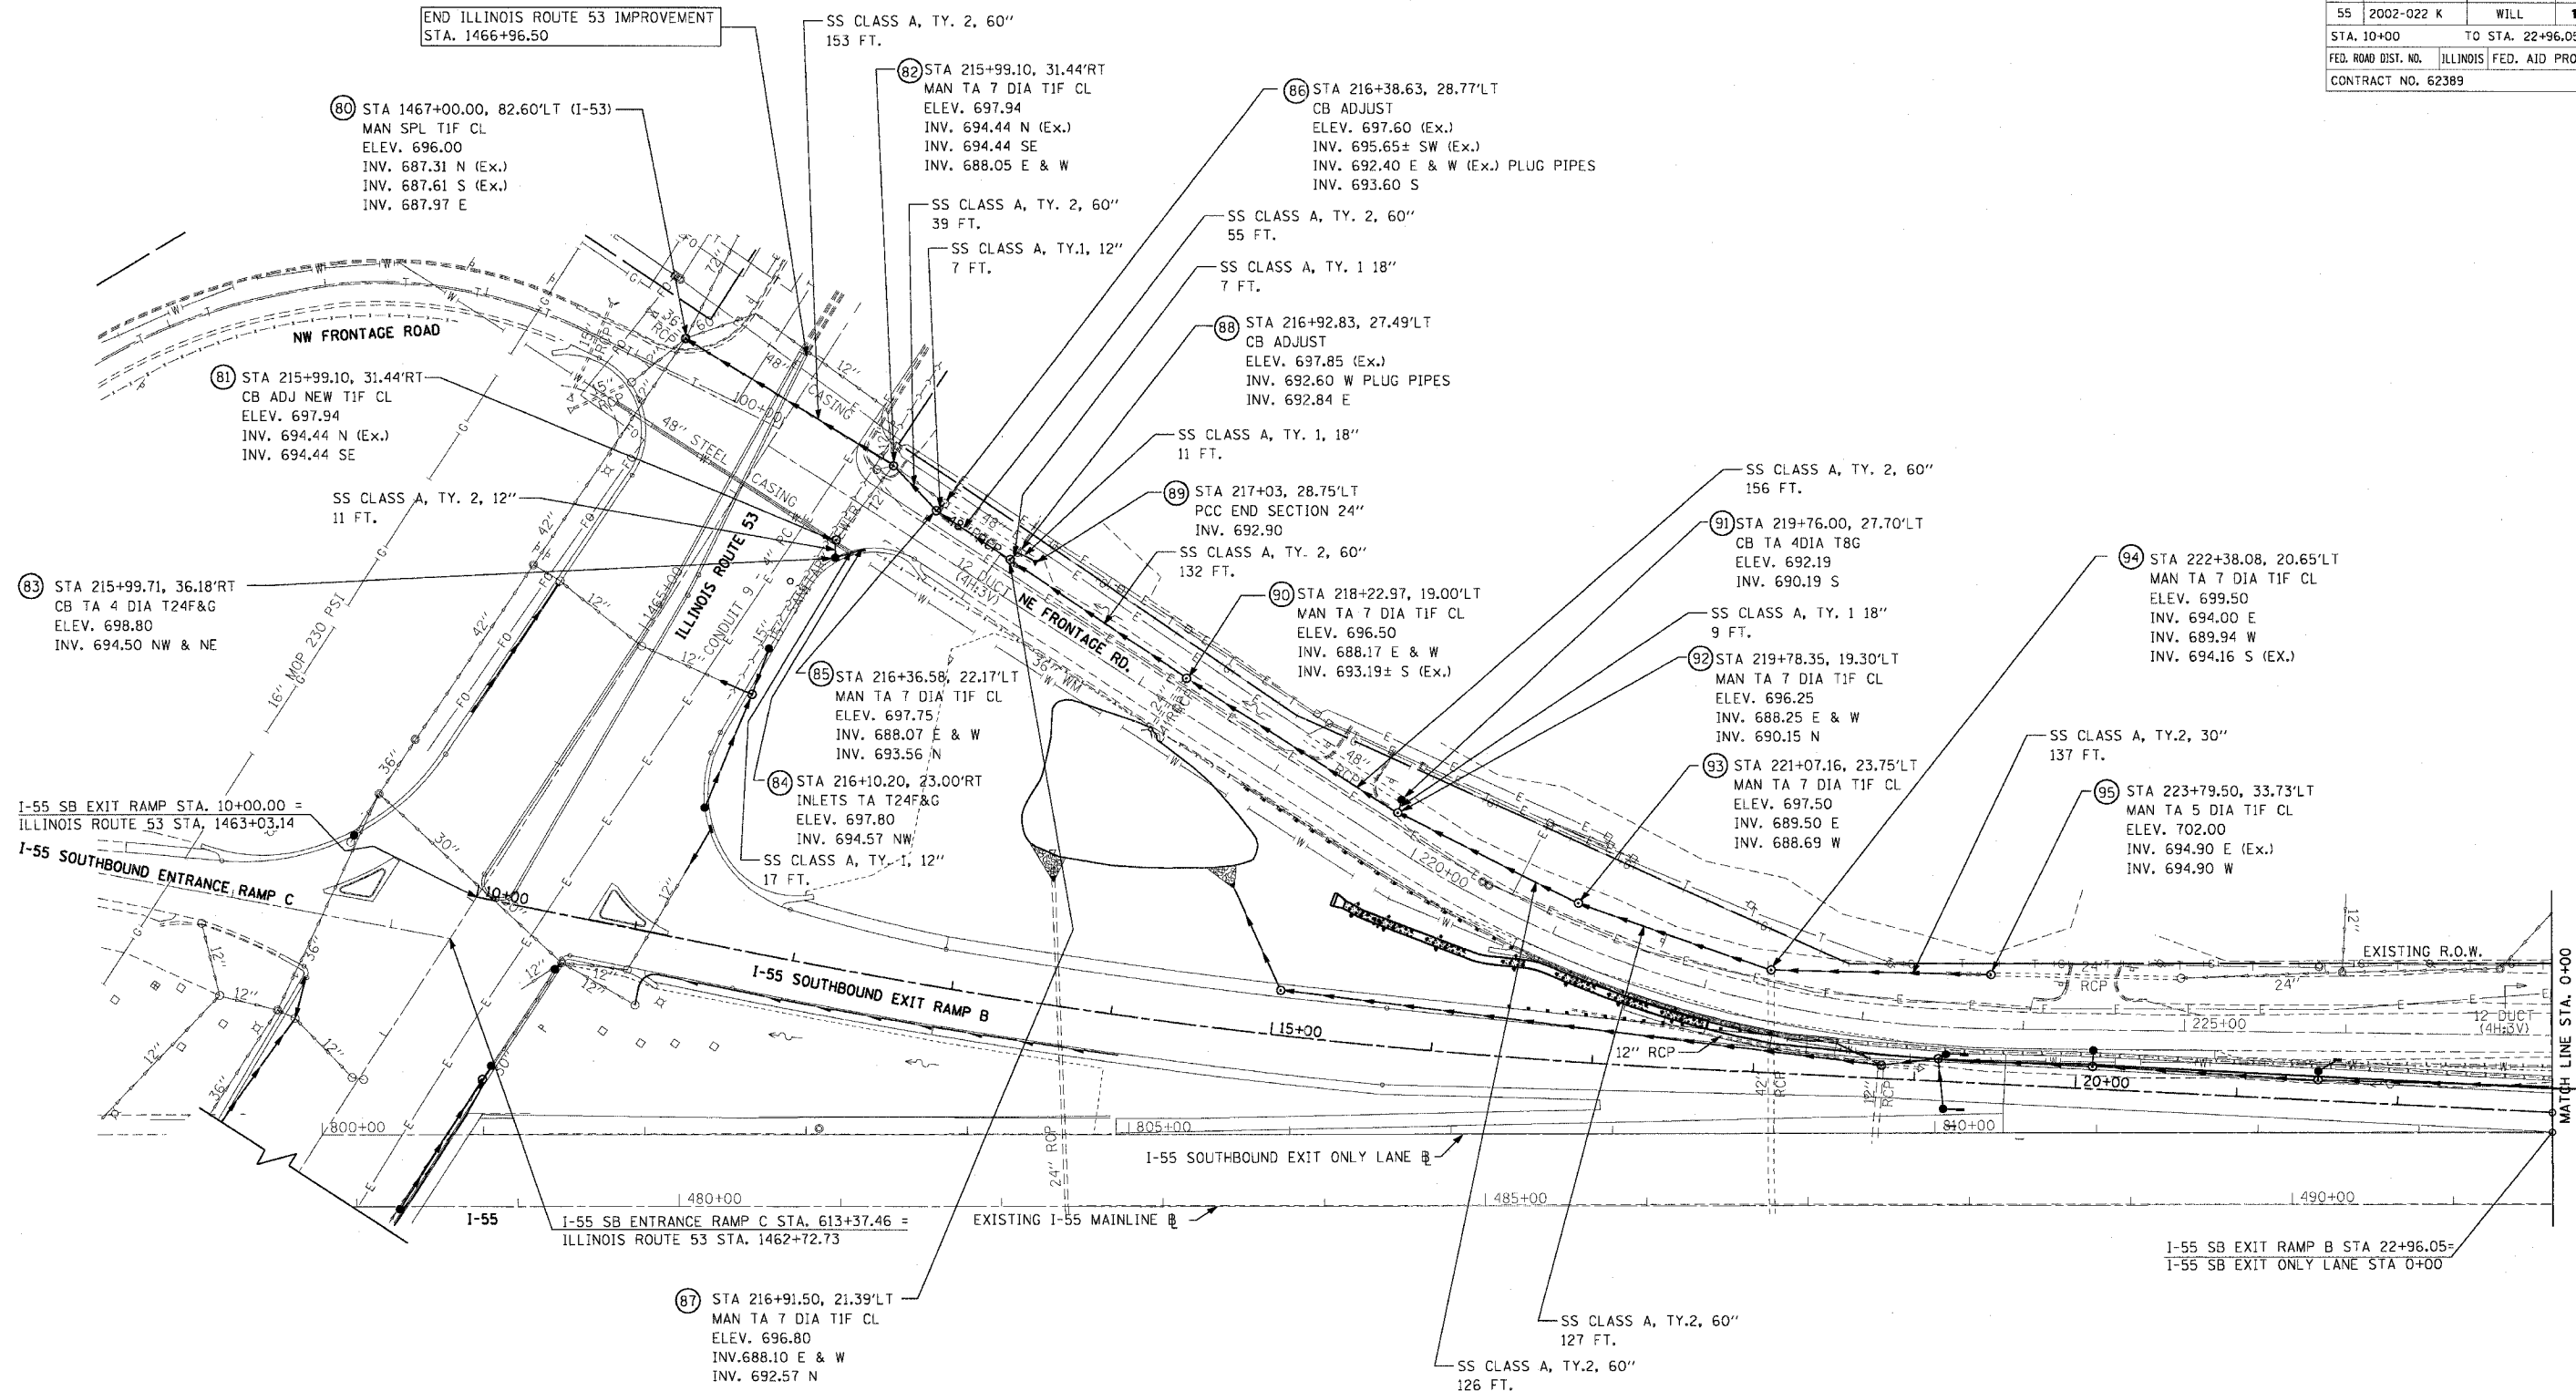

DMJM HARRIS
 303 East Wacker Drive, Suite 600
 Chicago, Illinois, 60601 Phone: 312.321.6101 Fax: 312.396.2392

REVISIONS	
NAME	DATE

ILLINOIS DEPARTMENT OF TRANSPORTATION



PROPOSED DRAINAGE PLAN
 I-55 SOUTHBOUND EXIT NE FRONTAGE ROAD
 STA 214+44.25 TO STA 224+25.00

SCALE: 1"=50'
 DATE: 12/23/2004

DRAWN BY: CC
 CHECKED BY: RI



OCTOBER, 2004

PROFILE	SURVEYED	BY	DATE
NOTE BOOK	GRADES CHECKED		
NO.	B.M. NOTED		
	STRUCTURE NOTATIONS CHK'D		

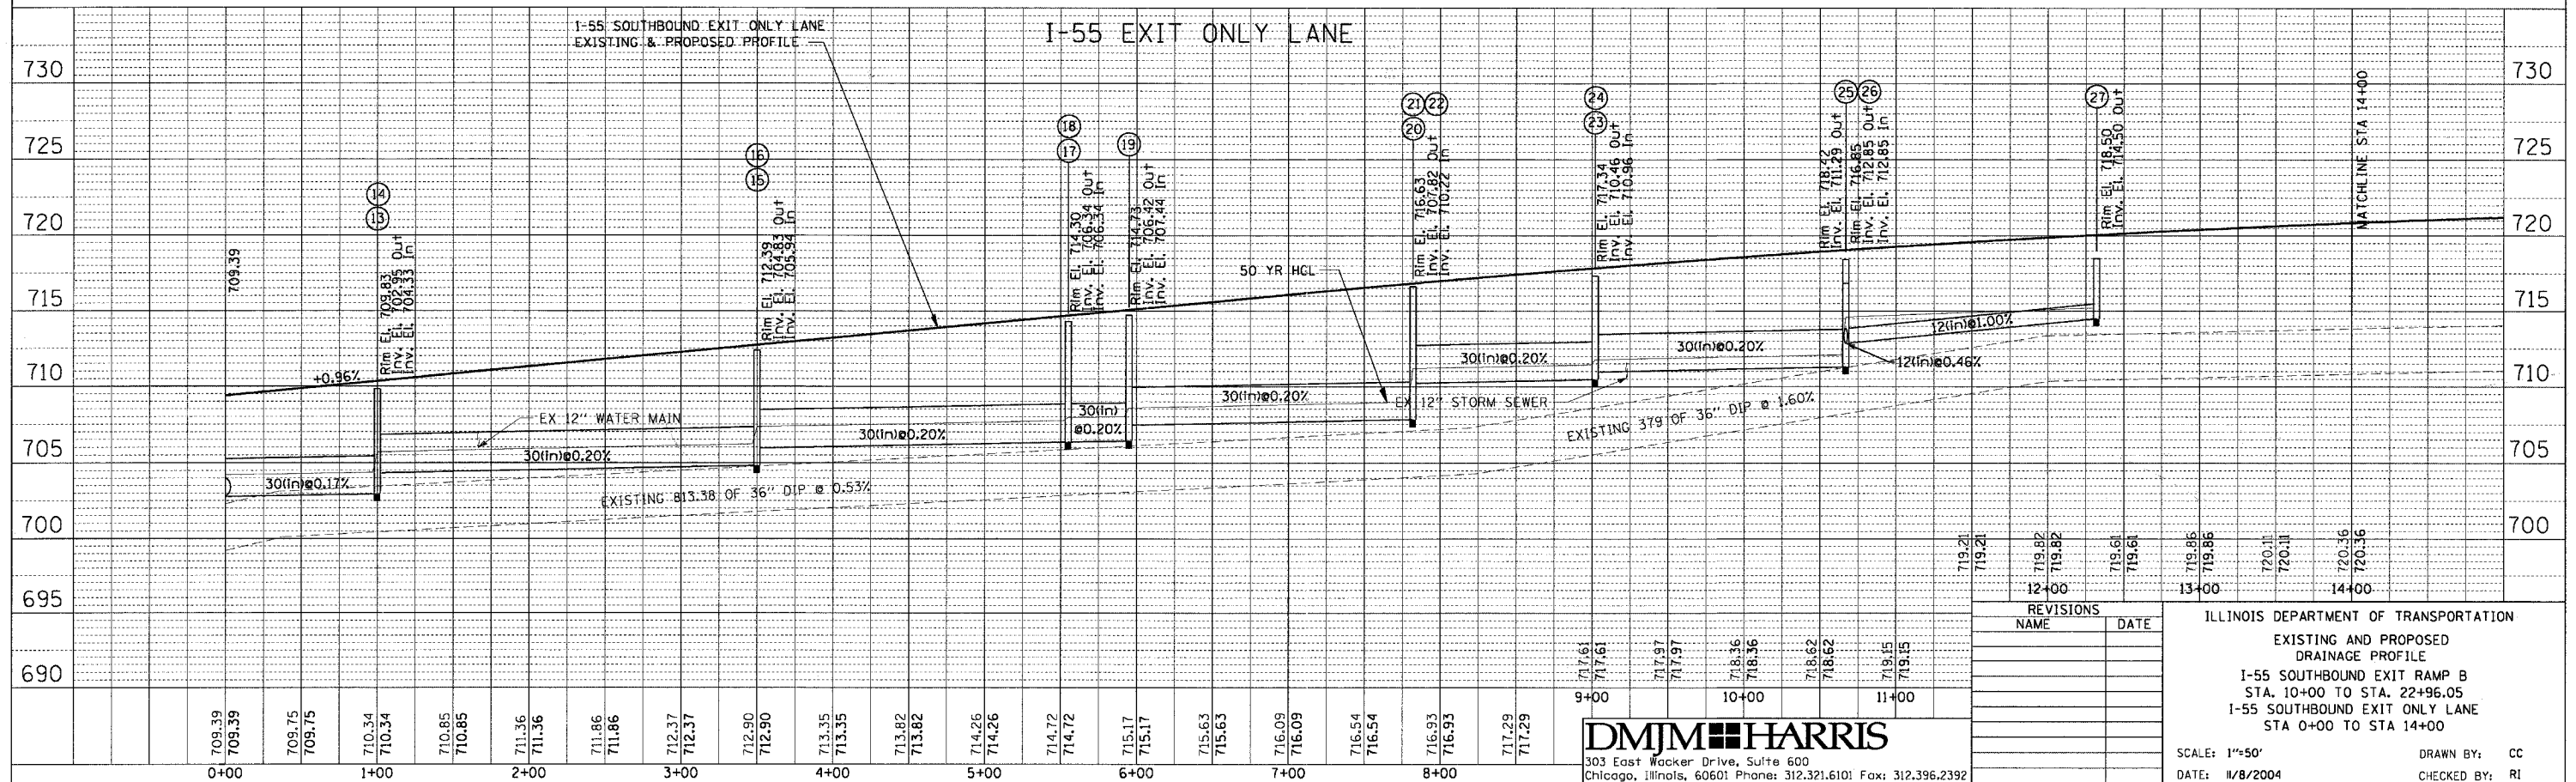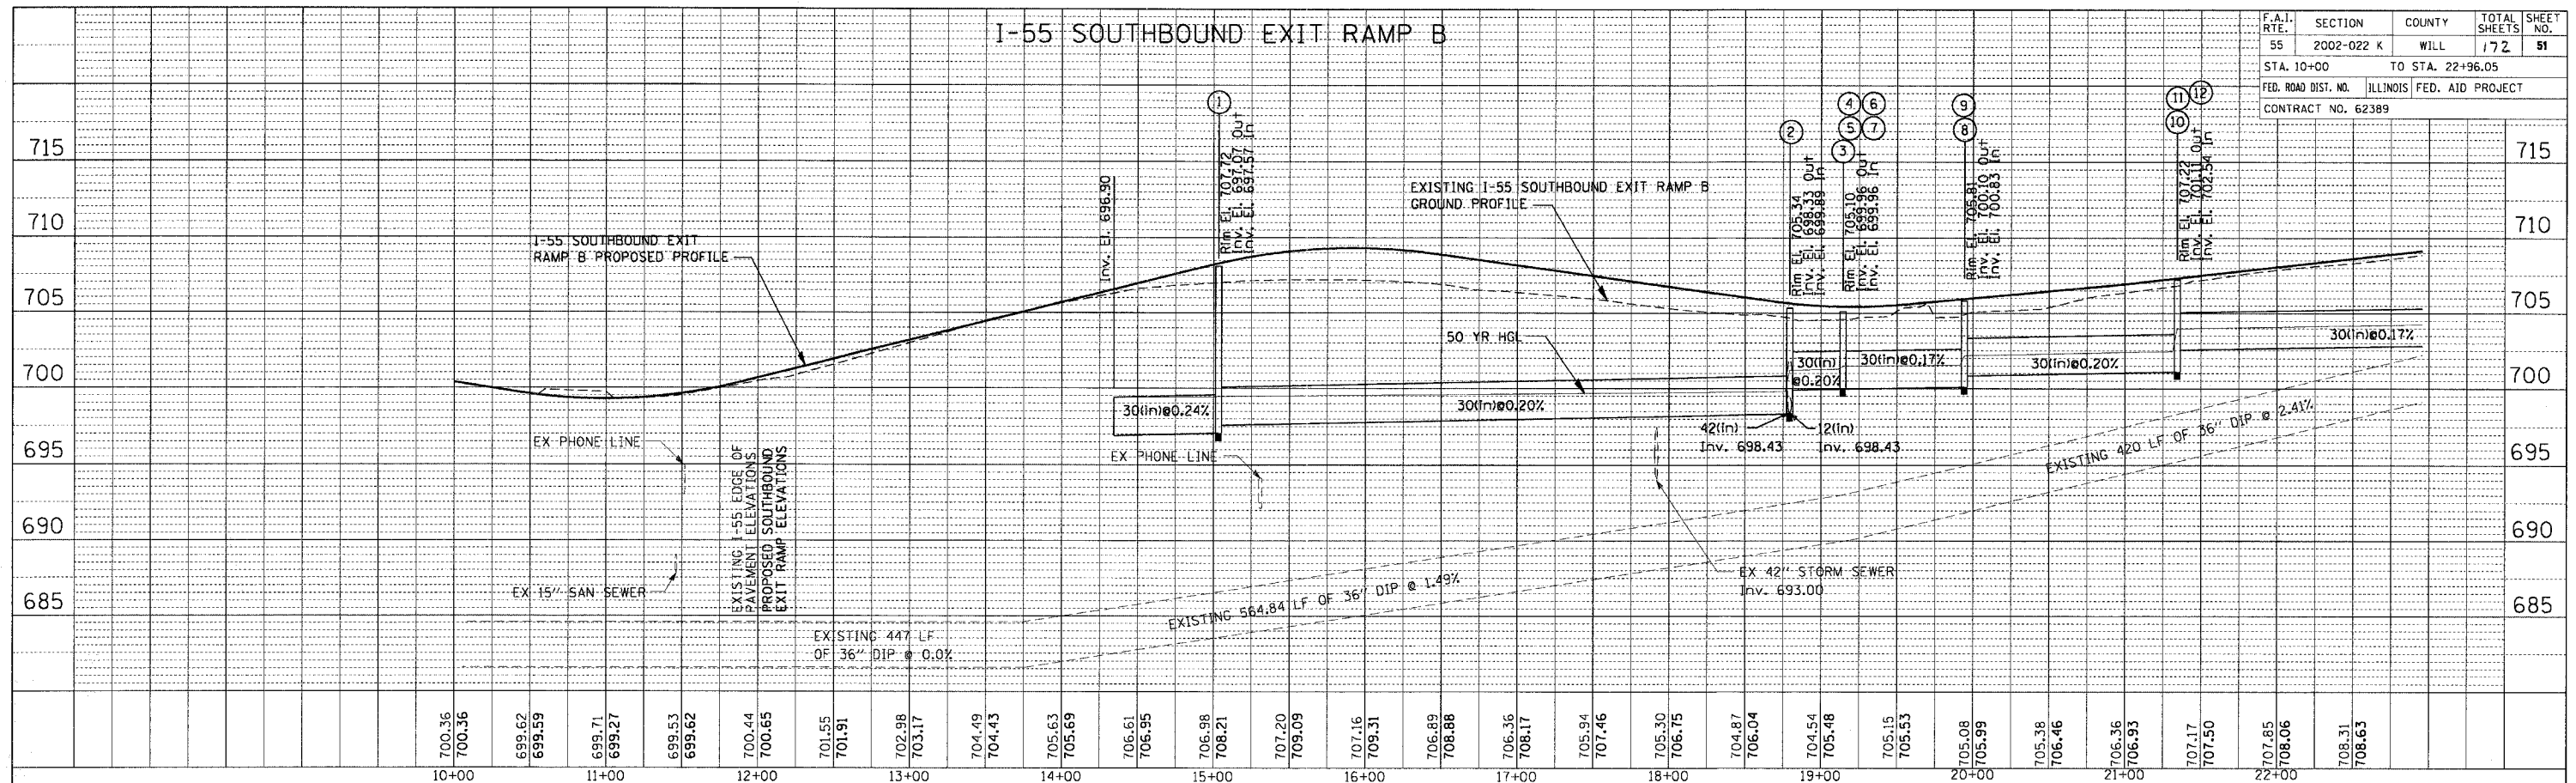

PLAN
REVISIONS
NO. DATE
BY
CHECKED
DATE
BY
NOTE BOOK
NO. FILE NAME

PROFILE
REVISIONS
NO. DATE
BY
CHECKED
DATE
BY
NOTE BOOK
NO. FILE NAME

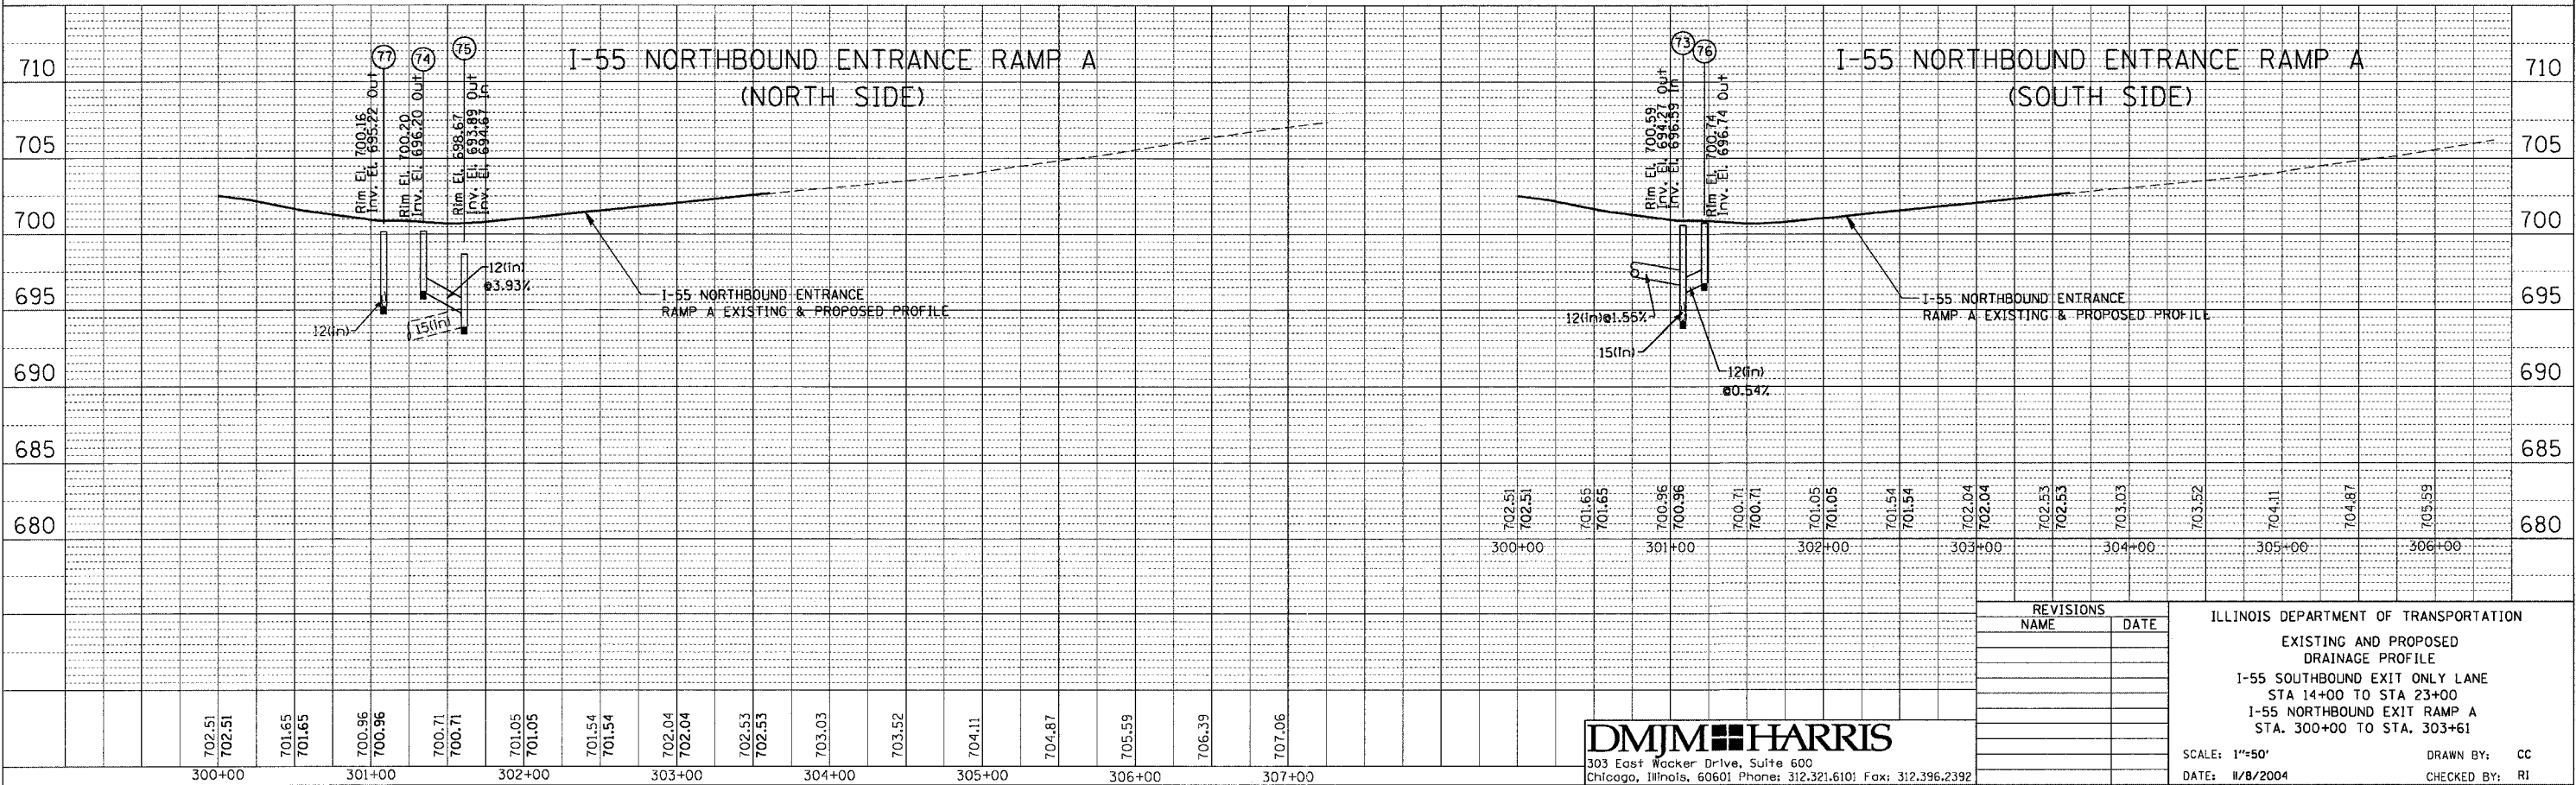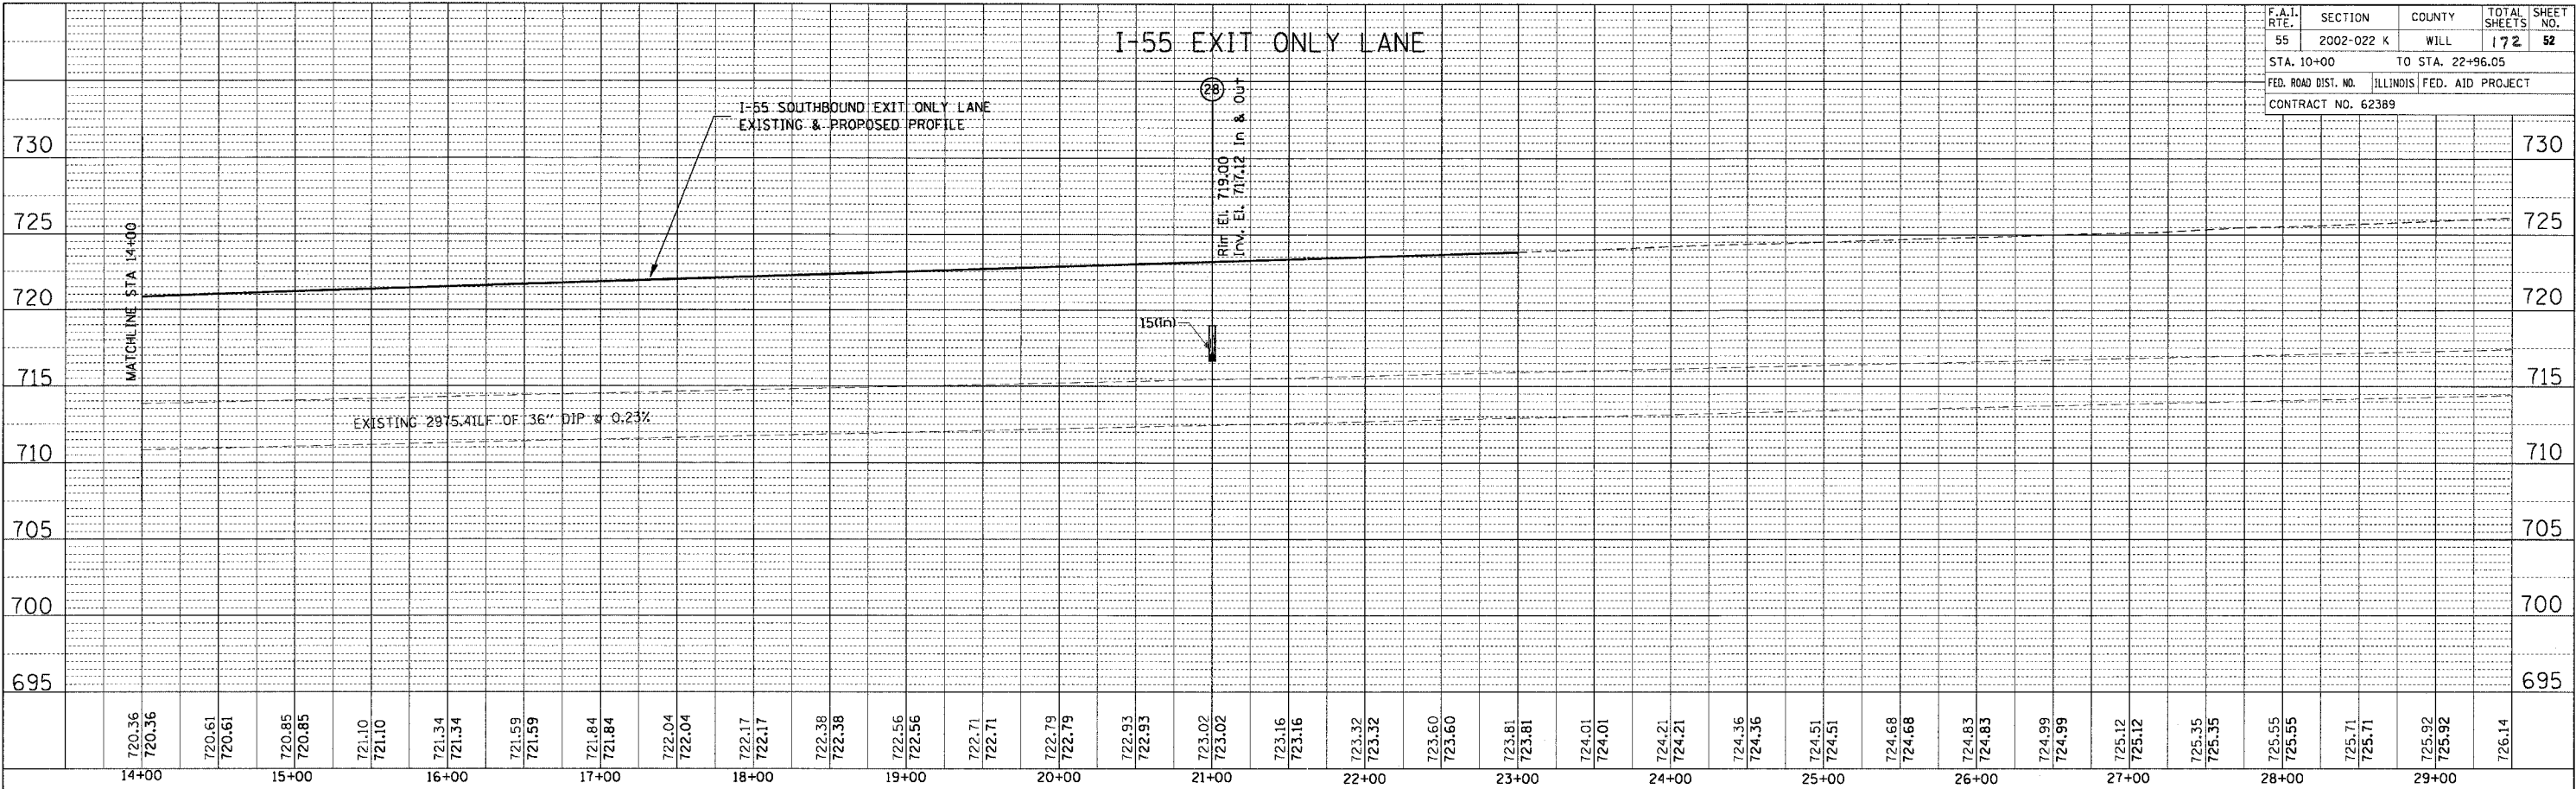

DMJM HARRIS
303 East Wacker Drive, Suite 600
Chicago, Illinois, 60601 Phone: 312.321.6101 Fax: 312.396.2392



REVISIONS	
NAME	DATE

ILLINOIS DEPARTMENT OF TRANSPORTATION
EXISTING AND PROPOSED
DRAINAGE PROFILE
I-55 SOUTHBOUND EXIT ONLY LANE
STA 14+00 TO STA 23+00
I-55 NORTHBOUND EXIT RAMP A
STA. 300+00 TO STA. 303+61
SCALE: 1"=50'
DATE: 11/8/2004
DRAWN BY: CC
CHECKED BY: RI

PLAN	REVISIONS	BY	DATE
NOTE BOOK	ALIGNED CHECKED		
NO.	FILE NAME		

PROFILE	REVISIONS	BY	DATE
NOTE BOOK	GRADES CHECKED		
NO.	STRUCTURE NOTATIONS CHECKED		

F.A.T. RTE.	SECTION	COUNTY	TOTAL SHEETS	SHEET NO.
55	2002-022 K	WILL	172	53
STA. 10+00 TO STA. 22+96.05				
FED. ROAD DIST. NO. ILLINOIS FED. AID PROJECT				
CONTRACT NO. 62389				

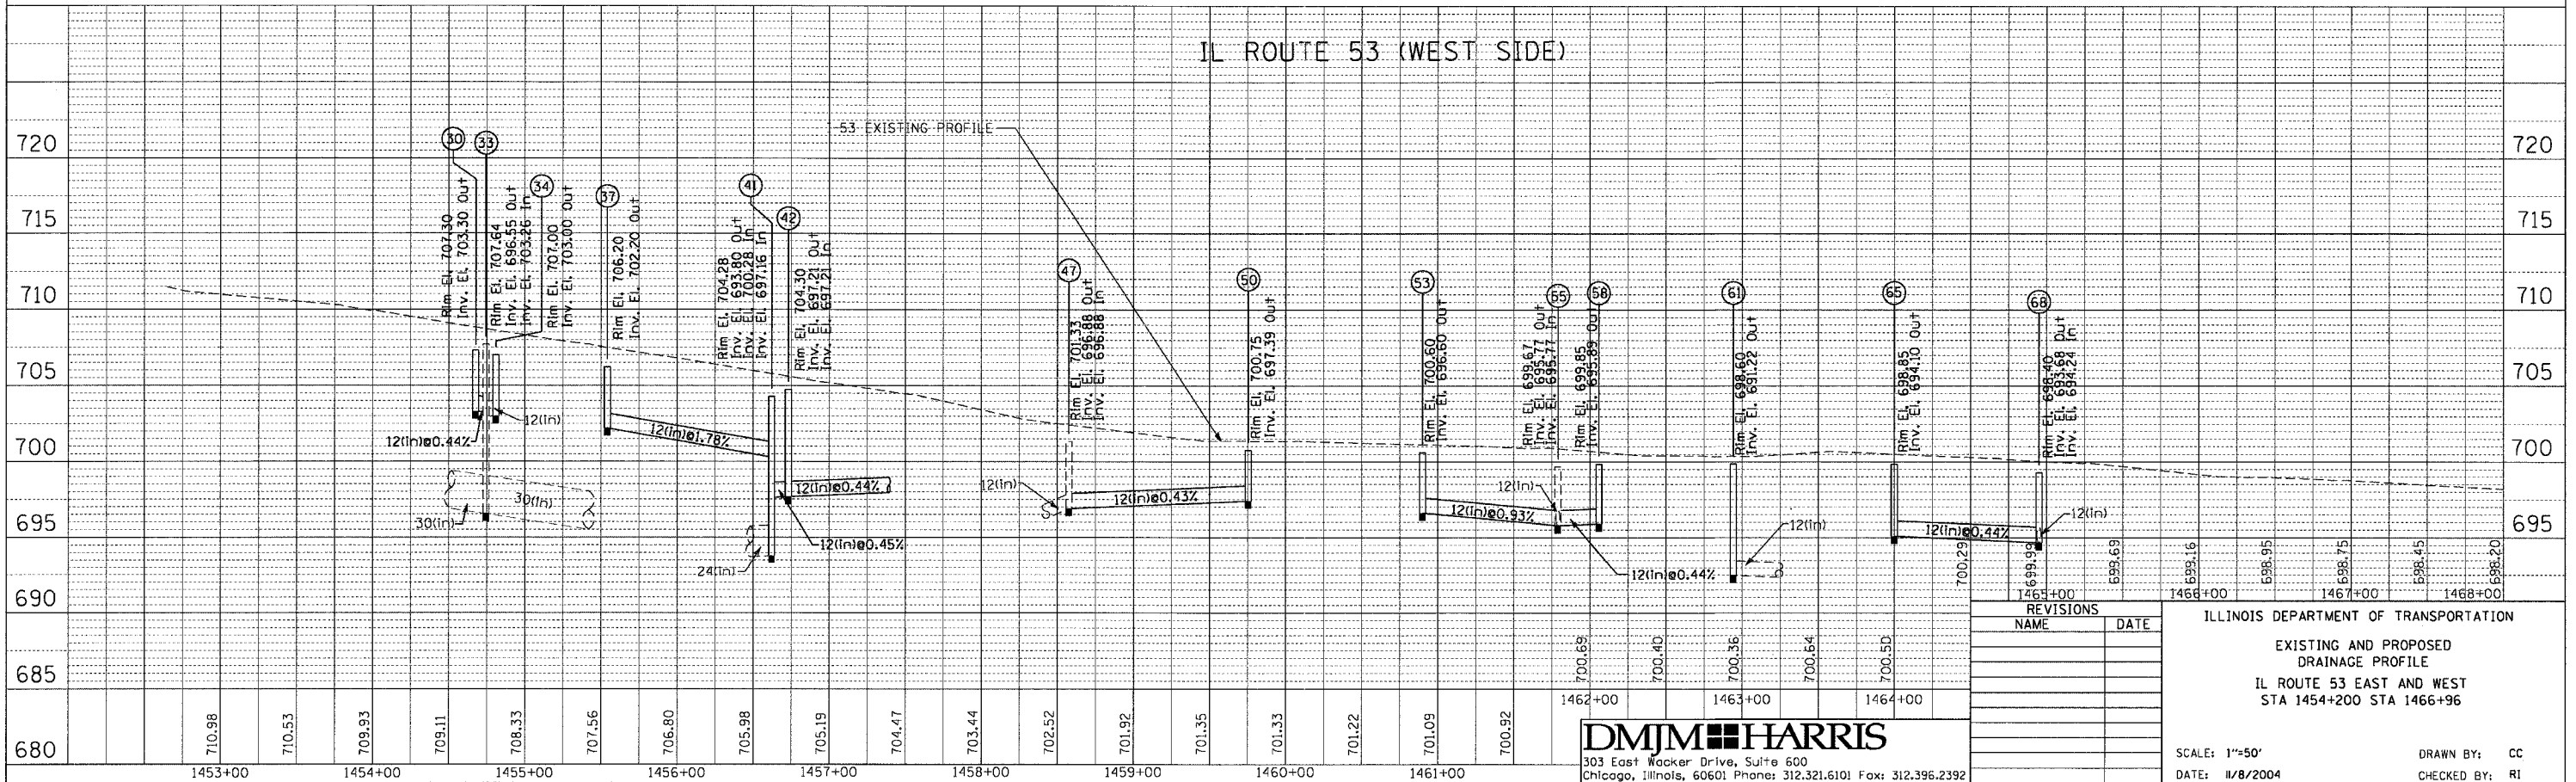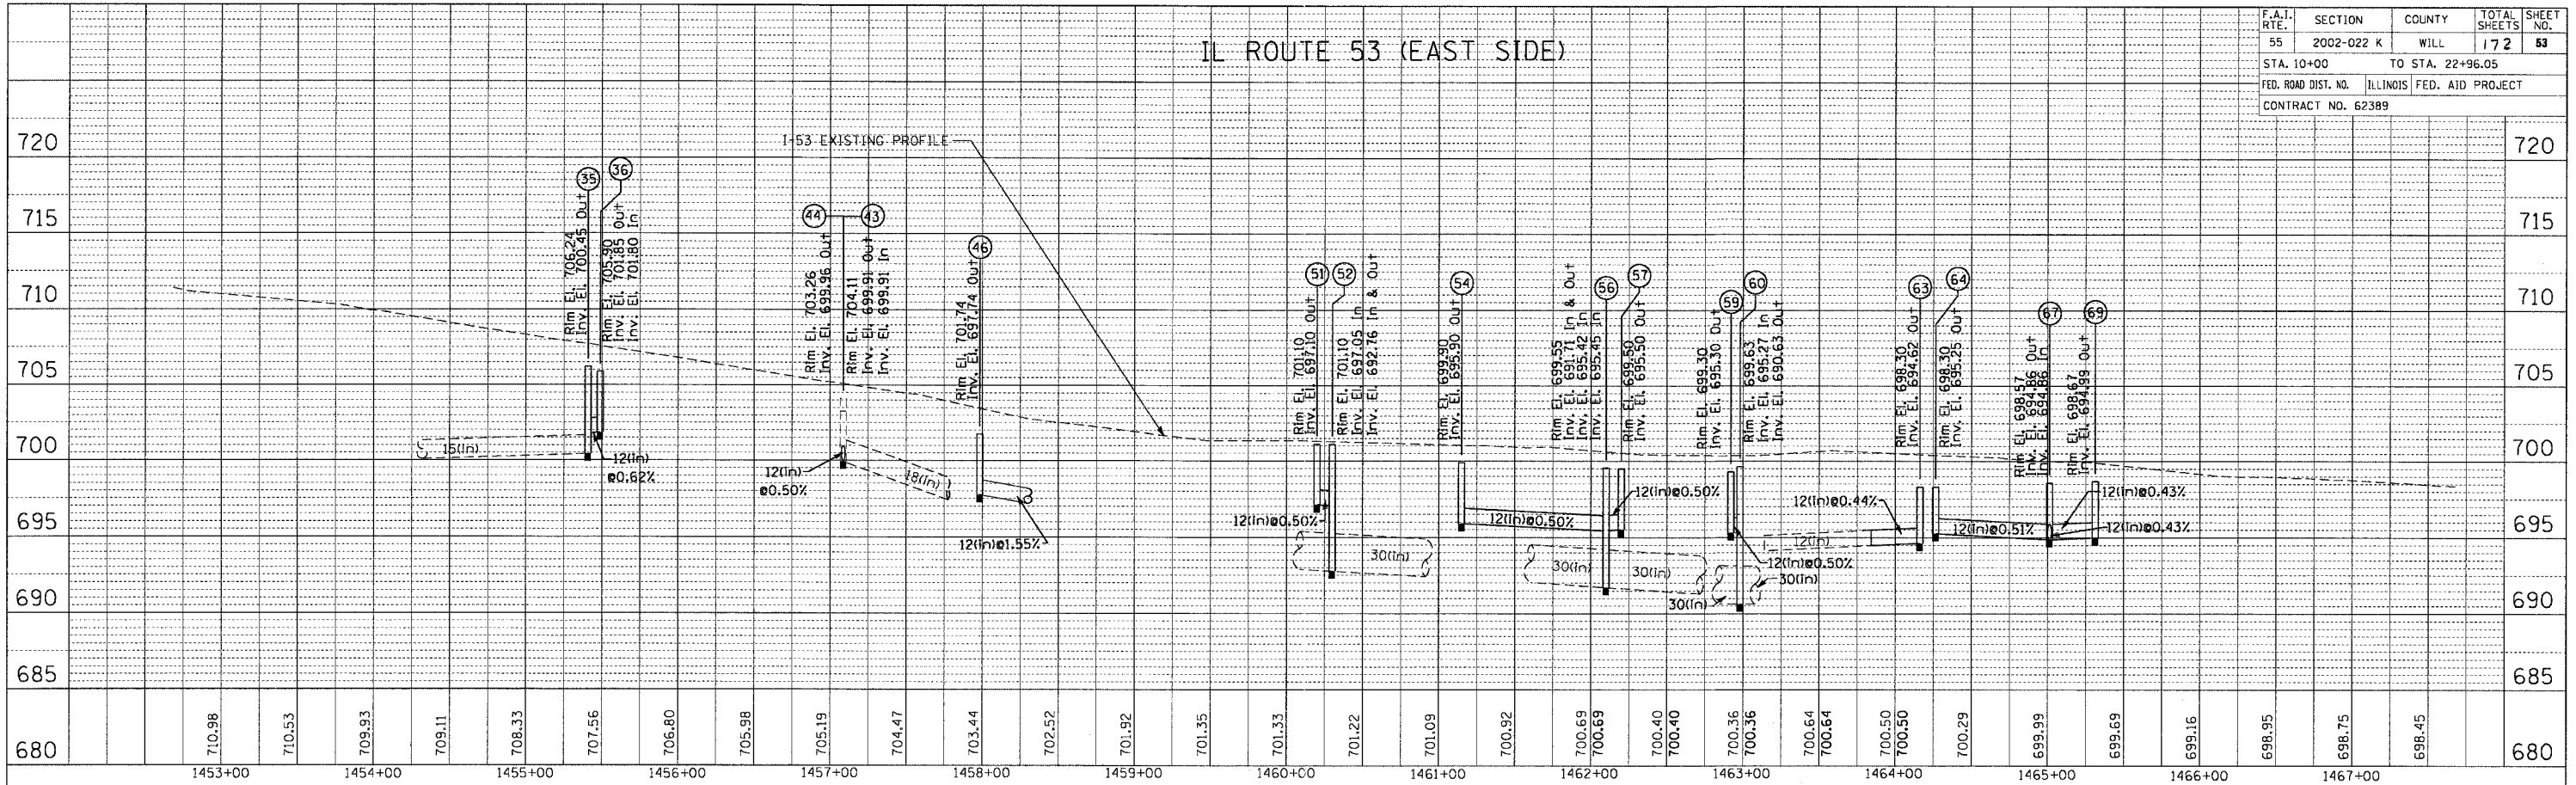

DMJM HARRIS
303 East Wacker Drive, Suite 600
Chicago, Illinois, 60601 Phone: 312.321.6101 Fax: 312.396.2392



REVISIONS	
NAME	DATE

ILLINOIS DEPARTMENT OF TRANSPORTATION
EXISTING AND PROPOSED
DRAINAGE PROFILE
IL ROUTE 53 EAST AND WEST
STA 1454+200 STA 1466+96
SCALE: 1"=50'
DATE: 11/8/2004
DRAWN BY: CC
CHECKED BY: RI
OCTOBER, 2004

PLAN
REVISIONS
DATE
BY
NO.
NOTE BOOK
NO.
FILE NAME

PROFILE
REVISIONS
DATE
BY
NO.
NOTE BOOK
NO.
FILE NAME

F.A.I. RTE.	SECTION	COUNTY	TOTAL SHEETS	SHEET NO.
55	2002-022 K	WILL	172	54
STA. 10+00 TO STA. 22+96.05				
FED. ROAD DIST. NO. ILLINOIS FED. AID PROJECT				
CONTRACT NO. 62389				

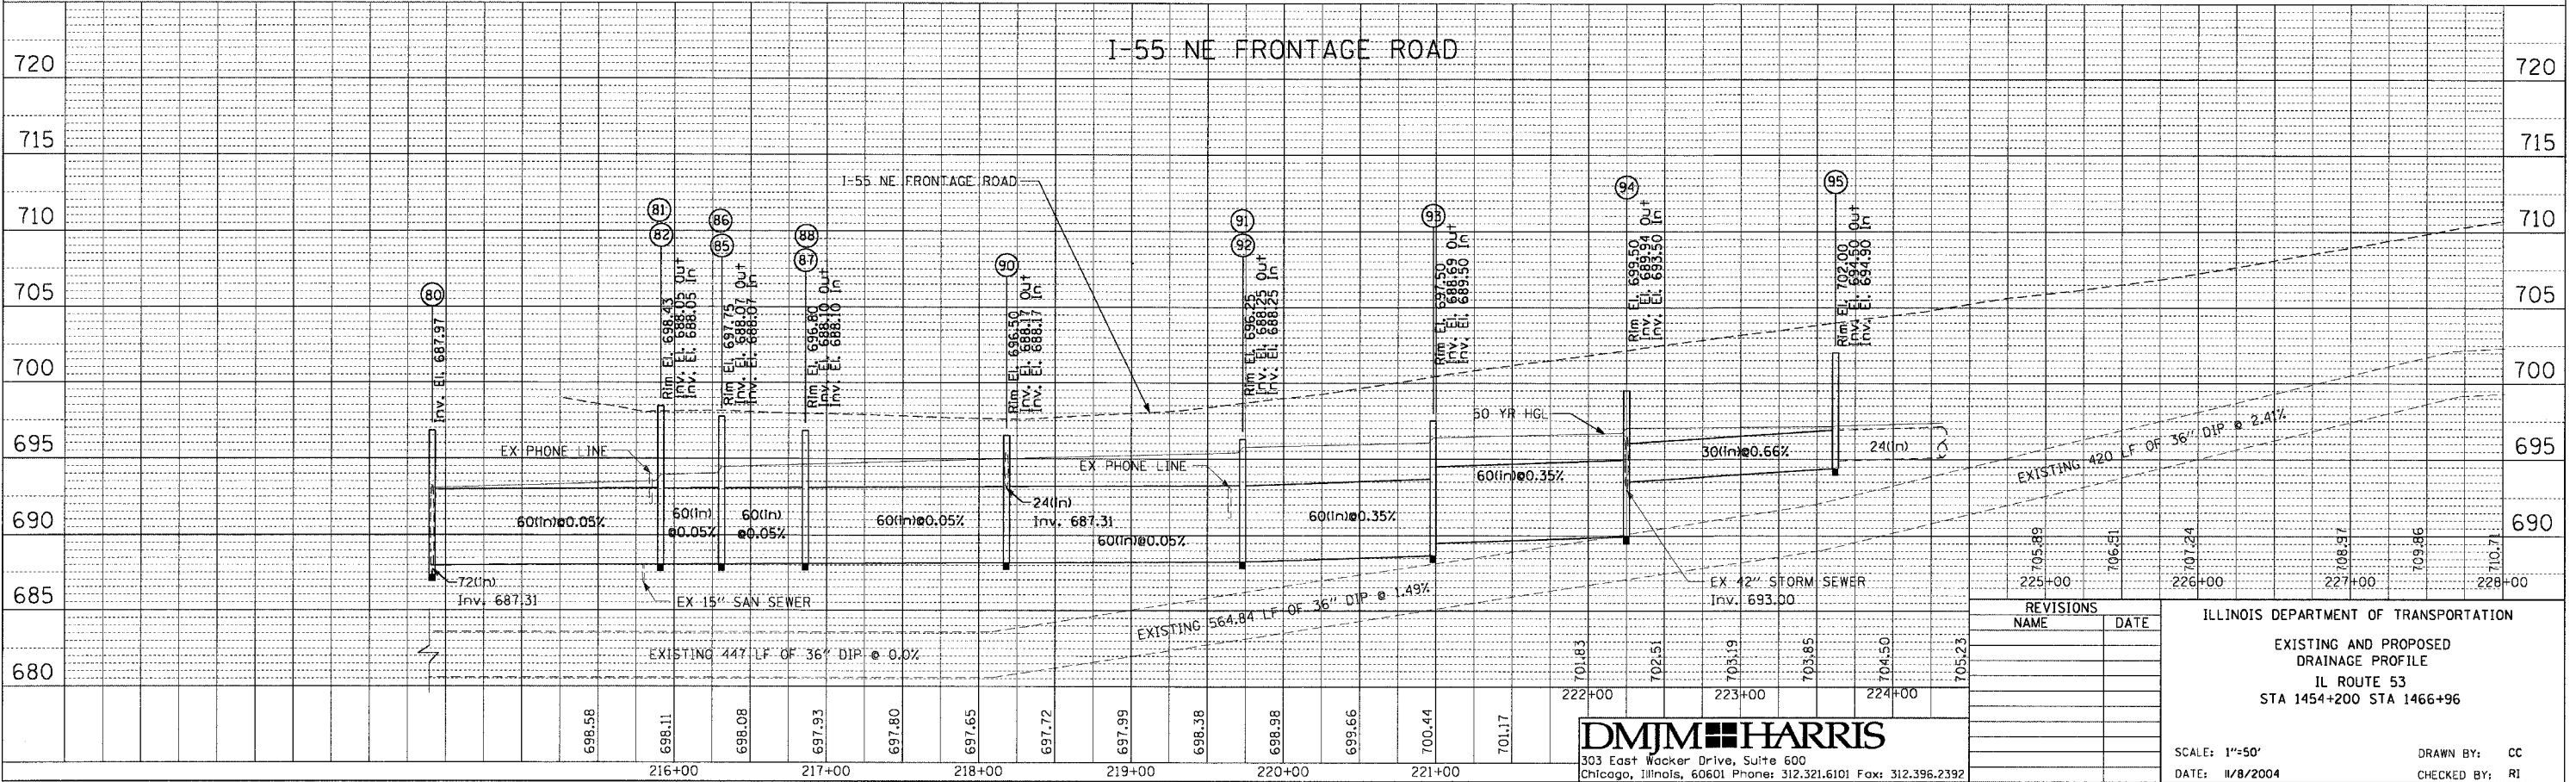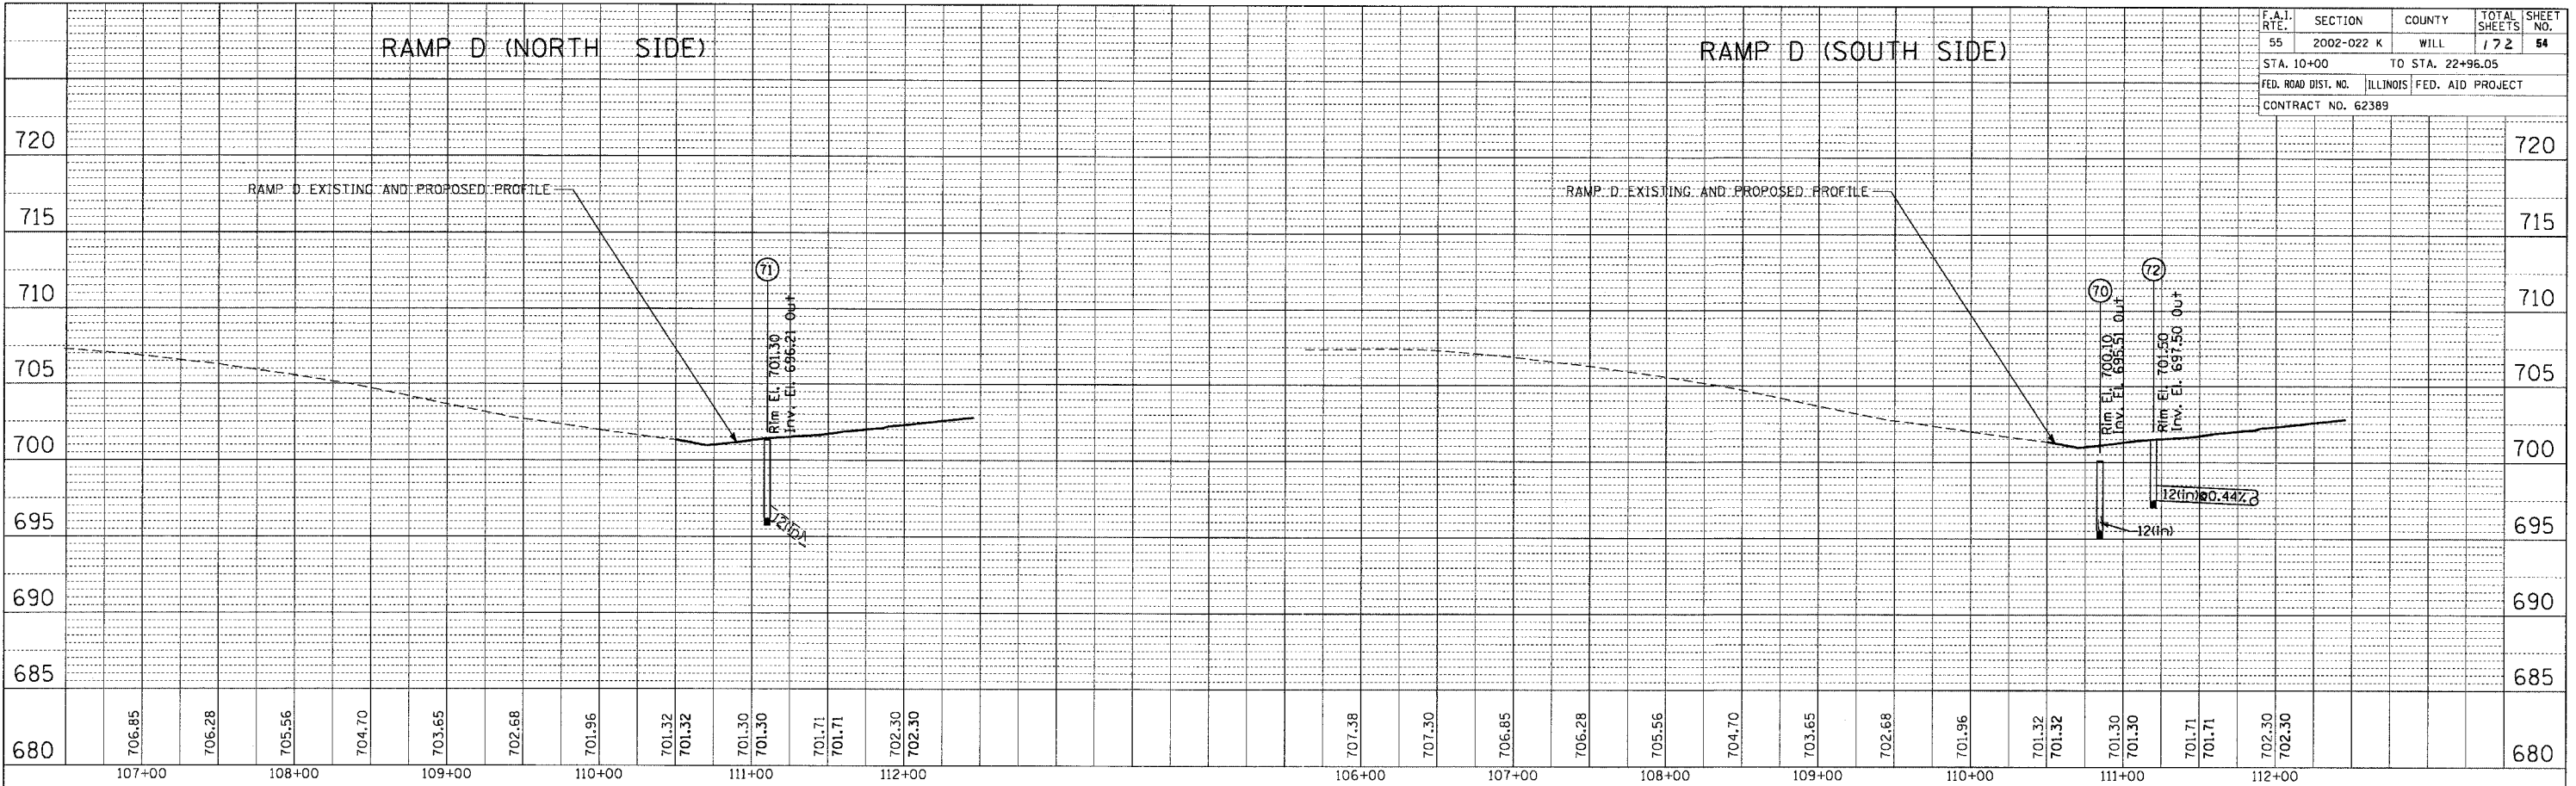

DMJM HARRIS
303 East Wacker Drive, Suite 600
Chicago, Illinois, 60601 Phone: 312.321.6101 Fax: 312.396.2392

REVISIONS	
NAME	DATE

ILLINOIS DEPARTMENT OF TRANSPORTATION
EXISTING AND PROPOSED
DRAINAGE PROFILE
IL ROUTE 53
STA 1454+200 STA 1466+96

SCALE: 1"=50'
DATE: 11/8/2004

DRAWN BY: CC
CHECKED BY: RI