
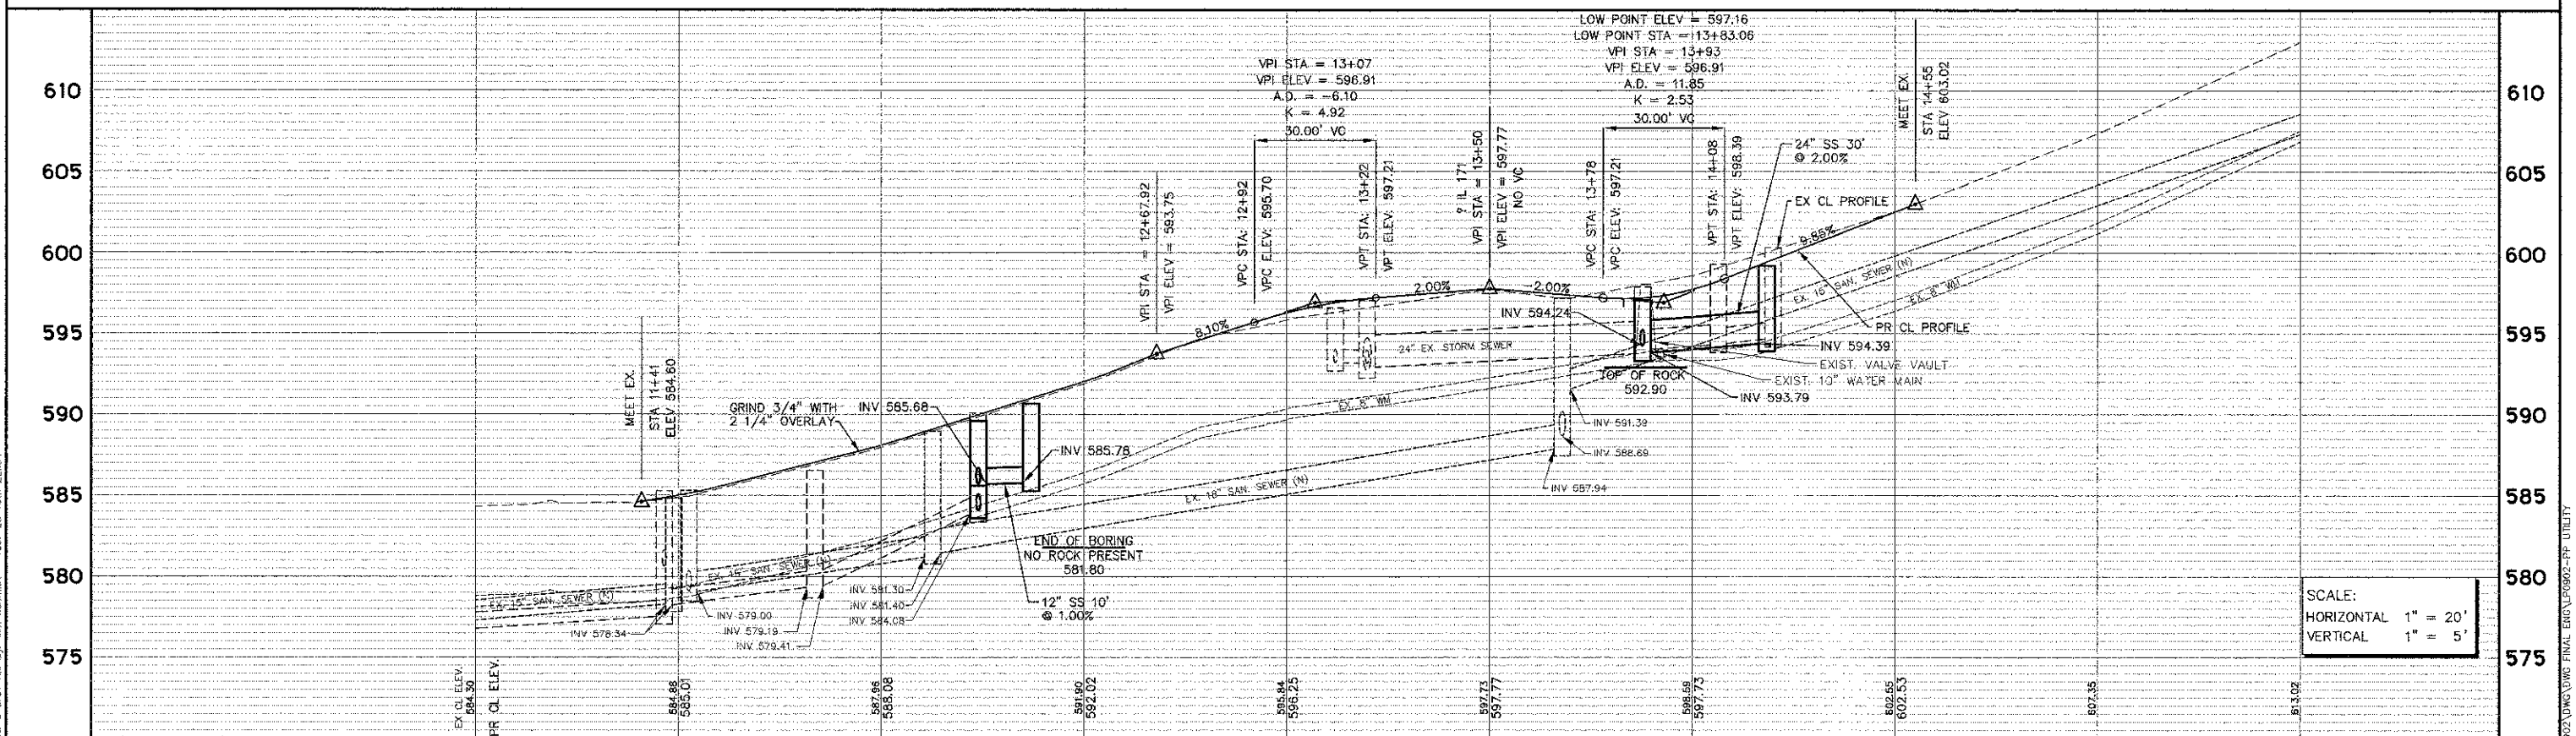


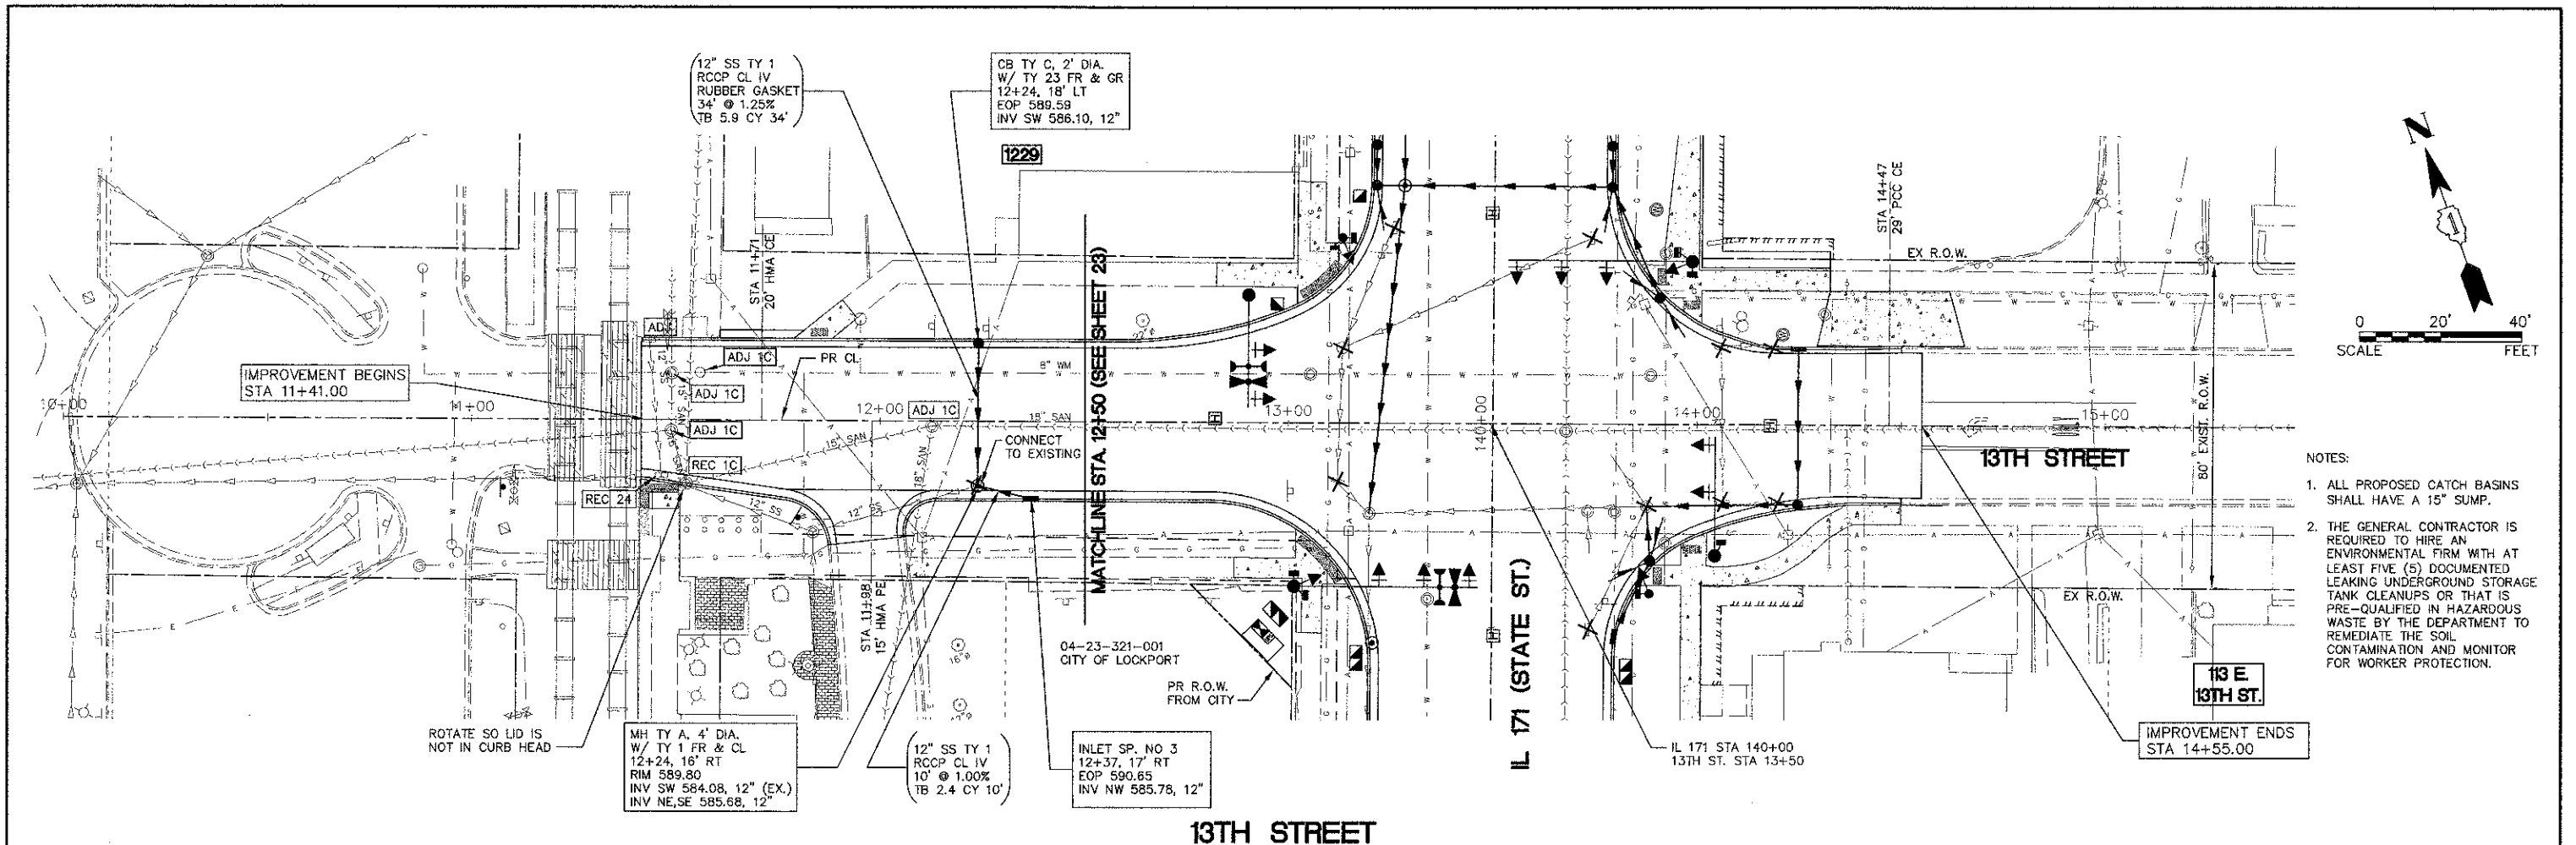

Engineering Enterprises, Inc. CONSULTING ENGINEERS 52 Wheeler Road Sugar Grove, Illinois 60554 630.466.6700 / www.eelweb.com				STATE OF ILLINOIS DEPARTMENT OF TRANSPORTATION				13th STREET DRAINAGE AND UTILITY PLAN AND PROFILE				F.A.P. RTE. 577 SECTION 10-00066-00-TL COUNTY WILL TOTAL SHEETS 65 SHEET NO. 25 CONTRACT NO. 63788			
USER NAME = Jim Schmidt PLOT SCALE = PLOT DATE = February 8, 2013				DESIGNED - JRL & SWM DRAWN - CLN CHECKED - JL DATE - 11/13/12				REVISED - JPS 02/08/13 REVISED - REVISED - REVISED -				SCALE: HORIZ 1"=20' VERT 1"=5' SHEET NO. 4 OF 4 SHEETS STA. 11+00 TO STA. 15+50			