

F.A.U. ROUTE	SECTION	COUNTY	TOTAL SHEETS	SHEET NUMBER
9521	10-00051-00-SW	PERRY	33	1
CITY OF DU QUOIN			PROJECT NO. TE-0009(105)	
CONTRACT NO. 99499			JOB NO. C-99-512-11	


INDEX OF SHEETS

SHEET NO	DESCRIPTION
1	TITLE SHEET, INDEX OF SHEETS AND PROJECT LOCATION MAP
2	SUMMARY OF QUANTITIES AND TYPICAL SECTIONS
3	MISCELLANEOUS DETAILS
4	EXISTING SITE AND REMOVAL PLAN - STA. 0+00 TO STA. 3+00
5	EXISTING SITE AND REMOVAL PLAN - STA. 3+00 TO STA. 6+00
6	EXISTING SITE AND REMOVAL PLAN - STA. 6+00 TO STA. 9+00
7	EXISTING SITE AND REMOVAL PLAN - STA. 9+00 TO STA. 12+25
8	EXISTING SITE AND REMOVAL PLAN - STA. 12+25 TO STA. 15+25
9	EXISTING SITE AND REMOVAL PLAN - STA. 15+25 TO STA. 18+50
10	EXISTING SITE AND REMOVAL PLAN - STA. 18+50 TO STA. 21+50
11	PROPOSED SIDEWALK PLAN - STA. 0+00 TO STA. 3+00
12	PROPOSED SIDEWALK PLAN - STA. 3+00 TO STA. 6+00
13	PROPOSED SIDEWALK PLAN - STA. 6+00 TO STA. 9+25
14	PROPOSED SIDEWALK PLAN - STA. 9+25 TO STA. 12+25
15	PROPOSED SIDEWALK PLAN - STA. 12+25 TO STA. 15+25
16	PROPOSED SIDEWALK PLAN - STA. 15+25 TO STA. 18+50
17	PROPOSED SIDEWALK PLAN - STA. 18+50 TO STA. 21+50
18	PROPOSED ELECTRICAL PLAN - STA. 0+00 TO STA. 3+00
19	PROPOSED ELECTRICAL PLAN - STA. 3+00 TO STA. 6+00
20	PROPOSED ELECTRICAL PLAN - STA. 6+00 TO STA. 9+25
21	PROPOSED ELECTRICAL PLAN - STA. 9+25 TO STA. 12+25
22	PROPOSED ELECTRICAL PLAN - STA. 12+25 TO STA. 15+25
23	PROPOSED ELECTRICAL PLAN - STA. 15+25 TO STA. 18+50
24	PROPOSED ELECTRICAL PLAN - STA. 18+50 TO STA. 21+50
25	TYPICAL TREE GRATE ELECTRICAL PLAN AND TYPICAL POST LIGHT / TREE GRATE SCHEMATIC
26	HANDICAP RAMP LAYOUT - STA. 0+00 TO STA. 3+00
27	HANDICAP RAMP LAYOUT - STA. 3+00 TO STA. 6+00
28	HANDICAP RAMP LAYOUT - STA. 6+00 TO STA. 9+25
29	HANDICAP RAMP LAYOUT - STA. 9+25 TO STA. 12+25
30	HANDICAP RAMP LAYOUT - STA. 12+25 TO STA. 15+25
31	HANDICAP RAMP LAYOUT - STA. 15+25 TO STA. 18+50
32	HANDICAP RAMP LAYOUT - STA. 18+50 TO STA. 21+50
33	STORM WATER POLLUTION PREVENTION PLAN

LIST OF HIGHWAY STANDARDS

HIGHWAY STANDARD NO.	TITLE
424001-07	PERPENDICULAR CURB RAMPS FOR SIDEWALKS
424006-01	DIAGONAL CURB RAMPS FOR SIDEWALKS
424011-01	CORNER PARALLEL CURB RAMPS FOR SIDEWALKS
424021-01	DEPRESSED CORNER FOR SIDEWALKS
424026-01	ENTRANCE / ALLEY PEDESTRIAN CROSSINGS
602301-03	INLET - TYPE A
606001-05	CONCRETE CURB TYPE B AND COMBINATION CONCRETE CURB AND GUTTER
701011-03	OFF-ROAD MOVING OPERATIONS, 2L, 2W, DAY ONLY
701701-08	URBAN LANE CLOSURE, MULTILANE INTERSECTION
701801-05	SIDEWALK, CORNER OR CROSSWALK CLOSURE
701901-02	TRAFFIC CONTROL DEVICES
728001-01	TELESCOPING STEEL SIGN SUPPORT
731001-01	BASE FOR TELESCOPING STEEL SIGN SUPPORT

STATE OF ILLINOIS DEPARTMENT OF TRANSPORTATION DIVISION OF HIGHWAYS PLANS FOR PROPOSED ILLINOIS TRANSPORTATION ENHANCEMENT PROGRAM CITY OF DU QUOIN F.A.U. ROUTE 9521 SECTION 10-00051-00-SW PERRY COUNTY JOB NO. C-99-512-11 PROJECT NO. TE-00D9(105) CONTRACT NO. 99499 MAIN STREET SIDEWALK REPLACEMENT

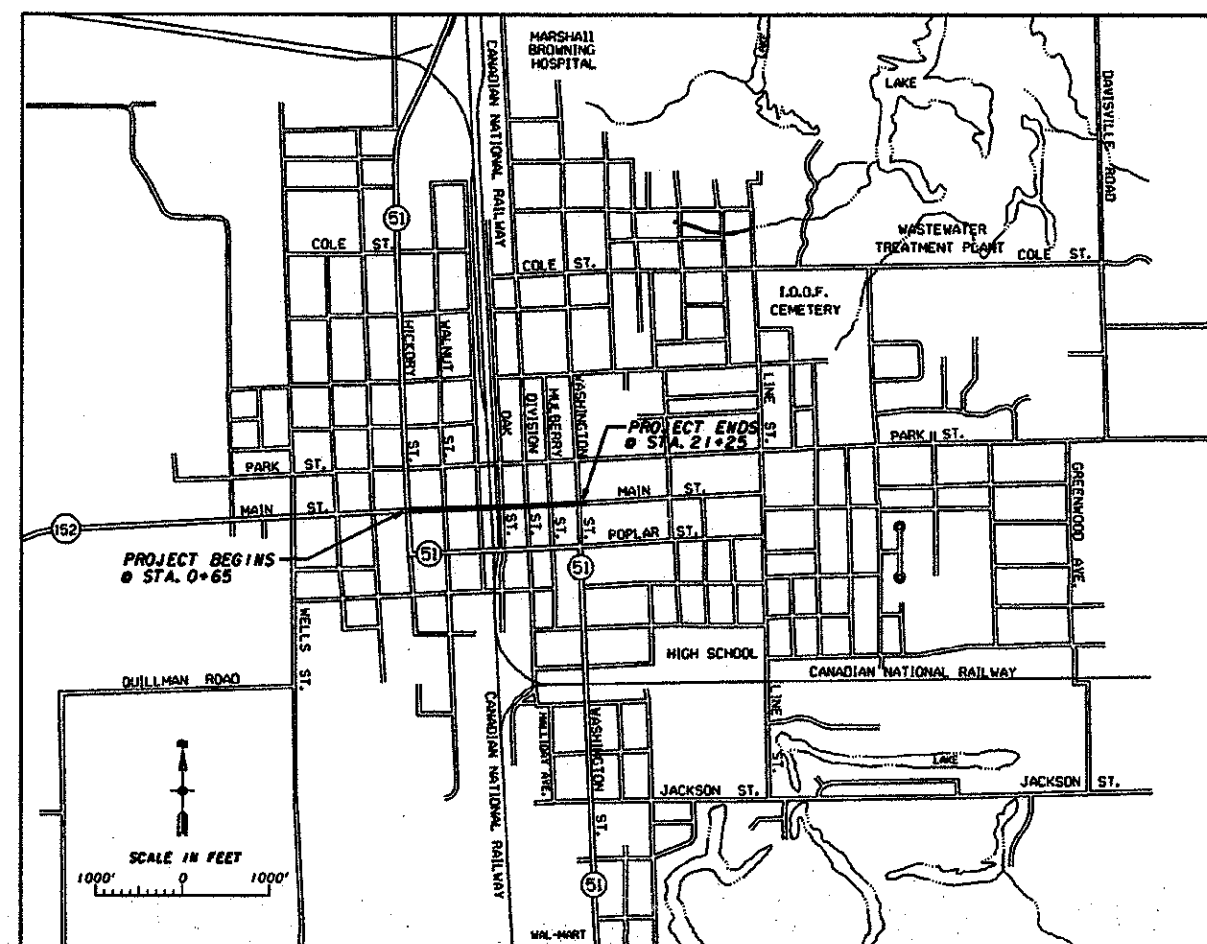



CITY OF DUQUOIN

LAYOUT
APPROXIMATE SCALE: AS SHOWN
NET LENGTH OF PROJECT - 2080 FT. • 0.390 MI.

JULIE - 1-800-892-0123
UTILITIES ON PROJECT

CITY OF DU QUOIN
AMEREN ILLINOIS COMPANY, MARION, IL.
FRONTIER, MARION, IL.
CLEAR WAVE
COMCAST

- WATER, SEWER
- ELECTRIC, GAS
- TELEPHONE
- FIBER OPTIC
- CABLE TV

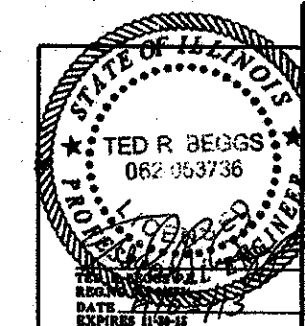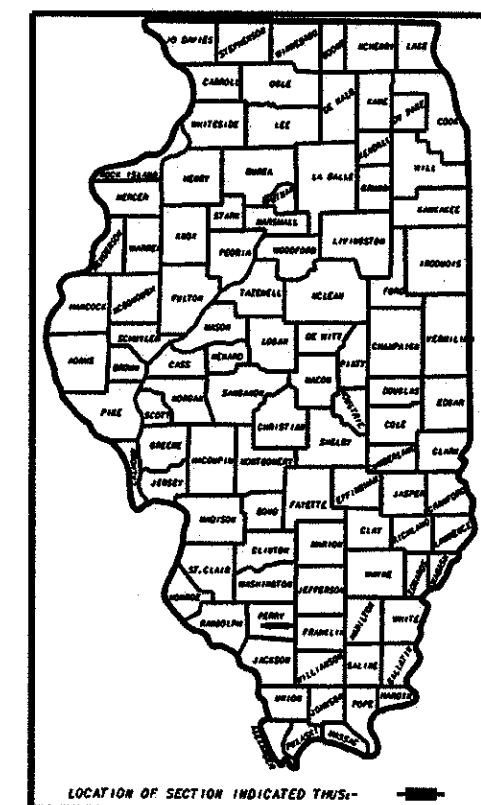

JULIE - 1-800-892-0123	
STATE OF ILLINOIS DEPARTMENT OF TRANSPORTATION	
APPROVED	20.13
REX DUNCAN - MAYOR CITY OF DU QUOIN	
PASSED	20.13
DENNIS HILLEBRENNER - DISTRICT 9 ENGINEER OF LOCAL ROADS & STREETS	
RELEASING FOR BID BASED ON LIMITED REVIEW	20.13
DEPUTY DIRECTOR OF HIGHWAYS, REGION 5 ENGINEER	

FIELD BOOK NO. 425-S	J. T. BLANKSHIP, INC. CONSULTING ENGINEERS & LAND SURVEYORS ILLINOIS PROFESSIONAL DESIGN FIRM NO. 1594 P.O. BOX 40 • 401 S. 17TH STREET • MURPHYSBORO, ILLINOIS 62449	FILE NO. E-9477 SHEET NO. 1 OF 33
SCALE AS SHOWN		
DATE DEC. 2012		