
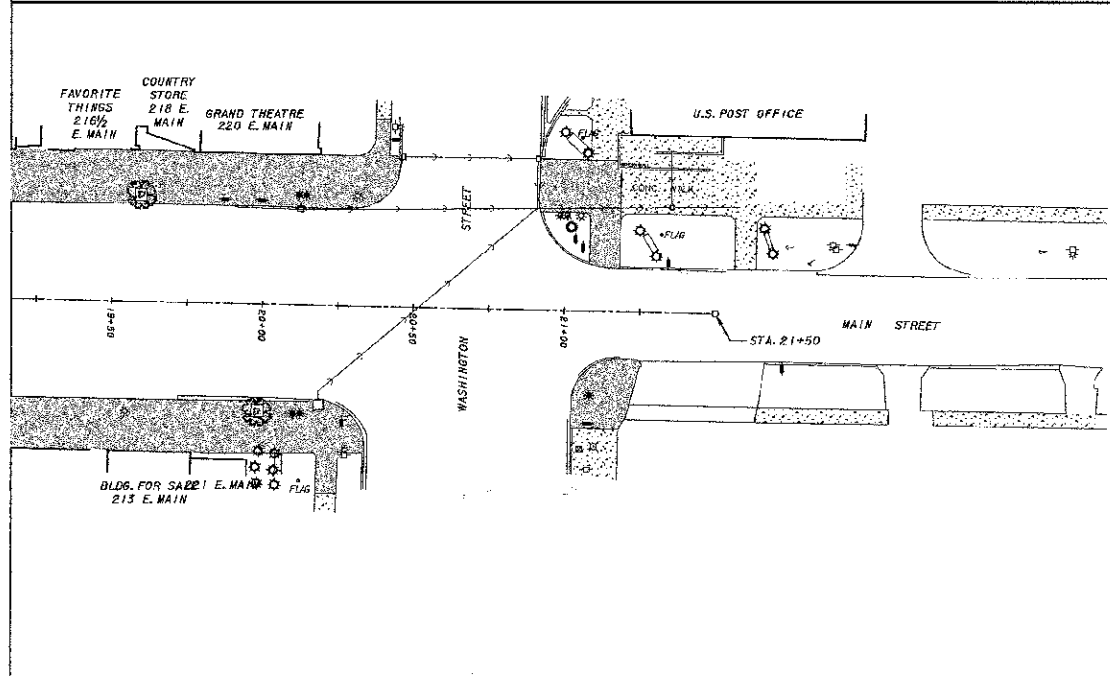
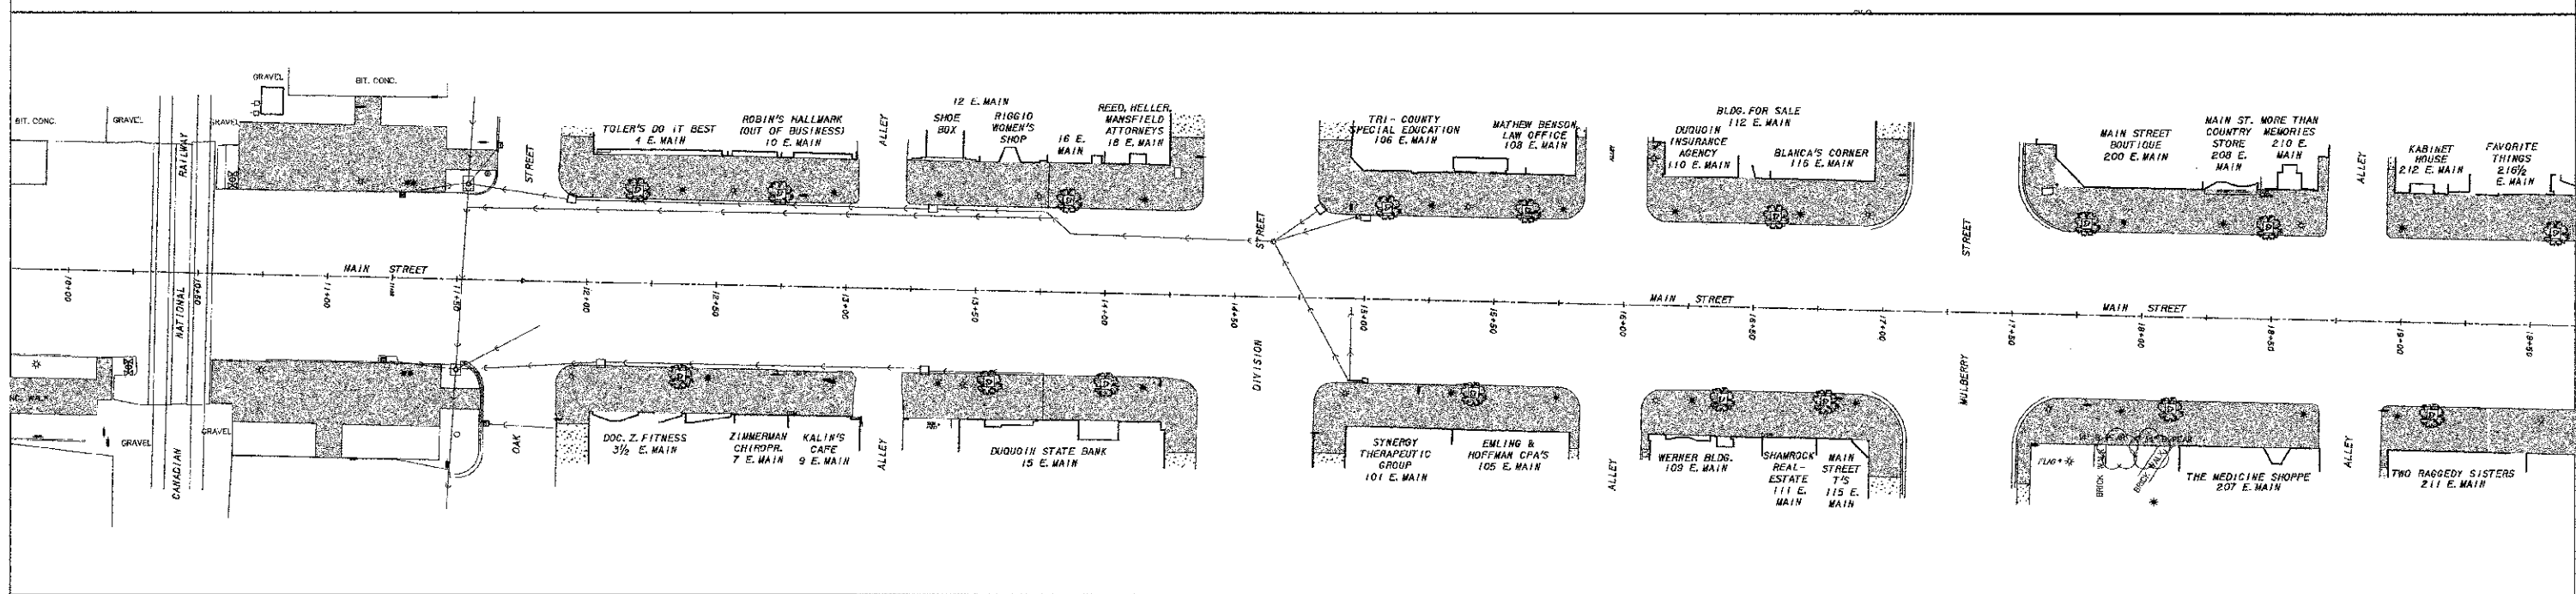


| F.A.U. ROUTE       | SECTION        | COUNTY                 | TOTAL SHEETS | SHEET NUMBER |
|--------------------|----------------|------------------------|--------------|--------------|
| 9521               | 10-00051-00-SW | PERRY                  | 33           | 33           |
| CITY OF DUQUOIN    |                | PROJECT NO. TE-0009105 |              |              |
| CONTRACT NO. 99499 |                | JOB NO. C-99-512-11    |              |              |

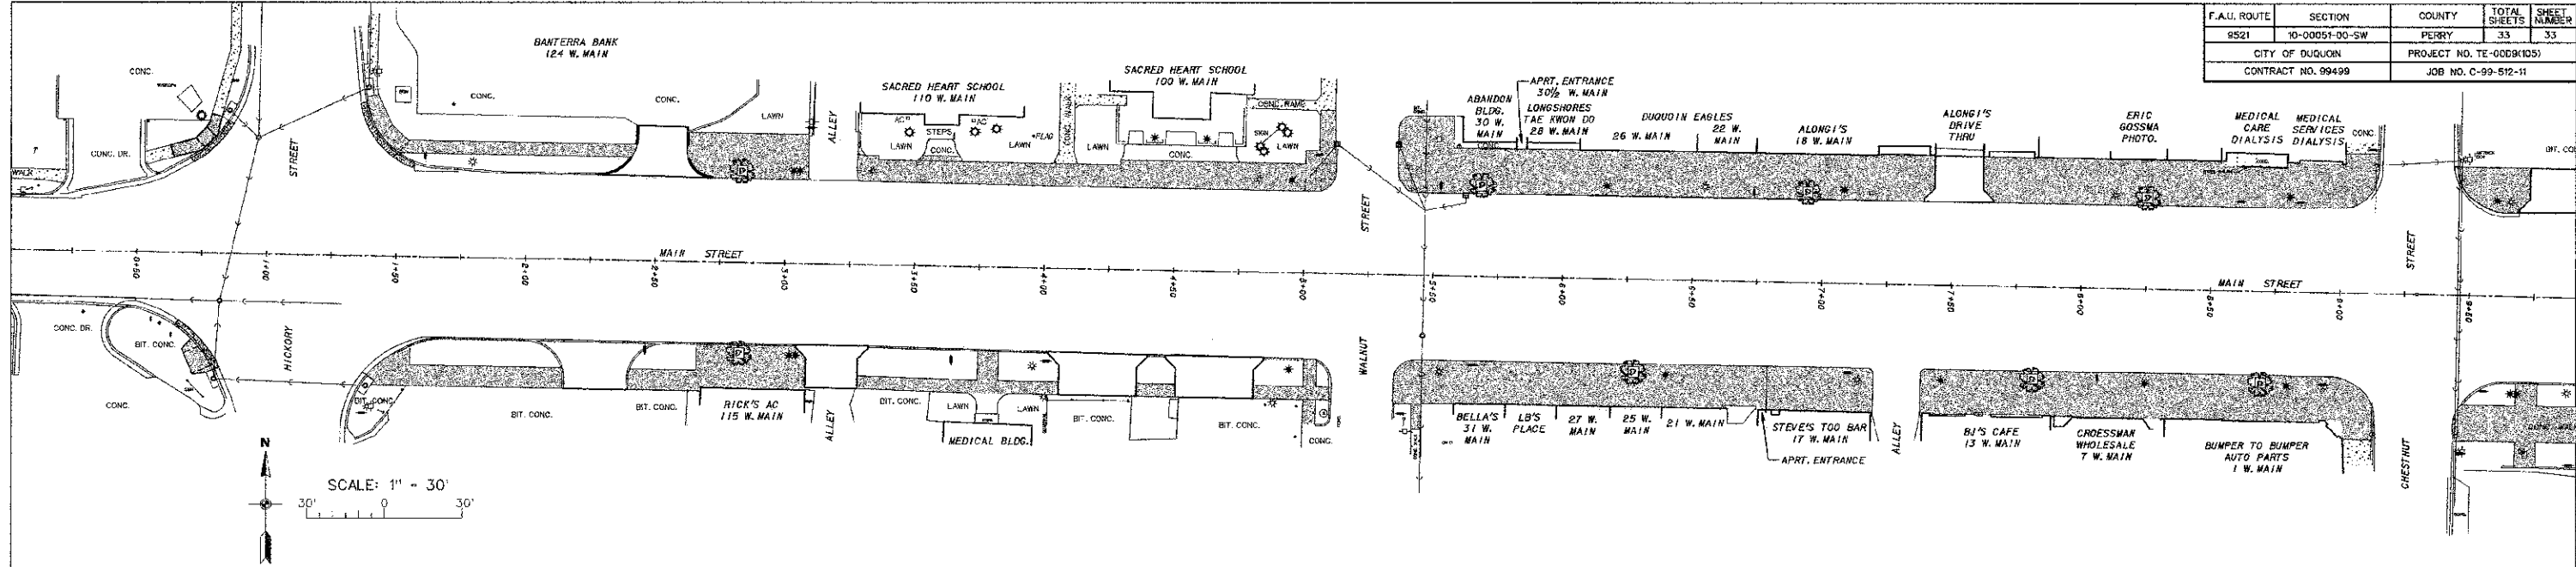


- LEGEND**
- - POWER POLE
  - ⊕ - POWER / TELEPHONE POLE
  - ⊗ - POWER / TELEPHONE POLE W/ LIGHT
  - ⋆ - STREET LIGHT POLE
  - \*\*\* - SINGLE / DOUBLE FIXTURE PEDESTRIAN LIGHT
  - ⊞ - ELECTRICAL JUNCTION BOX
  - ⊞ - ELECTRICAL OUTLET
  - ⊞ - ANCHOR
  - ⊞ - TRAFFIC CONTROL LIGHT
  - ⊞ - RAILROAD CROSSING GATE
  - ⊞ - SIGN
  - ⊞ - EXISTING TREE W/ SIZE & TYPE
  - ⊞ - PROPOSED TREE
  - ⊞ - EXISTING CONCRETE SIDEWALK
  - ⊞ - PROPOSED PCC SIDEWALK

**NOTES:**

1. ALL ITEMS SHALL BE CONSTRUCTED AS SHOWN ON ILLINOIS DEPARTMENT OF TRANSPORTATION HIGHWAY STANDARD 280001 AND AS DIRECTED BY THE ENGINEER. MAINTENANCE AND CLEANING OF THE EROSION CONTROL ITEMS SHALL BE INCLUDED IN THE RESPECTIVE EROSION CONTROL PAY ITEM.

2. SEE STORMWATER POLLUTION PREVENTION PLAN (SWPPP) BDE 2342 INCLUDED IN SPECIAL PROVISIONS.

- LEGEND**
- ⊞ - INLET AND PIPE PROTECTION - 10 EACH LOCATED AS REQUESTED BY ENGINEER.

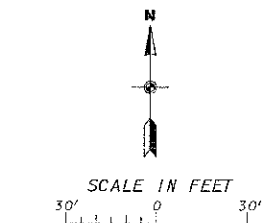

|                                      |
|--------------------------------------|
| CITY OF DUQUOIN                      |
| PERRY COUNTY, ILLINOIS               |
| MAIN STREET SIDEWALK REPLACEMENT     |
| STORMWATER POLLUTION PREVENTION PLAN |