


APR 27, 2007 7:43 AM BAK
 I:\AIRPORTS\CARM\801-07TAXI\AIRPORT\ SHEETS\R-14\ELE.DWG - STA. 16+50 TO STA. 38+50

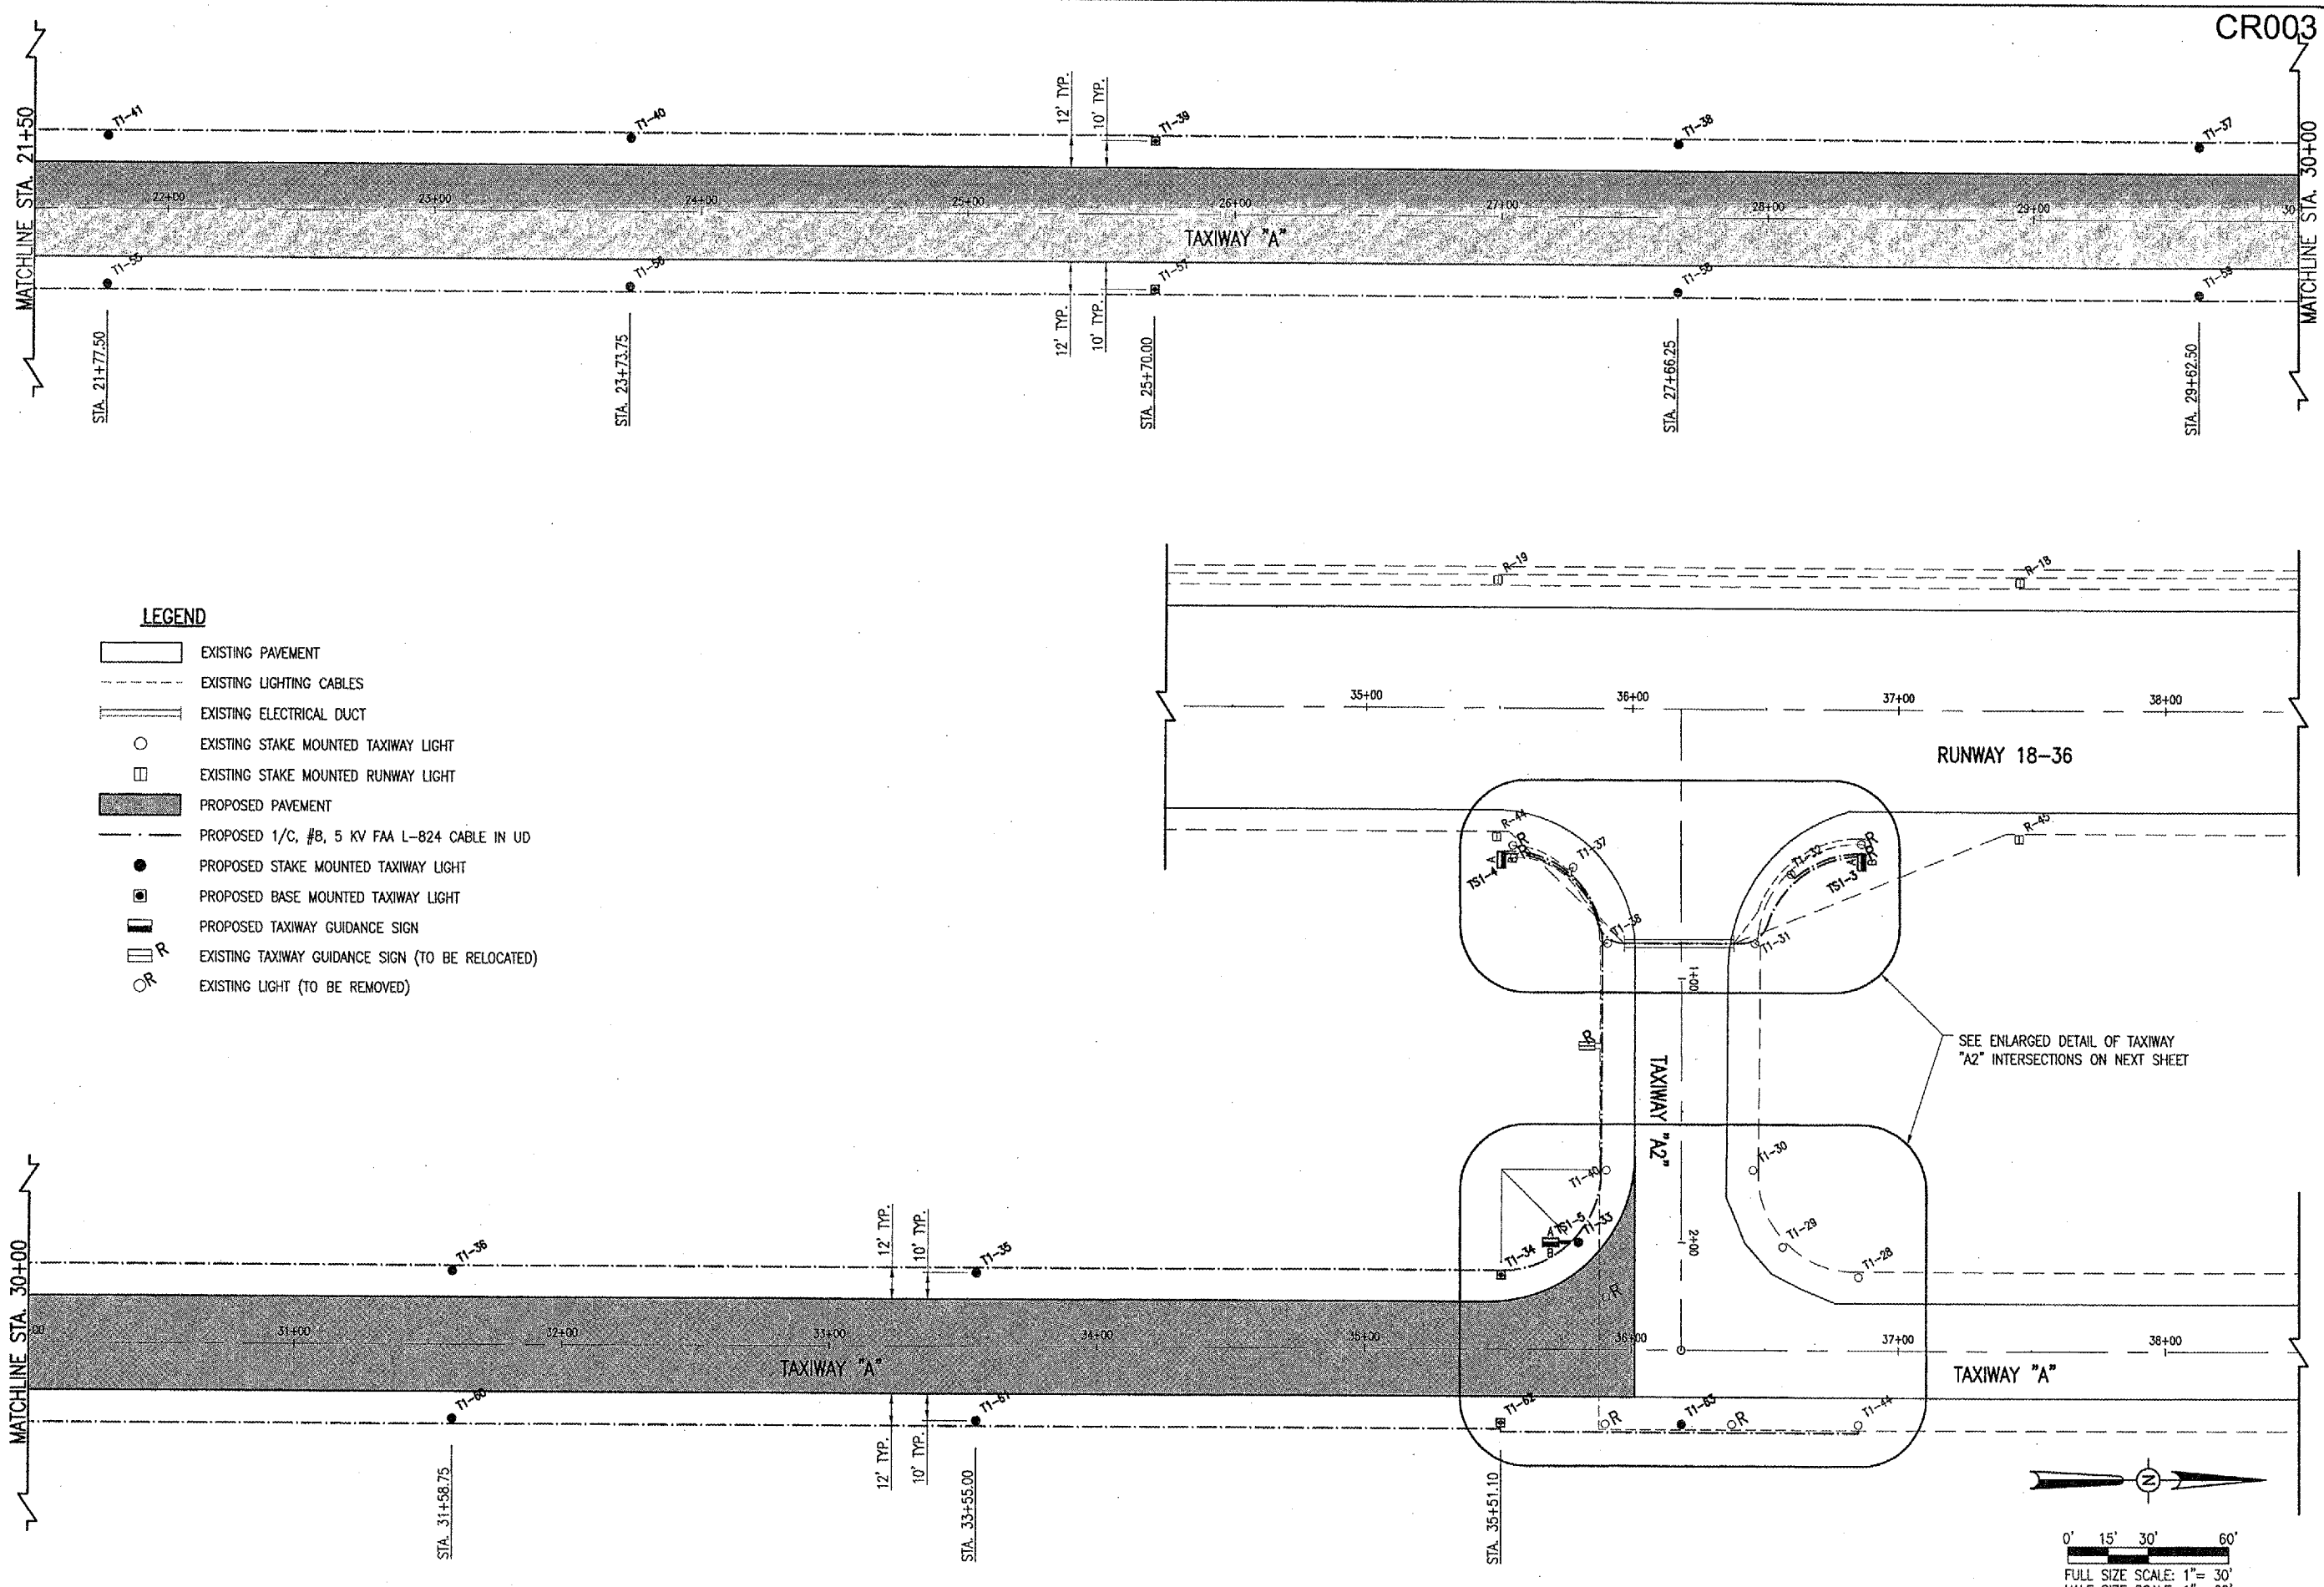

- LEGEND**
- EXISTING PAVEMENT
 - EXISTING LIGHTING CABLES
 - EXISTING ELECTRICAL DUCT
 - EXISTING STAKE MOUNTED TAXIWAY LIGHT
 - EXISTING STAKE MOUNTED RUNWAY LIGHT
 - PROPOSED PAVEMENT
 - PROPOSED 1/C, #8, 5 KV FAA L-824 CABLE IN UD
 - PROPOSED STAKE MOUNTED TAXIWAY LIGHT
 - PROPOSED BASE MOUNTED TAXIWAY LIGHT
 - PROPOSED TAXIWAY GUIDANCE SIGN
 - EXISTING TAXIWAY GUIDANCE SIGN (TO BE RELOCATED)
 - EXISTING LIGHT (TO BE REMOVED)

| DATE | REVISION | BY |
|------|----------|----|
| | | |
| | | |
| | | |
| | | |

**CARM MUNICIPAL AIRPORT
 CARM, ILLINOIS**

IL. PROJ.: CUL-3683 A.I.P. PROJ.: 3-17-01-09-B7

| | | |
|---------------------------------|----------------|--------------|
| HEI Project No. 801-07TAXI 0800 | FILED | SEP 11/15/06 |
| Drawn R-14/ELE.DWG | Scale 1" = 30' | CCC 11/15/06 |
| Date 11/15/06 | | CAH 03/27/07 |
| LAYOUT | SEP | 11/15/06 |
| DRAWN | CCC | 11/15/06 |
| REVIEWED | CAH | 03/27/07 |

HANSON
 Hanson Professional Services Inc.
 1525 South Sixth Street
 Springfield, Illinois 62705-2886
 Offices Nationwide

**EXTEND PARTIAL
 PARALLEL TAXIWAY**

PROPOSED
 ELECTRICAL PLAN
 STA. 21+50 TO STA. 38+50