



FILE PATH = p:\388035\pmt\escomonline\local\p\AECOM\0\Documents\01\_Americas\Transportation\6269938\_Circle\Phase\_1\000\_CAD\016\_Electrical\Sheets\60W28\_Contract\DI60W28-sht-Light-08

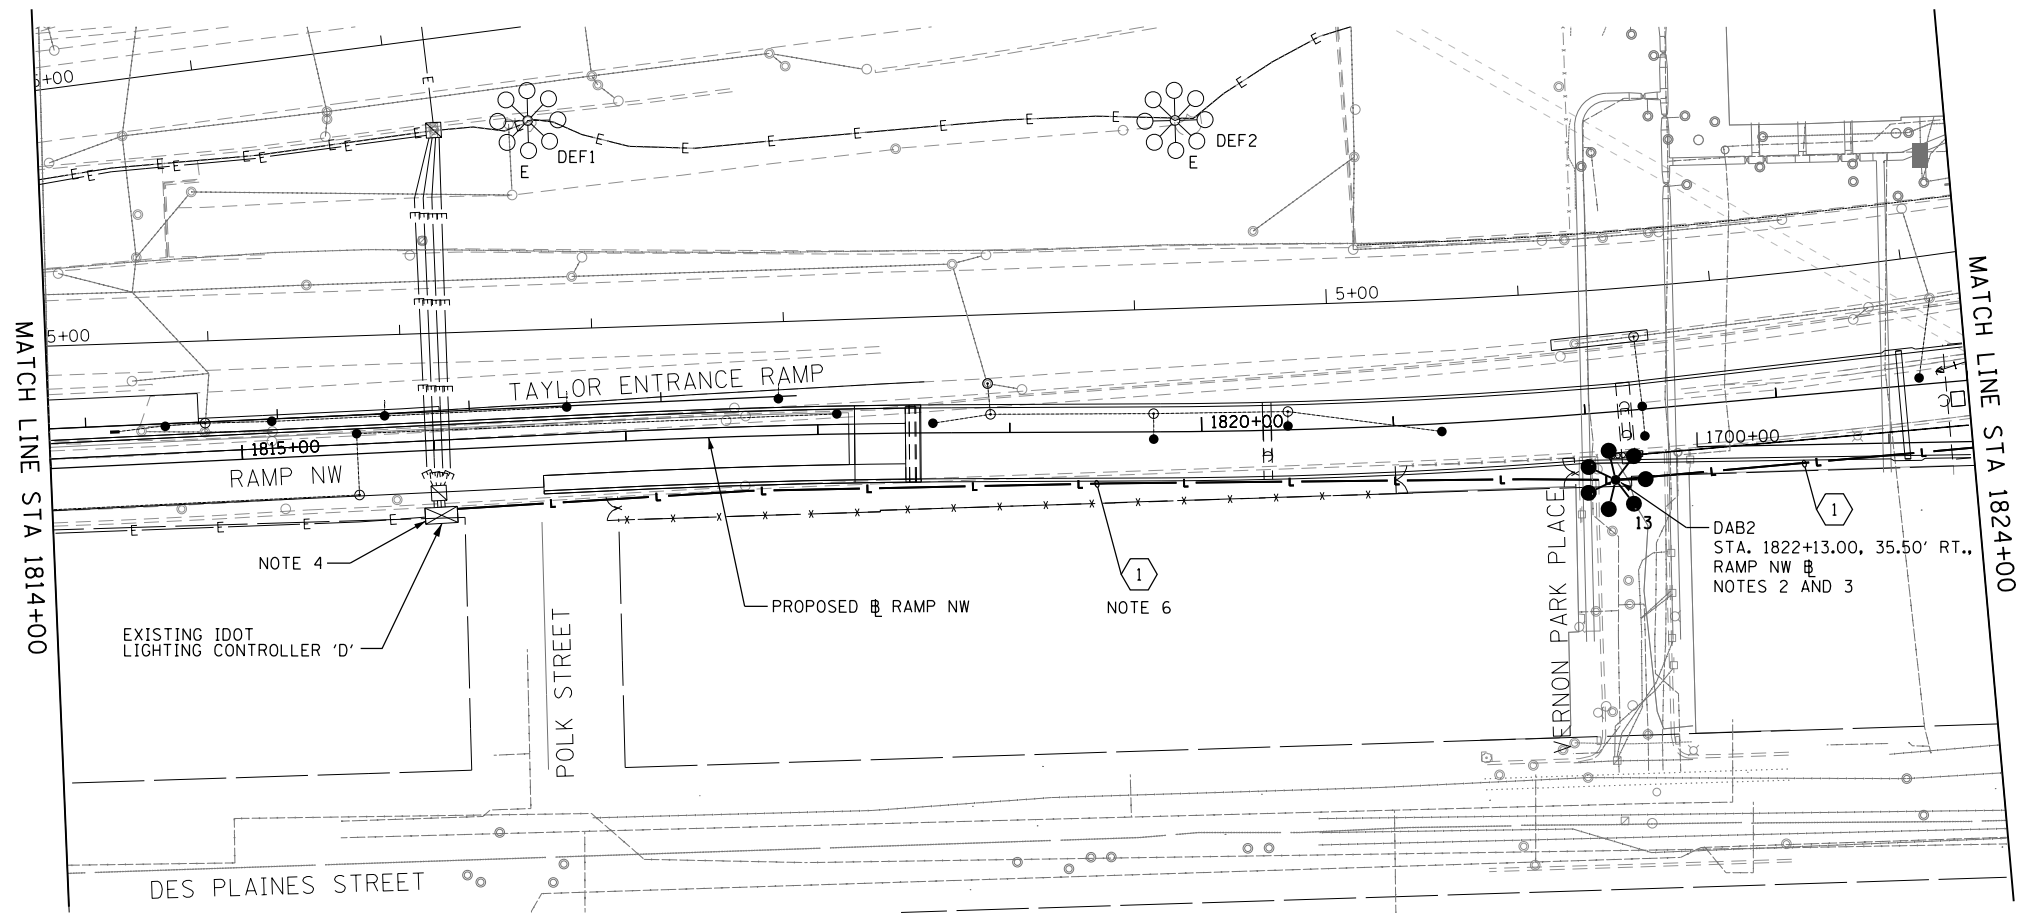

1 CKTS. DA & DB: 3-1/C NO. 2 & 1-1/C NO. 4 GROUND XLP TYPE USE CABLES IN 1 1/2" POLYETHYLENE UNIT DUCT

**NOTES:**

- SEE DRAWING E-01 FOR IDOT ELECTRICAL SYMBOLS.
- SEE DRAWING E-16 FOR LIGHT TOWER FOUNDATION SCHEDULE. COORDINATE TOWER INSTALLATION WITH CIVIL WORK AT VERNON PARK PLACE. SEE THE CIVIL PLANS FOR ADDITIONAL DETAILS.
- SEE DRAWING E-17 FOR LIGHT TOWER CONDUIT AND GROUNDING INSTALLATION DETAILS. SEE THE CIVIL PLANS FOR SIDEWALK AND CURB WORK AROUND THE FOUNDATION. NO SERVICE PAD WILL BE INSTALLED FOR THIS LIGHT TOWER.
- PROVIDE A NEW LIGHTING FEED TO LIGHT TOWER DAB2 FROM EXISTING IDOT LIGHTING CONTROLLER 'D' AS SHOWN.
- SEE DRAWING E-13 FOR IDOT LIGHTING CONTROLLER 'D' WIRING DIAGRAM.
- INSTALL THE UNIT DUCT IN EXISTING IDOT ROW APPROXIMATELY 2.5 FEET BEHIND THE EXISTING RETAINING WALL NO. 1.

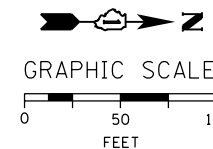

E-08



DI60W28-sht-Light-08	DESIGNED - WDS	REVISED -
USER NAME = myersc	DRAWN - CAM	REVISED -
PLOT SCALE = 50.0000' / in.	CHECKED - WDS	REVISED -
PLOT DATE = 4/24/2014	DATE - 04/28/14	REVISED -

**STATE OF ILLINOIS  
DEPARTMENT OF TRANSPORTATION**

**RAMP NORTHWEST  
PROPOSED LIGHTING PLAN**

SCALE: 1"=50' SHEET 8 OF 17 SHEETS STA. 1814+00 TO STA. 1824+00

F.A.I. RTE.	SECTION	COUNTY	TOTAL SHEETS	SHEET NO.
90/94/290	2013-010R	COOK	747	298
CONTRACT NO. 60W28				
ILLINOIS FED. AID PROJECT				