


INSIDE ELEVATION OF LEFT PARAPET - UNIT IV

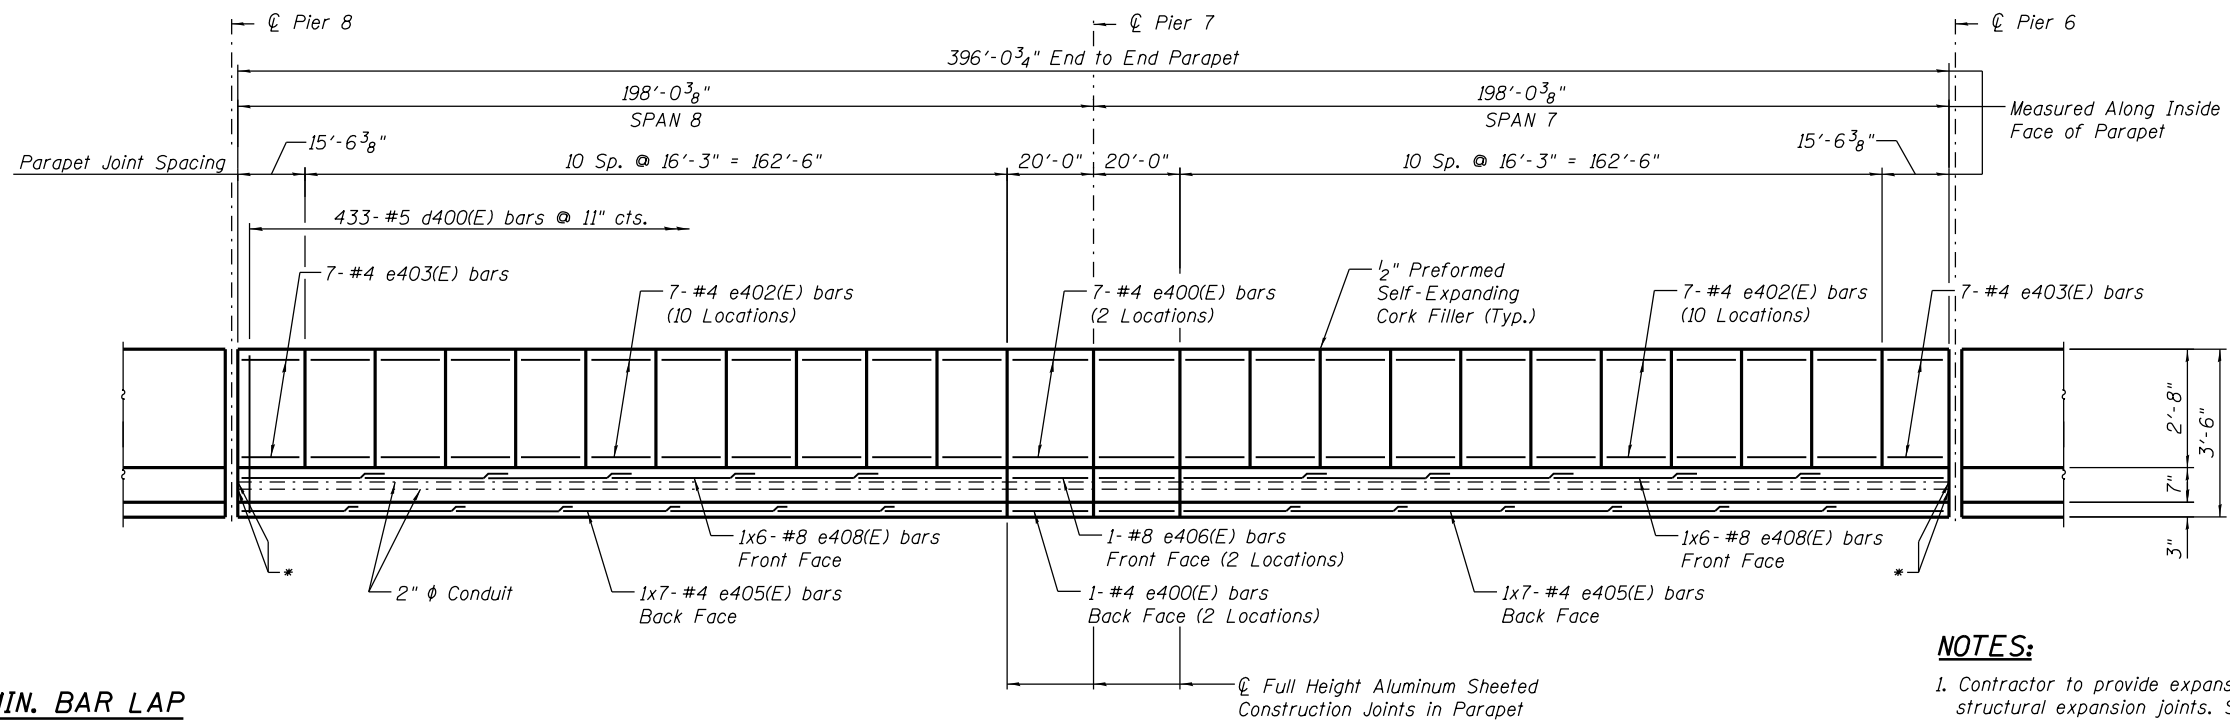

INSIDE ELEVATION OF RIGHT PARAPET - UNIT IV

MIN. BAR LAP
(Parapet)
#4 bar = 2'-0"
#8 bar = 5'-2"

NOTES:

- Contractor to provide expansion/deflection conduit fittings at all structural expansion joints. See electrical plans for expansion/deflection fitting installation details.
- Bars indicated Locations: 1x4- #8 etc., indicates one line of bars with 4 lengths per line.
- For parapet details see Sheet S-58.
- For electrical junction box locations and conduit stub out details see electrical plans.

0161705-60W28-5048-Parapet.dgn



USER NAME = floresg	DESIGNED - JRE	REVISED
	CHECKED - KMS	REVISED
PLOT SCALE = N.T.S.	DRAWN - TNP	REVISED
PLOT DATE = 5/7/2014	CHECKED - EJO	REVISED

STATE OF ILLINOIS
DEPARTMENT OF TRANSPORTATION

PARAPET ELEVATIONS - UNIT IV
STRUCTURE NO. 016-1705

SHEET NO. S-48 OF S-165 SHEETS

F.A.I. RTE.	SECTION	COUNTY	TOTAL SHEETS	SHEET NO.
90/94/290	2013-010R	COOK	747	364
CONTRACT NO.			60W28	
ILLINOIS FED. AID PROJECT				