


F.A. RTE.	SECTION	COUNTY	TOTAL SHEETS	SHEET NO.
9127	08-00061-02-LS	MADISON	45	28
STA.		TO STA.		
FED. ROAD DIST. NO.		ILLINOIS	FED. AID PROJECT	
ELECTRICAL PLAN				

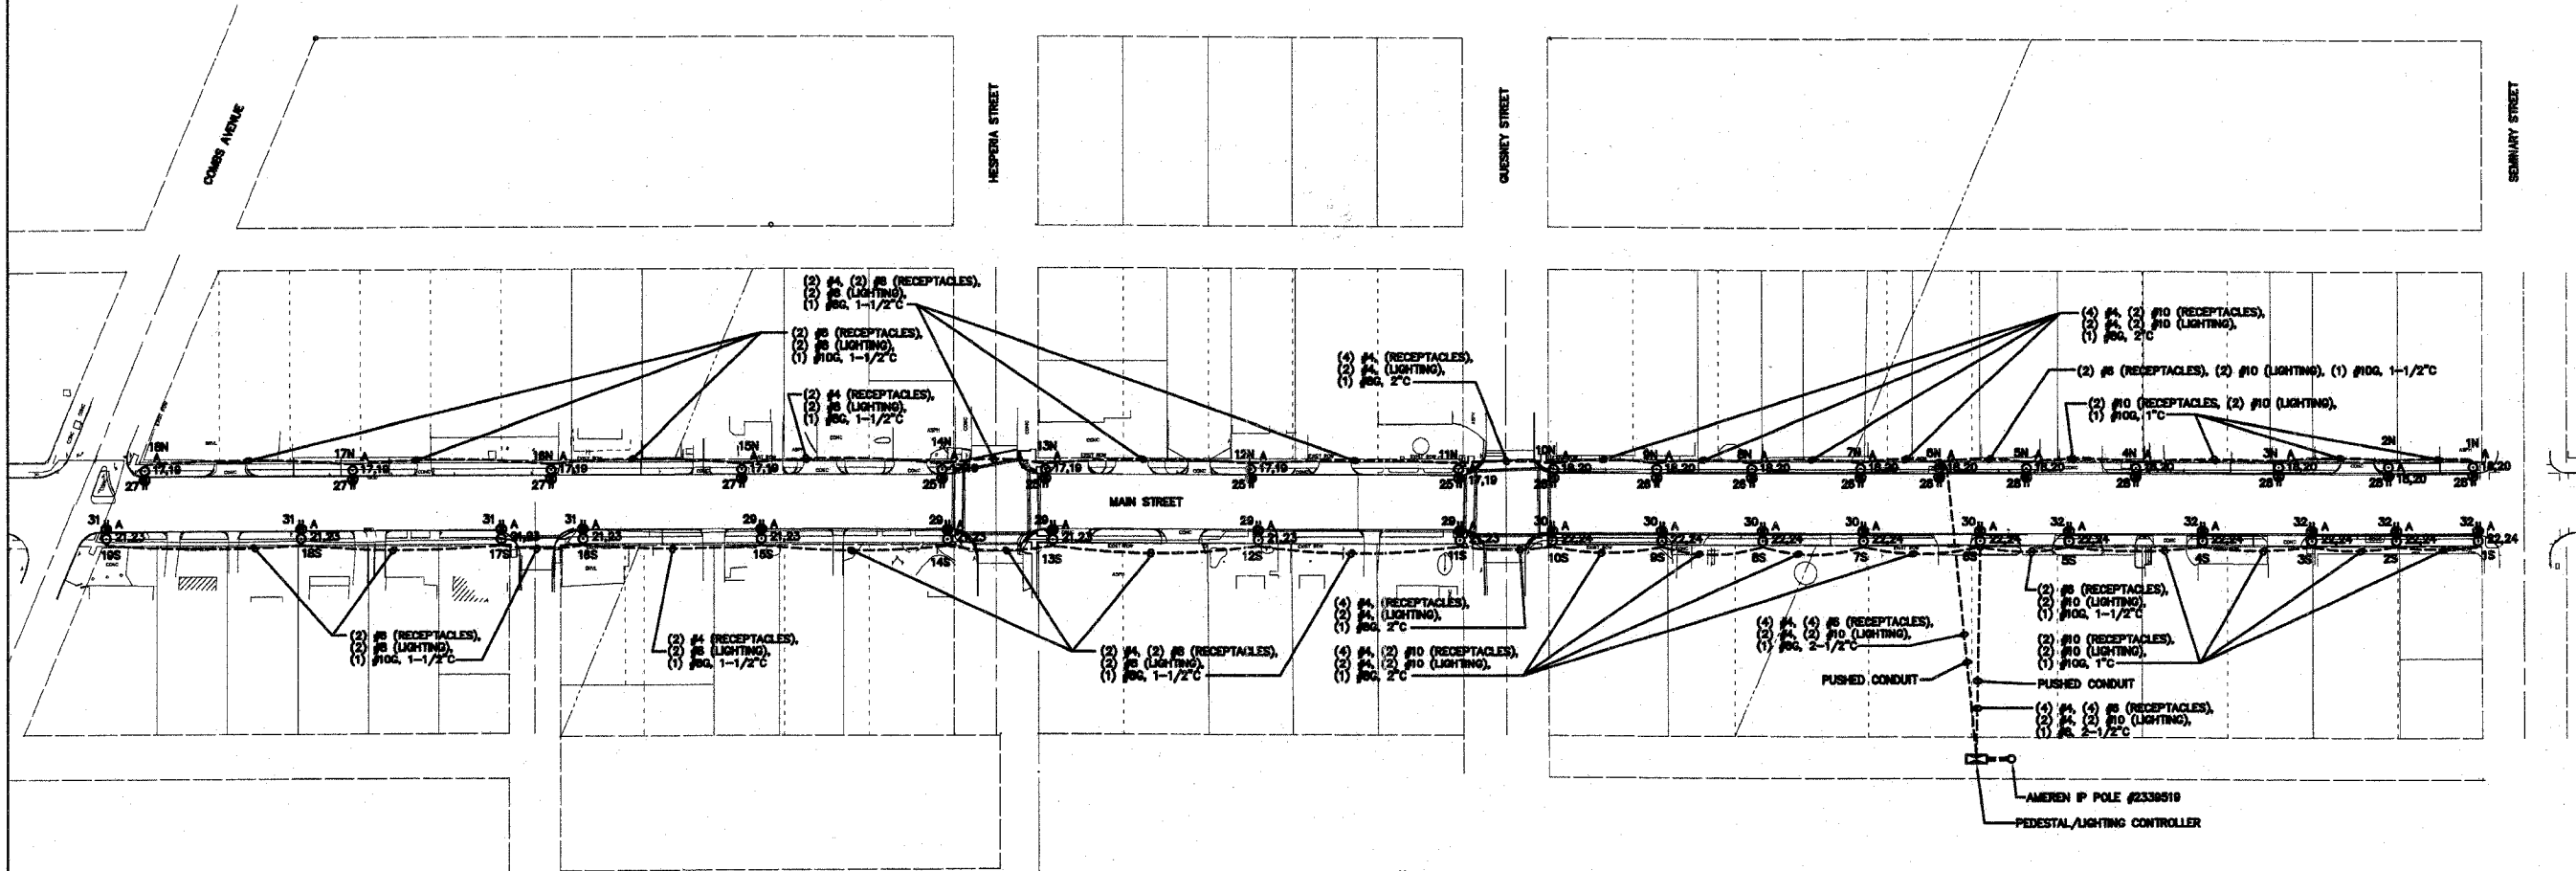


ELECTRICAL SITE PLAN
1" = 60'-0"

SYMBOL LEGEND

- UNDERGROUND CONDUIT(S)
- SITE LIGHT FIXTURE (SEE DETAIL #5 ON SHEET E-3)
- ⊕ GFI DUPLEX RECEPTACLE IN POLE WITH WEATHERPROOF "IN-USE" COVER
- HANDHOLE SPECIAL, 12"x12" (SEE DETAIL #4 ON SHEET E-3)
- ⊞ ELECTRICAL PEDESTAL/LIGHTING CONTROLLER

0 60' 120'
GRAPHIC SCALE
1" = 60'-0"

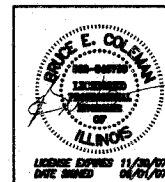

BRiC
PARTNERSHIP, LLC
CONSULTING ENGINEERS

100 EAST WASHINGTON, SUITE 220
BELLEVILLE, IL 62220
TEL 618.277.5200
FAX 618.277.5227

BRIC #624-23



**COLLINSVILLE
STREETSCAPE
PLAN VIEW**

DRAWN BY: GYK
CHKD BY: LHH
DATE: 07/10/07

JOB NO.: C-98-304-07
E-1
SHEET 1 OF 3 SHEETS

Revised