


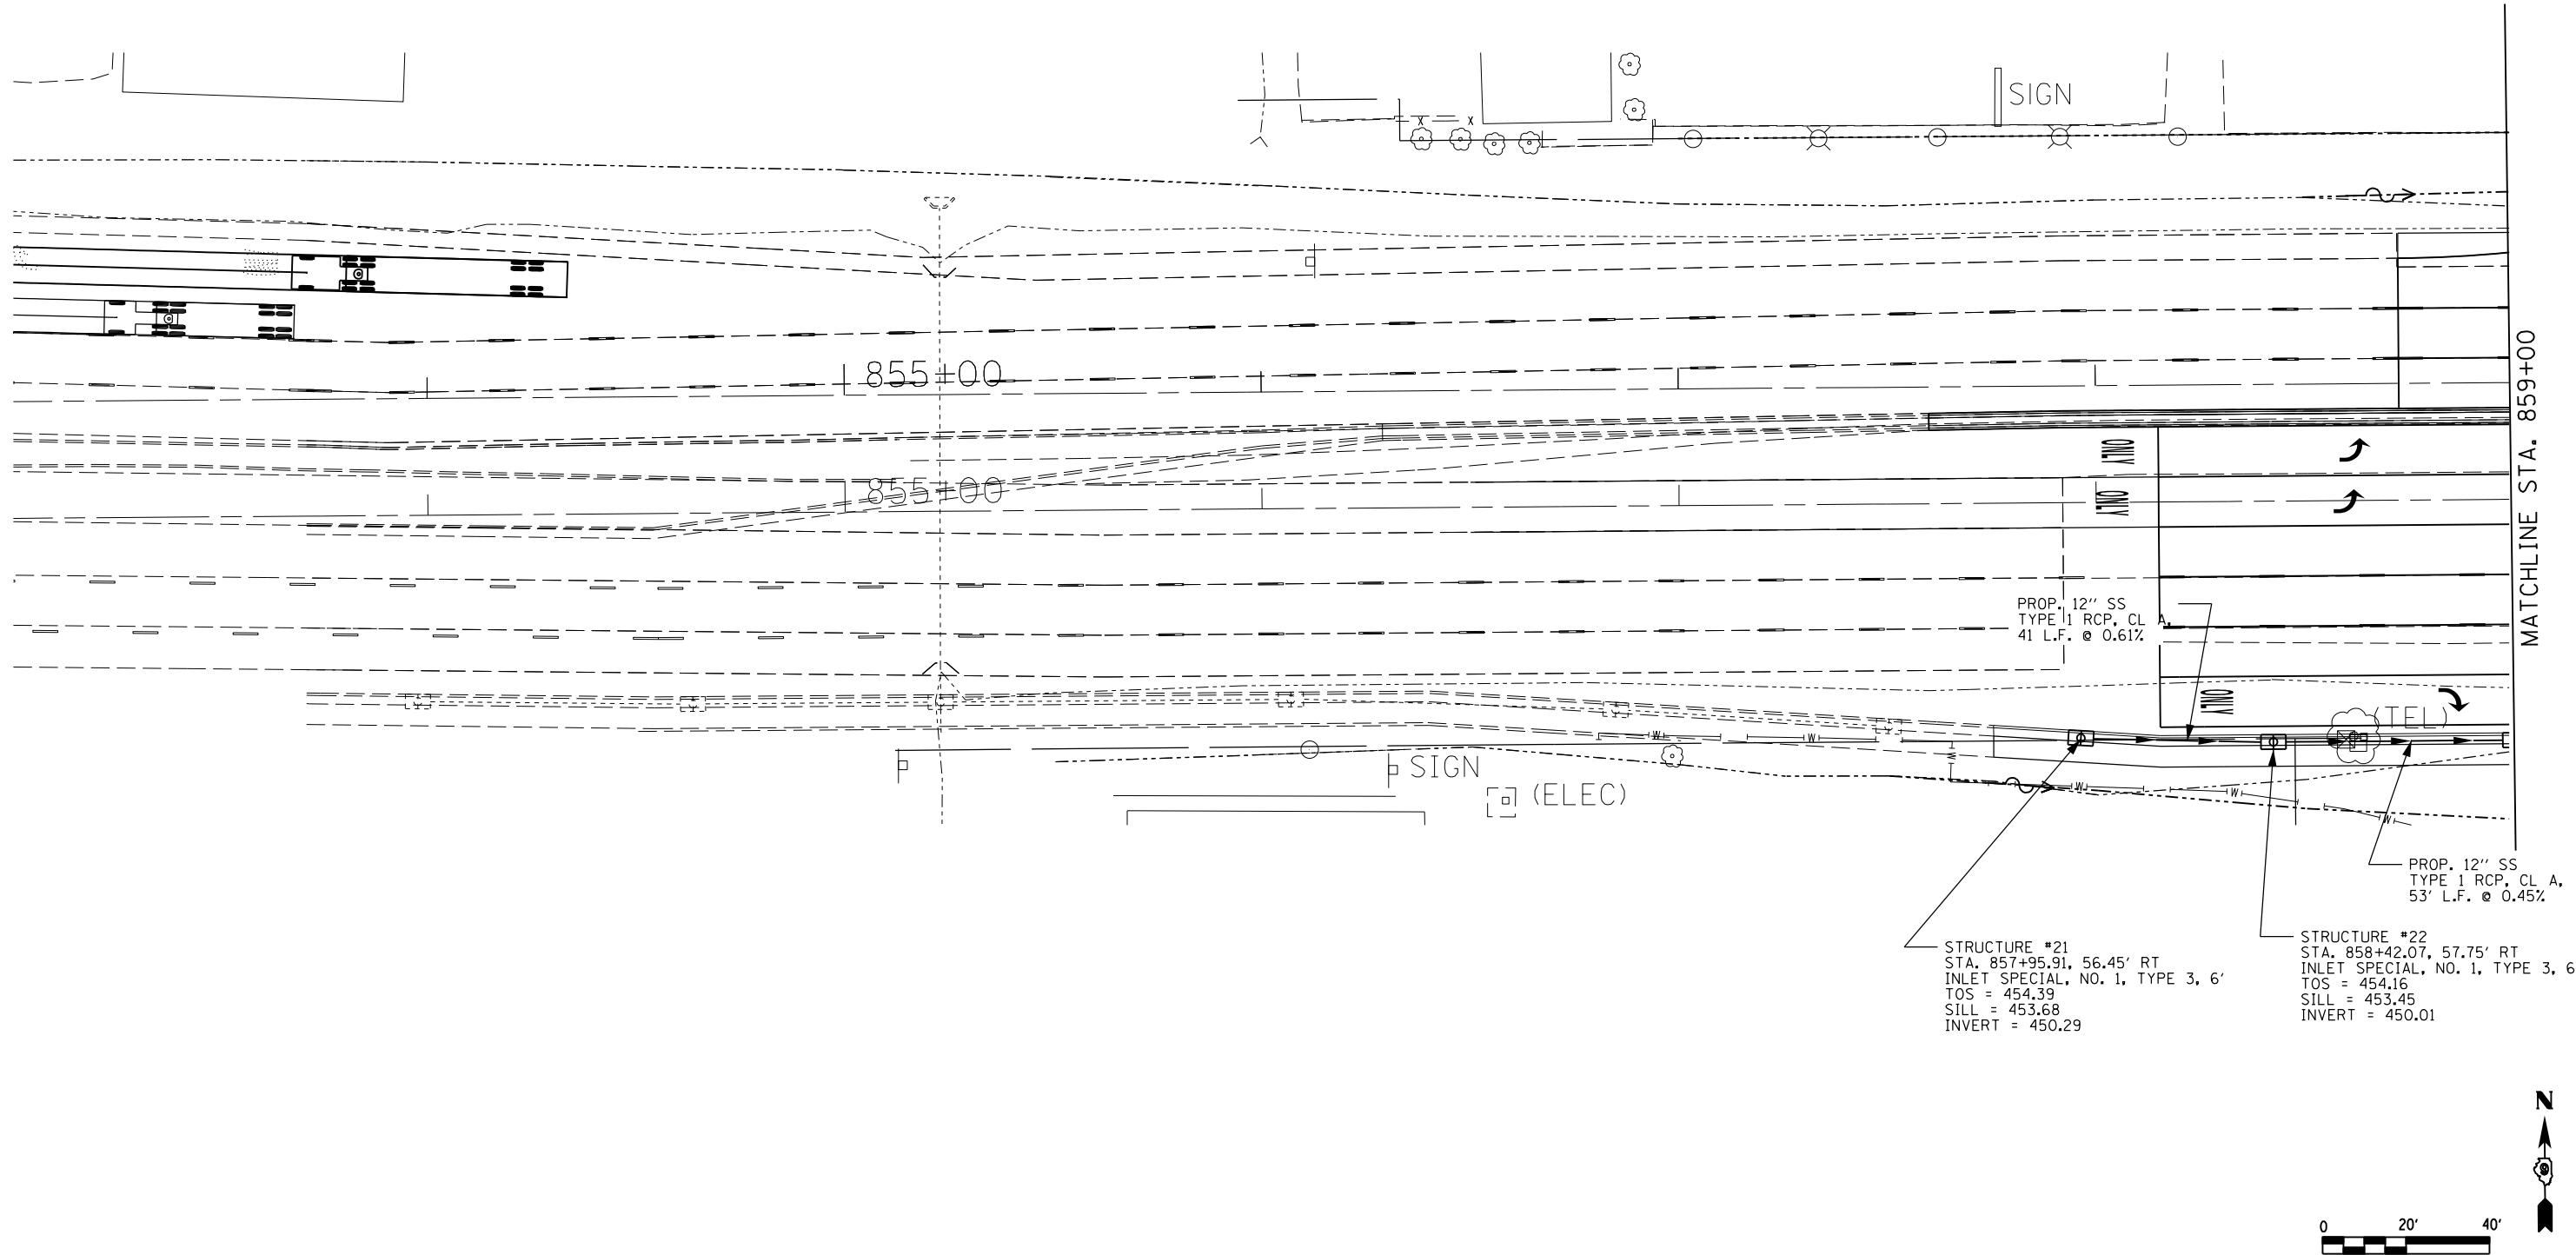

FILE NAME = c:\pwork\pwork\kellykd\0184451\78203-shd-drain.dgn	USER NAME = \$USER\$		DESIGNED -	REVISED -	STATE OF ILLINOIS DEPARTMENT OF TRANSPORTATION	DRAINAGE PLAN SHEETS IL 13				F.A.P. RTE.	SECTION	COUNTY	TOTAL SHEETS	SHEET NO.
	DRAWN -		DESIGNED -	REVISED -						331	(IX-1)R-5,RS-3,N-5,TS-4	WILLIAMSON	288	95
	PLOT SCALE = 40.0000' / in.		CHECKED -	REVISED -		SCALE: SHEET NO. OF SHEETS STA. TO STA.				CONTRACT NO. 78203				
	PLOT DATE = 5/11/2012		DATE -	REVISED -						ILLINOIS FED. AID PROJECT				