


JUN 27, 2005 1:10 PM CCC
 I:\AIRPORTS\DECATUR\802-04TXD\AIRPORT_SHEETS\CONTRACT-1\R-142ELE.DWG - 380 TO 388

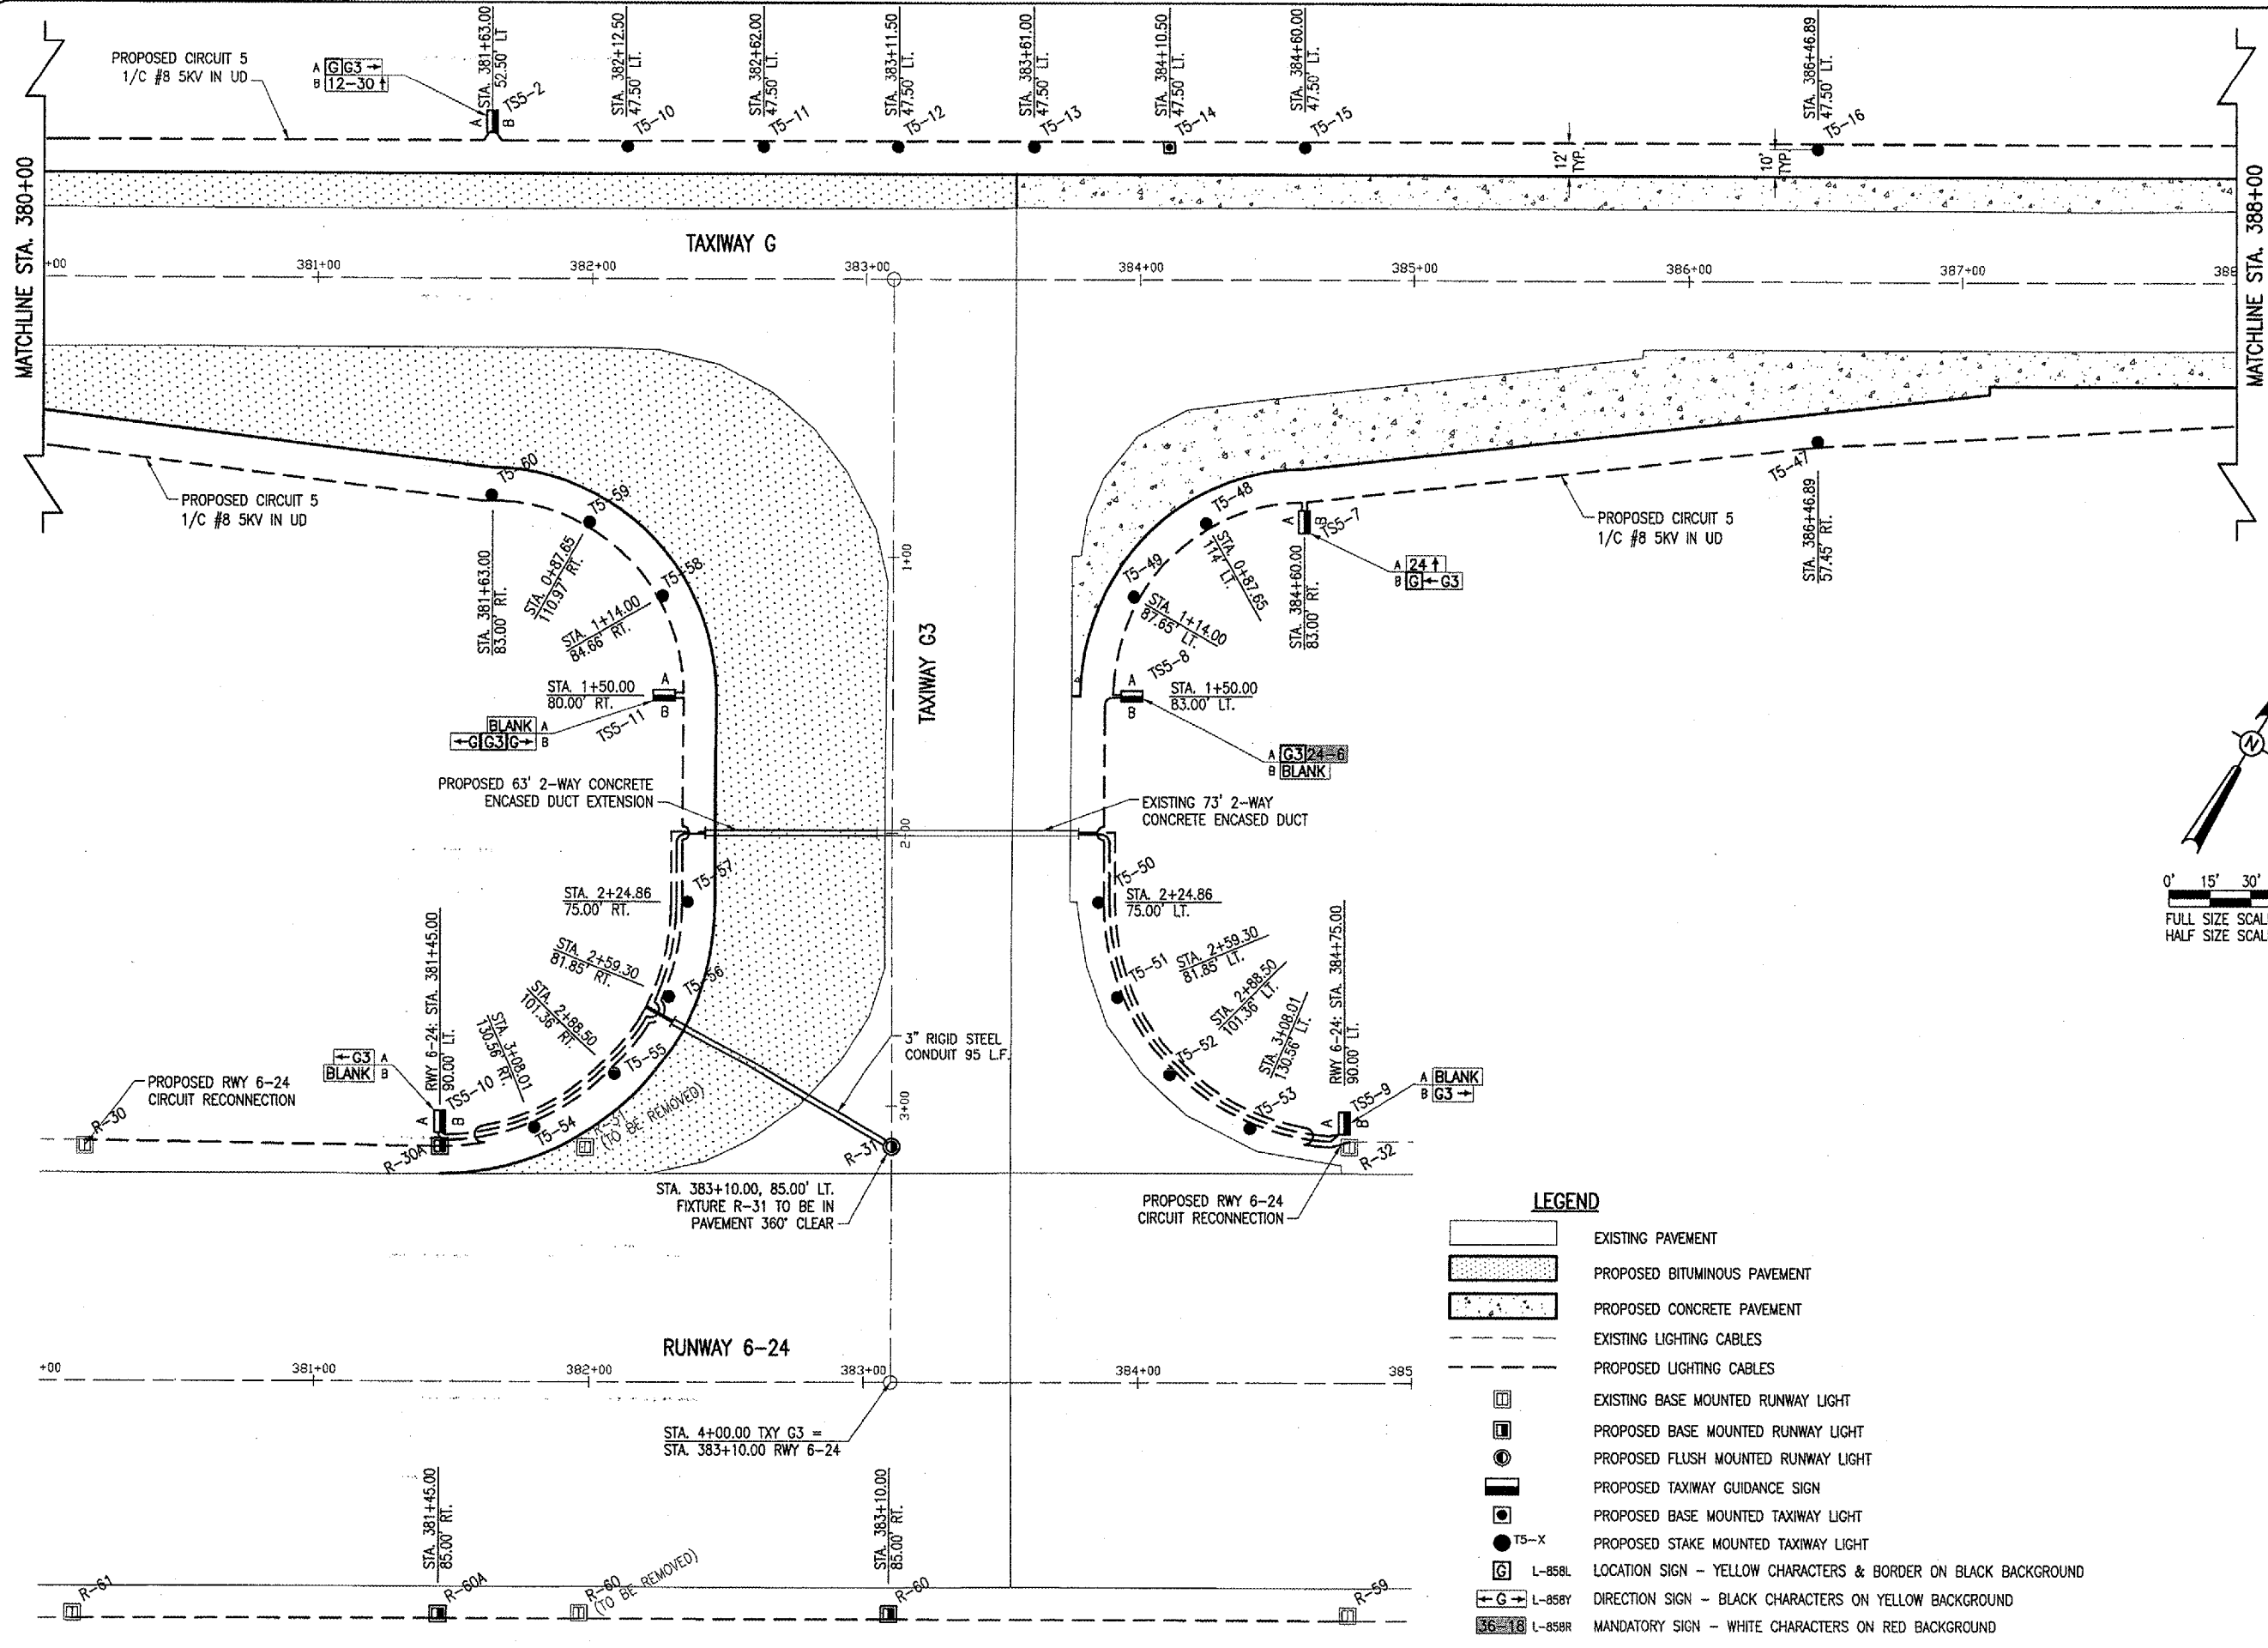

LEGEND

[Pattern]	EXISTING PAVEMENT
[Pattern]	PROPOSED BITUMINOUS PAVEMENT
[Pattern]	PROPOSED CONCRETE PAVEMENT
[Line]	EXISTING LIGHTING CABLES
[Line]	PROPOSED LIGHTING CABLES
[Symbol]	EXISTING BASE MOUNTED RUNWAY LIGHT
[Symbol]	PROPOSED BASE MOUNTED RUNWAY LIGHT
[Symbol]	PROPOSED FLUSH MOUNTED RUNWAY LIGHT
[Symbol]	PROPOSED TAXIWAY GUIDANCE SIGN
[Symbol]	PROPOSED BASE MOUNTED TAXIWAY LIGHT
[Symbol]	PROPOSED STAKE MOUNTED TAXIWAY LIGHT
[Symbol]	L-85BL LOCATION SIGN - YELLOW CHARACTERS & BORDER ON BLACK BACKGROUND
[Symbol]	L-85BY DIRECTION SIGN - BLACK CHARACTERS ON YELLOW BACKGROUND
[Symbol]	L-85BR MANDATORY SIGN - WHITE CHARACTERS ON RED BACKGROUND

DE165

REVISION	DATE	BY

DATE	REVISION	BY

DECATUR AIRPORT
DECATUR, ILLINOIS
 ILL. PROJ.: DEC-3414
 A.I.P. PROJ.: 3-17-0033-28

I.E.I. Project No. 802-04TXD File No. R-142ELE.DWG Scale 1"=30' Date 03/17/05	LAYOUT CC 03/17/05 DRAWN CCC 03/17/05 REVIEWED WJM 06/07/05
--	---

HANSON
 Engineers, Architects, Scientists
 1525 South Sixth Street
 Springfield, Illinois 62703-2686
 Offices Nationwide

**TAXIWAY G WIDENING
 PHASE II**
**PROPOSED
 ELECTRICAL PLAN**
 STA. 380+00 TO STA. 388+00