



MATCH LINE STA 71+10

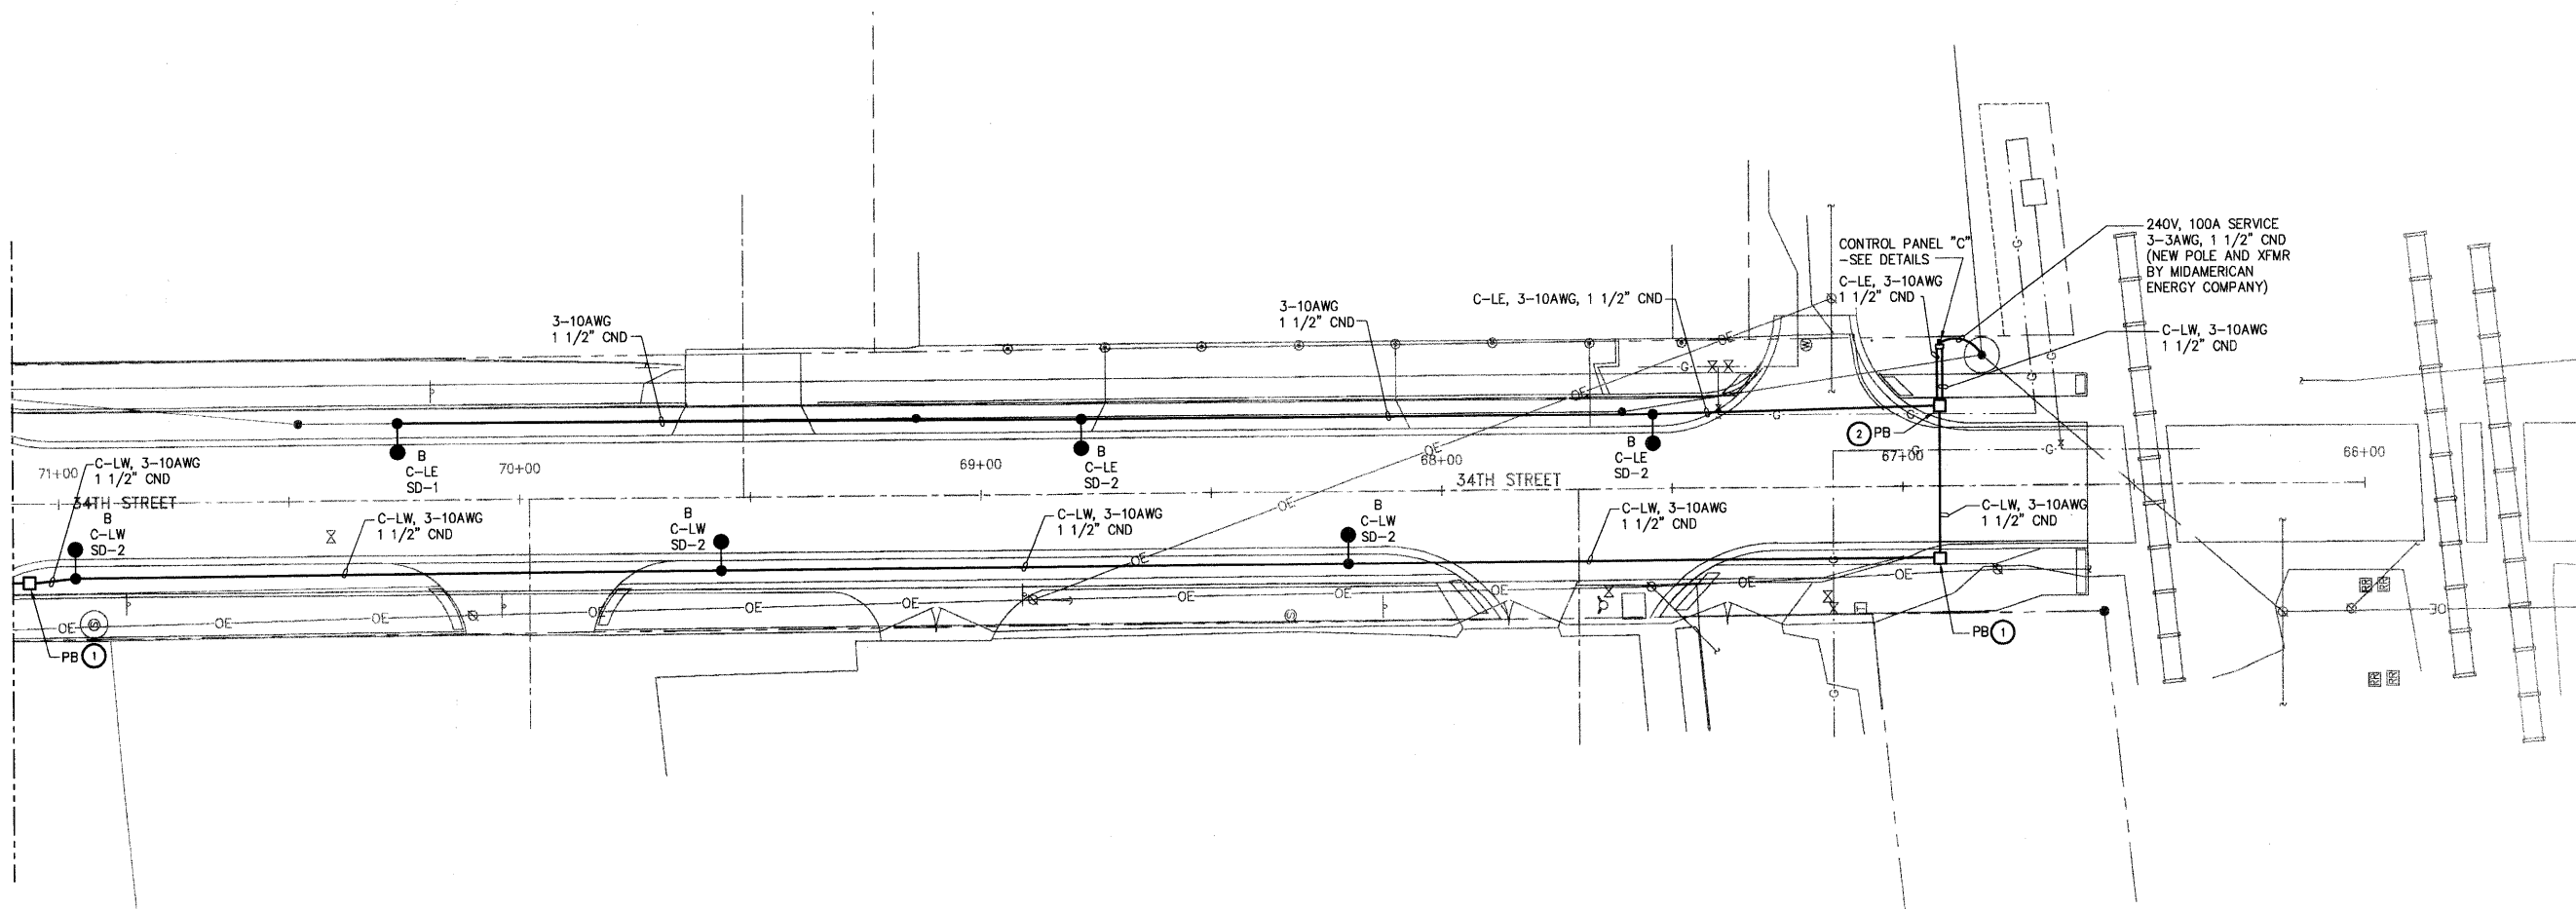

DECORATIVE LIGHTING LEGEND	
GENERAL SITE	
PLAN MARK	DESCRIPTION
●	DECORATIVE STREET LIGHT AND POLE
A, B	LIGHT DISTRIBUTION TYPE A OR B
A-LW	CONTROL PANEL A - LIGHTING CIRCUIT WEST
A-LE	CONTROL PANEL A - LIGHTING CIRCUIT EAST
B-LW	CONTROL PANEL B - LIGHTING CIRCUIT WEST
B-LE	CONTROL PANEL B - LIGHTING CIRCUIT EAST
C-LW	CONTROL PANEL C - LIGHTING CIRCUIT WEST
C-LE	CONTROL PANEL C - LIGHTING CIRCUIT EAST
SD-1	SPLICE DETAIL 1
SD-2	SPLICE DETAIL 2
SD-1	SPLICE DETAIL - SEE SPLICE DETAILS
CND	CONDUIT
PB ①	PULL BOX - TYPE 1
PB ②	PULL BOX - TYPE 2
3-10AWG	NUMBER OF WIRES - WIRE SIZE AMERICAN WIRE GAUGE
⊙	BOLLARDS

**SHIVE HATTERY**  
 Cedar Rapids, IA \ Iowa City, IA \ Des Moines, IA  
 Moline, IL \ Bloomington, IL \ Chicago, IL  
 SHIVE-HATTERY, INC. 1701 RIVER DRIVE, SUITE 200 MOLINE, IL 61265  
 PHONE (309) 764-7650 FAX (309) 764-8616  
 http://www.shive-hattery.com  
 ILLINOIS FIRM NUMBER: 184-000214

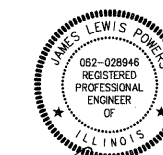

Signature: *James Pomes*  
 Date: 7/28/10  
 Exp. Date: 11-30-11

FILE NAME =	USER NAME = \$USER\$	DESIGNED - JLP	REVISED -
\$FILEL\$		DRAWN - DDL	REVISED -
	PLOT SCALE = \$SCALE\$	CHECKED - 07-06-10	REVISED -
	PLOT DATE = \$DATE\$	DATE - 07-06-10	REVISED -

STATE OF ILLINOIS  
 DEPARTMENT OF TRANSPORTATION

34TH STREET DECORATIVE LIGHTING PLAN

SCALE: 1" = 20' SHEET NO. 25 OF 30 SHEETS STA. 66+60 TO STA. 71+10

F.A.U. RTE.	SECTION	COUNTY	TOTAL SHEETS	SHEET NO.
5756	06-00234-00-LS	ROCK ISLAND	30	25
CONTRACT NO. 85517				
FED. ROAD DIST. NO. 2 ILLINOIS FED. AID PROJECT				