


ROUTE NO.	SECTION	CITY	TOTAL SHEETS	SHEET NO.
	05-0001-00-RP	OREANA	46	9
FED. ROAD DIST. NO.	ILLINOIS	PROJECT	HPP-0913 (001)	
<b>CONTRACT NUMBER 95537</b>				

DESIGNED	SCALE	DATE	JOB NO.
MHP	1" = 20'	May 2006	06-040A
DRAWN	DATE	FIELD BOOK	JOB NO.
Les Jenkine	May 2006	06-040A	06-040A
REVISIONS	NO.	BY	DATE
	1	MHP	1-30-07

**BAYBRIDGE & ASSOCIATES, INC.**  
 Consulting Engineers  
 1670 SOUTH TAYLORVILLE ROAD  
 DECATUR ILLINOIS  
 License 184-001255

**VILLAGE OF OREANA, ILLINOIS**  
 SAFE-TA-LU PROJECT  
**PLAN AND PROFILE**  
 CLAY STREET  
 STATION 605+25.00 TO 608+26.47

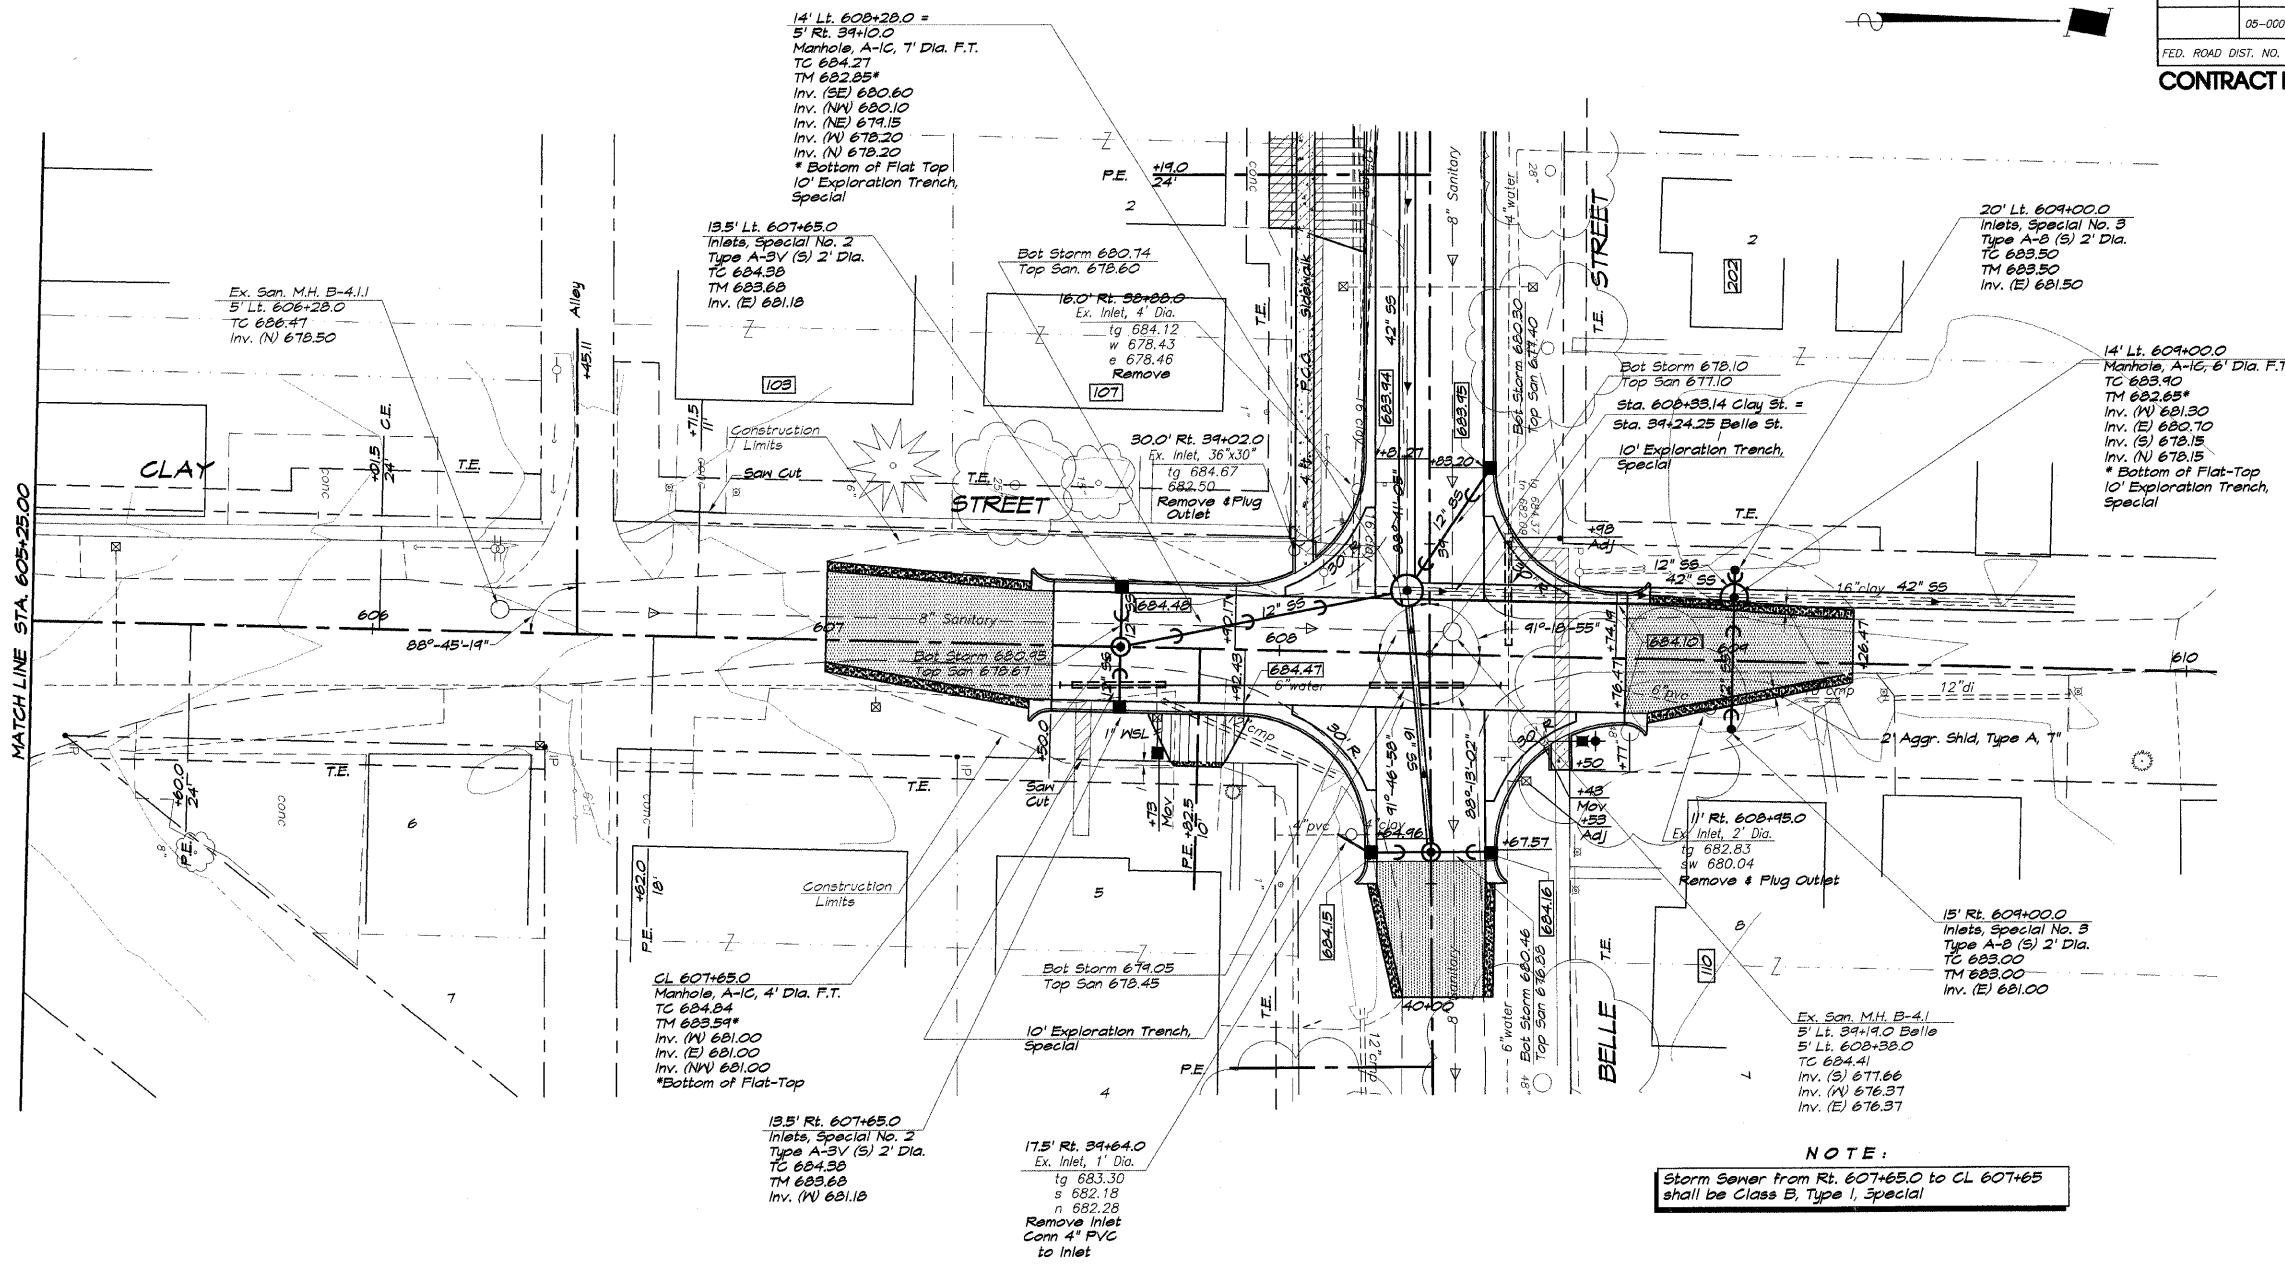

**NOTE:**  
 Storm Sewer from Rt. 607+65.0 to CL 607+65 shall be Class B, Type 1, Special

