

INDEX OF SHEETS

- 1 COVER SHEET
- 2 GENERAL NOTES & SUMMARY OF QUANTITIES
- 3 TYPICAL SECTIONS
- 4 OVERALL SITE PLAN
- 5 SITE GRADING PLAN
- 6 EROSION CONTROL PLAN
- 7-8 PLAN AND PROFILE SHEET SHARED-USE PATH
- 9-10 CROSS SECTIONS SHARED-USE PATH
- 11 ADA RAMP DETAILS
- 12 DETAILS
- 13 ARCHITECTURAL FOUNDATION AND FLOOR PLAN
- 14-15 ARCHITECTURAL ELEVATIONS AND DETAILS

HIGHWAY STANDARDS

- 280001-07 TEMPORARY EROSION CONTROL SYSTEMS
- 542301-03 PRECAST REINFORCED CONCRETE FLARED END SECTION
- 701006-05 OFF-RD OPERATIONS, 2L, 2W, 15' TO 24" FROM PAVEMENT EDGE
- 701801-05 LANE CLOSURE, MULTILANE 1W OR 2W CROSSWALK OR SIDEWALK CLOSURE
- 701901-04 TRAFFIC CONTROL DEVICES
- 720011-01 METAL POSTS FOR SIGNS, MARKERS AND DELINEATORS
- 728001-01 TELESCOPING STEEL SIGN SUPPORT
- 729001-01 APPLICATIONS OF TYPE A AND B METAL POSTS (FOR SIGNS & MARKERS)

UTILITY OWNERS


GAS:
NICOR GAS
4651 LINDEN ROAD
ROCKFORD, IL 61109
(888) 642-6748

ELECTRIC:
COMMONWEALTH EDISON COMPANY
123 ENERGY AVENUE
ROCKFORD, IL 61109
(800) 334-7661

CABLE TV:
MEDIACOM
3033 ASBURY ROAD
DUBUQUE, IA 52004
(800) 332-0245

TELEPHONE:
VERIZON
112 W. ELM STREET
SYCAMORE, IL 60179
(800) 483-4000

WATER/SEWER:
VILLAGE OF PECATONICA
405 MAIN STREET
PECATONICA, IL 61063
(815) 239-2348

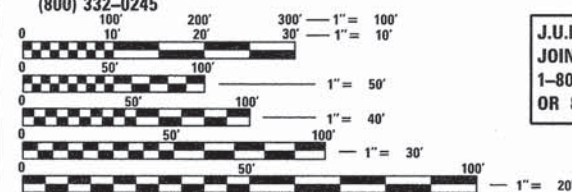

FULL SIZE PLANS HAVE BEEN PREPARED USING STANDARD ENGINEERING SCALES. REDUCED SIZED PLANS WILL NOT CONFORM TO STANDARD SCALES. IN MAKING MEASUREMENTS ON REDUCED PLANS, THE ABOVE SCALES MAY BE USED.

J.U.L.I.E.
JOINT UTILITY LOCATION INFORMATION FOR EXCAVATION
1-800-892-0123
OR 811




CALL J.U.L.I.E. BEFORE YOU DIG
1-800-892-0123
TOLL FREE

STATE OF ILLINOIS
DEPARTMENT OF TRANSPORTATION
DIVISION OF HIGHWAYS
**SUMNER PARK DISTRICT
CREEKSIDE PARK
SHARED-USE PATH
2015**

SECTION 14-P4000-00-SW
PROJECT NO. TE-00D2 (157)
WINNEBAGO COUNTY (PECATONICA)
JOB NO. C-92-020-15
ITEP NO. 231005
CONTRACT NO. 85618

LOCATION MAP

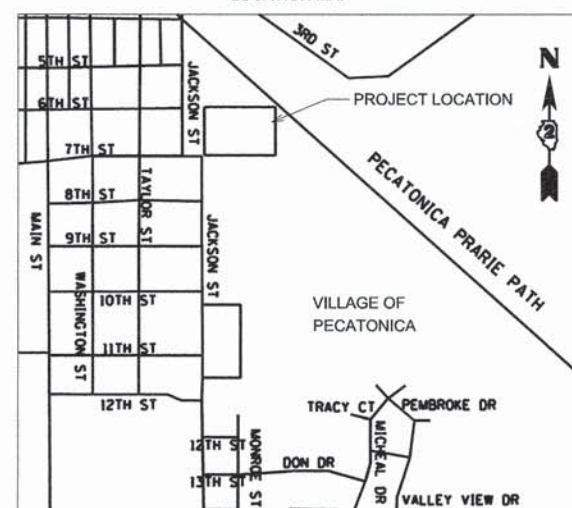

GROSS LENGTH = 545 FT. = 0.103 MILE

NET LENGTH = 545 FT. = 0.103 MILE

JACKSON STREET ADT: 850 VPD (2015), 3% TRUCKS

FUNCTIONAL CLASS: LOCAL ROAD

PREPARED FOR:

SUMNER PARK DISTRICT

CLIENT CONTACT
MR. MARK HERBIG

300 W. 1ST STREET
PECATONICA, IL 61063
(815) 239-1083

PREPARED BY:

CHASTAIN & ASSOCIATES LLC
345 EXECUTIVE PARKWAY,
SUITE L4
ROCKFORD, IL 61107
WWW.HLCLLP.COM
PH: (815) 489-0050
FAX: (815) 489-0055
PROJECT NO. 6202



Jason T. Stoll
DATE 7.17.15
LICENSE EXPIRES 11-30-2015

I, JASON T. STOLL, A LICENSED PROFESSIONAL ENGINEER IN THE STATE OF ILLINOIS, DO HEREBY CERTIFY THAT THE DESIGN PLANS & SPECIFICATIONS FOUND IN THE PAGES TO FOLLOW WERE PREPARED EITHER BY OR UNDER MY DIRECT SUPERVISION. TO THE BEST OF MY KNOWLEDGE, THESE DOCUMENTS COMPLY WITH APPLICABLE LAWS, CODES, AND ORDINANCES.

IL Licensed Design Firm No. 184.004975

F.A. RTE.	SECTION	COUNTY	TOTAL SHEETS	SHEET NO.
	14-P4000-00-SW	WINNEBAGO	15	1
ILLINOIS		CONTRACT NO.		



LOCATION OF SECTION INDICATED THUS: -

AGENCY RESPONSIBLE FOR LETTING

Approved July 20 2015
Date
Mark Herbig
Sumner Park District, President

Passed 7/22 2015
Date
Andy M. Daulton
District 2 Engineer of Local Roads & Streets

Releasing for Bld Based on Limited Review Date 7/22 2015
Paul D. Daulton
Deputy Director of Highways, Region 2 Engineer

**PRINTED BY THE AUTHORITY
OF THE STATE OF ILLINOIS**

GENERAL NOTES

1. ALL EARTHWORK AND GRADING SHALL BE PERFORMED IN ACCORDANCE WITH STANDARD SPECIFICATIONS FOR ROAD AND BRIDGE CONSTRUCTION IN ILLINOIS, STATE OF ILLINOIS DEPARTMENT OF TRANSPORTATION, CURRENT EDITION, AS WELL AS THE "SUPPLEMENTAL SPECIFICATIONS AND RECURRING SPECIAL PROVISION", CURRENT EDITION, AND ALL SUPPLEMENTS THERETO, AND THE REQUIREMENTS AND SPECIFICATIONS OF THE VILLAGE OF PECATONICA.
2. THE CONTRACTOR SHALL VERIFY THE LOCATION OF ALL UTILITIES IN THE FIELD PRIOR TO CONSTRUCTION. THIS INCLUDES SANITARY SEWER, WATERMAIN, STORM SEWER, GENERAL TELEPHONE, COMMONWEALTH EDISON, NICOR GAS, CABLE TELEVISION, AND FIBER OPTIC CABLE. THE J.U.L.I.E. NUMBER IS 1-800-892-0123.
3. ANY EXCESS DIRT OR MATERIALS TO BE REMOVED FROM THE SITE DURING CONSTRUCTION SHALL MEET WITH CONDITIONS AND TERMS AS DEFINED BY THE CONTRACT DOCUMENTS AND SPECIFICATIONS.
4. ALL ELEVATIONS ARE ILLINOIS STATE PLANE WEST DATUM.
5. THE CONTRACTOR SHALL FIELD VERIFY THE ELEVATIONS OF THE BENCHMARKS PRIOR TO COMMENCING WORK. THE CONTRACTOR SHALL ALSO FIELD VERIFY THE LOCATION AND ELEVATION OF EXISTING PIPE INVERTS, CURB OR PAVEMENT WHERE MATCHING INTO EXISTING WORK. THE CONTRACTOR SHALL FIELD VERIFY HORIZONTAL CONTROL BY REFERENCING PROPERTY CORNERS TO THE PROPERTY LINES. NOTIFY THE ENGINEER OF DISCREPANCIES IN EITHER VERTICAL OR HORIZONTAL CONTROL PRIOR TO PROCEEDING.
6. PROPERTY CORNERS SHALL BE CAREFULLY PROTECTED UNTIL THEY HAVE BEEN REFERENCED BY A PROFESSIONAL LAND SURVEYOR. PROPERTY CORNERS DISTURBED BY THE CONTRACTOR'S OPERATIONS SHALL BE REPLACED AT THE CONTRACTOR'S EXPENSE.
7. ALL SIGNS AND MAILBOXES SHALL BE REMOVED AS REQUIRED DURING CONSTRUCTION ACTIVITIES AND STORED IN A SECURE LOCATION DURING CONSTRUCTION ACTIVITIES. TEMPORARY MAILBOXES SHALL BE INSTALLED AND MAINTAINED DURING CONSTRUCTION AND SHALL BE INCIDENTAL TO THE CONTRACT. PRIOR TO COMPLETION OF THE PROJECT, THE SIGNS AND MAILBOXES SHALL BE REINSTALLED ALONG THE SAME STATION AS WHERE REMOVED. SIGNS, POSTS, AND MAILBOXES DAMAGED DURING REMOVAL AND REPLACEMENT SHALL BE REPLACED AT CONTRACTOR EXPENSE. THIS WORK SHALL BE INCIDENTAL TO THE CONTRACT.
9. THE CONTRACTOR SHALL MAINTAIN ACCESS TO FIRE HYDRANTS, WATER AND GAS VALVES, AND ALL SEWER, WATER AND UTILITY MANHOLES.
10. ALL DISTURBED AREAS SHALL BE RESTORED TO PREDEVELOPED CONDITIONS, AND SHALL MEET THE APPROVAL OF THE ENGINEER.
11. THE PROJECT SHALL BE COMPLETED IN ACCORDANCE WITH THE APPROVED SPECIFICATIONS. ANY DISCREPANCIES BETWEEN THE APPROVED SPECIFICATIONS AND THE CONSTRUCTION PLANS SHALL WARRANT WRITTEN NOTIFICATION THAT SHALL BE SUBMITTED TO THE ENGINEER PRIOR TO CONSTRUCTION. IN THE EVENT THAT DISCREPANCIES EXIST, THE SPECIFICATIONS CONTAINED WITHIN THE CONTRACT DOCUMENTS SHALL GOVERN.
12. CURING AND PROTECTION OF ALL CONCRETE SHALL BE IN STRICT CONFORMANCE WITH THE PROVISIONS OF SECTION 1020.13 OF STANDARD SPECIFICATIONS FOR ROAD AND BRIDGE CONSTRUCTION IN ILLINOIS.
13. THE CURB AND GUTTER SHALL HAVE 1"-THICK PREMOULDED FIBER EXPANSION JOINTS WITH 3/4"-DIAMETER BY 18-INCHES LONG PLAIN ROUND STEEL DOWEL BARS AT 100-FOOT INTERVALS, AT ALL PC'S AND PT'S, AND AT ALL CURB RETURNS. CONTRACTION JOINTS SHALL BE CONSTRUCTED AT 25-FOOT INTERVALS. THE COST OF THESE JOINTS SHALL BE INCIDENTAL.
14. METHOD OF ADJUSTMENT FOR SANITARY MANHOLES SHALL MEET WITH THE FOLLOWING REQUIREMENTS:

a. A MINIMUM OF 4 INCHES OF ADJUSTING RINGS (4" ADJUSTMENT RING NOT REQUIRED IN TURF AREA OR CURB AND GUTTER ROADWAYS).

b. A MAXIMUM OF 12 INCHES OF ADJUSTING RINGS. NO MORE THAN ONE (1) 2 INCH ADJUSTING RING PER MANHOLE. A MAXIMUM OF 30 INCHES FROM THE TOP OF CASTING TO THE FIRST STEP.

c. MANHOLE ADJUSTMENT BY GROUTING IS NOT PERMITTED. ANY DISTURBED AREAS SHALL BE KEPT TO PRACTICAL MINIMUM AND SHALL BE MULCHED, SEEDED, SODDED OR PAVED AS SOON AS POSSIBLE.
15. ALL INLETS, STRUCTURES, PIPES, SWALES, AND ROADS SHALL BE KEPT CLEAN AND FREE OF DIRT AND SILT.


STANDARD CONDITIONS & TERMS

1. PROPERTY LINE INFORMATION SHOWN ON THE PLANS IS FOR INFORMATION ONLY AND WAS PROVIDED BY THE COUNTY GIS PROVIDER, WINGIS: WWW.WINGIS.ORG.
2. DISCREPANCIES FOUND ON THE PLANS AND/OR SPECIFICATIONS SHALL BE IMMEDIATELY REPORTED IN WRITING TO THE ENGINEER.
3. CONTRACTOR SHALL REMOVE AND DISPOSE OF ALL DEBRIS, RUBBISH AND OTHER MATERIAL RESULTING FROM DEMOLITION OPERATIONS. DISPOSAL SHALL BE IN ACCORDANCE WITH ALL LOCAL AND STATE AND OR FEDERAL REGULATIONS REGARDING SUCH OPERATIONS.
4. THE CONTRACTOR WILL BE HELD SOLELY RESPONSIBLE FOR AND SHALL TAKE PRECAUTIONS NECESSARY TO AVOID PROPERTY DAMAGE TO ADJACENT PROPERTIES DURING THE CONSTRUCTION OF THIS PROJECT.
5. THE DESIGNS REPRESENTED IN THESE PLANS ARE IN ACCORDANCE WITH ESTABLISHED PRACTICES OF CIVIL ENGINEERING FOR THE DESIGN FUNCTIONS AND USES INTENDED BY THE OWNER AT THIS TIME. HOWEVER, NEITHER THE ENGINEER NOR ITS PERSONNEL WARRANT THESE DESIGNS OR PLANS AS CONSTRUCTED.
6. IN ACCORDANCE WITH GENERALLY ACCEPTED CONSTRUCTION PRACTICES, THE CONTRACTOR SHALL BE SOLELY AND COMPLETELY RESPONSIBLE FOR CONDITIONS OF THE JOB SITE, INCLUDING SAFETY OF ALL PERSONS AND PROPERTY DURING PERFORMANCE OF THE WORK. THIS REQUIREMENT WILL APPLY CONTINUOUSLY AND NOT BE LIMITED TO NORMAL WORKING HOURS. ANY CONSTRUCTION OBSERVATION BY THE ENGINEER OF THE CONTRACTOR'S PERFORMANCE IS NOT INTENDED TO INCLUDE REVIEW OF THE ADEQUACY OF THE CONTRACTORS SAFETY MEASURES. IN, OR NEAR, THE CONSTRUCTION SITE.


SUMMARY OF QUANTITIES

CONSTRUCTION CODE: 0028			
CODE NO.	ITEM	UNIT	TOTAL QUANTITY
20101100	TREE TRUNK PROTECTION	EACH	2
20200100	EARTH EXCAVATION	CU YD	1200
* 20201200	REMOVAL AND DISPOSAL OF UNSUITABLE MATERIAL	CU YD	100
20400800	FURNISHED EXCAVATION	CU YD	4500
21101615	TOPSOIL FURNISH AND PLACE, 4"	SQ YD	4332
25000110	SEEDING, CLASS 1A	ACRE	0.90
25000400	NITROGEN FERTILIZER NUTRIENT	POUND	81
25000500	PHOSPHORUS FERTILIZER NUTRIENT	POUND	81
25000600	POTASSIUM FERTILIZER NUTRIENT	POUND	81
25100635	HEAVY DUTY EROSION CONTROL BLANKET	SQ YD	4332
28000400	PERIMETER EROSION BARRIER	FOOT	935
28000500	INLET AND PIPE PROTECTION	EACH	1
28100105	STONE RIPRAP, CLASS A3	SQ YD	61
28200200	FILTER FABRIC	SQ YD	61
* 30300011	AGGREGATE SUBGRADE IMPROVEMENT	TON	110
35101800	AGGREGATE BASE COURSE, TYPE B 6"	SQ YD	556
* 40600275	BITUMINOUS MATERIALS (PRIME COAT)	POUND	1165
40603415	HOT-MIX ASPHALT SURFACE COURSE, IL-9.5FG, N50	TON	62
542A1063	PIPE CULVERTS, CLASS A, TYPE 2 18"	FOOT	78
54213663	PRECAST REINFORCED CONCRETE FLARED END SECTIONS 18"	EACH	2
Δ* 56200300	WATER SERVICE LINE 1"	FOOT	60
Δ* 56500800	DOMESTIC WATER SERVICE BOXES	EACH	1
60255500	MANHOLES TO BE ADJUSTED	EACH	1
67100100	MOBILIZATION	L SUM	1
Δ* 80300100	LOCATING UNDERGROUND CABLE	FOOT	100
Δ* 80400100	ELECTRIC SERVICE INSTALLATION	EACH	1
* X7010216	TRAFFIC CONTROL AND PROTECTION, SPECIAL	L SUM	1
* Z0013798	CONSTRUCTION LAYOUT	L SUM	1
Δ* Z0056700	SANITARY SEWER 4"	FOOT	70
Δ* XX005498	SANITARY CLEANOUT 4"	EACH	2
Δ* XX007056	BUILDING	L SUM	1

* = SPECIAL PROVISION
Δ = SPECIALTY ITEMS

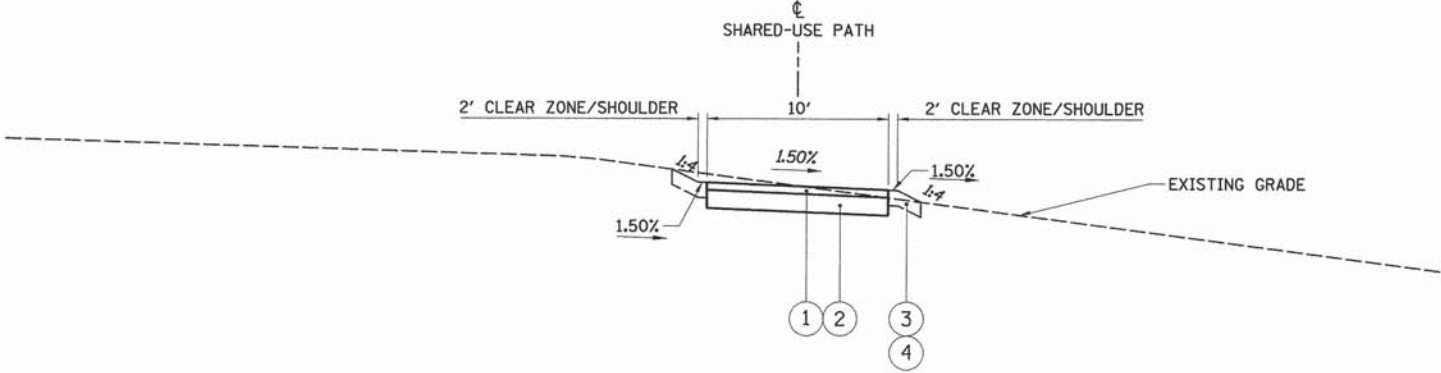

PROPOSED SHARED-USE PATH TYPICAL SECTION
STA 0+00 TO 1+50

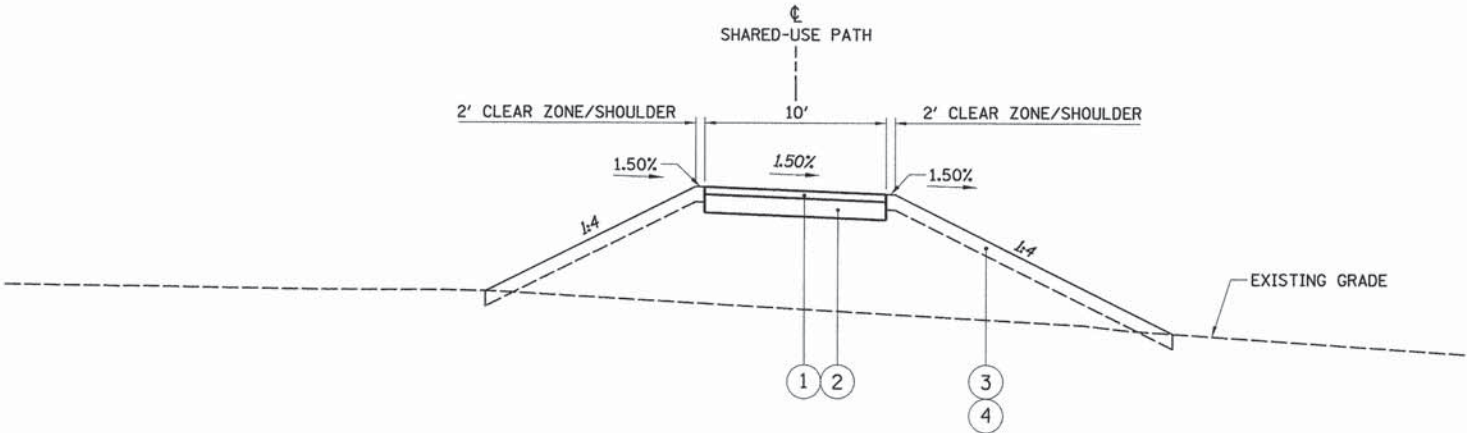


PROPOSED SHARED-USE PATH TYPICAL SECTION
STA 1+50 TO 4+84.48


- PROPOSED LEGEND
- ① HOT-MIX ASPHALT SURFACE COURSE, IL-9.5FG, N50 - 2"
 - ② AGGREGATE BASE COURSE, TYPE B, 6"
 - ③ TOPSOIL FURNISH AND PLACE, 4"
 - ④ SEEDING, CLASS 1A / EROSION CONTROL BLANKET

MIX DESIGN TABLE


SHARED-USE PATH	
USAGE	SURFACE
AC	PG 64-22
VOIDS	4.0% @ N50
MIX	IL 9.5 FG
FRICTION AGG.	C
MIX UNIT WEIGHT	112 LB/SY/IN

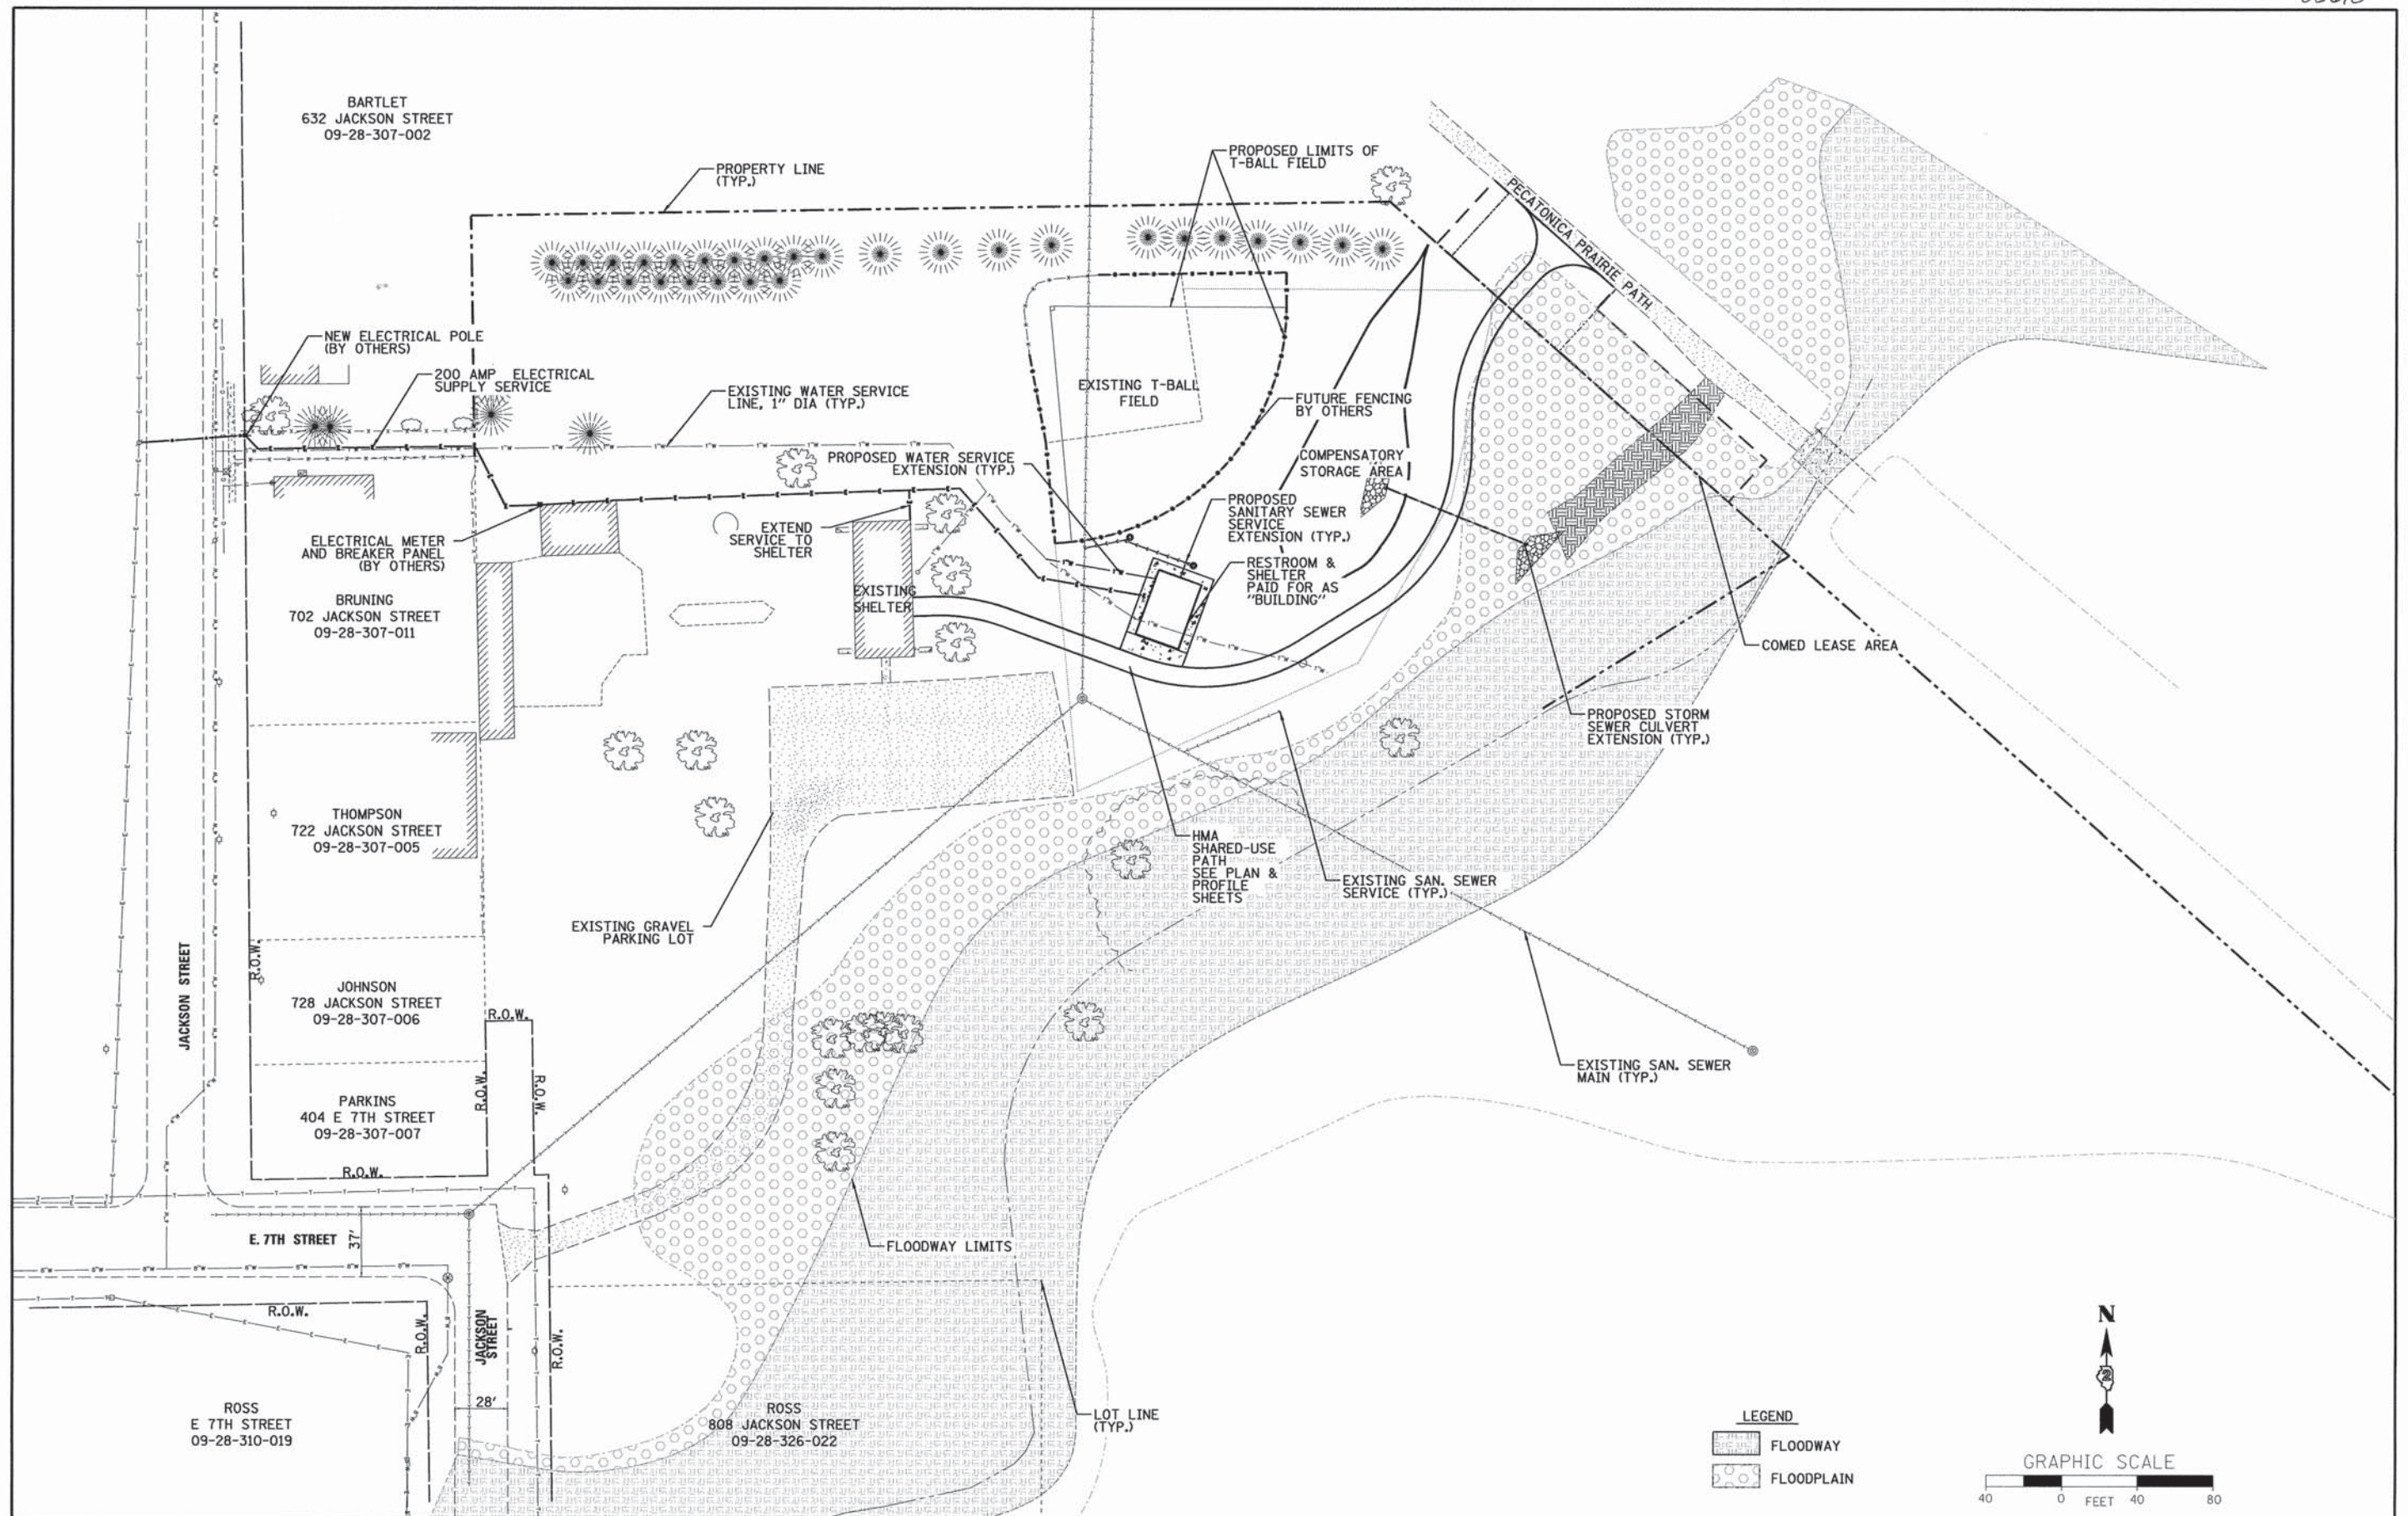

CHASTAIN & ASSOCIATES LLC CONSULTING ENGINEERS	USER NAME = estone	DESIGNED -	REVISED -	CREEKSIDE PARK SHARED-USE PATH VILLAGE OF PECATONICA	OVERALL SITE PLAN	1"=40' SHEET OF SHEETS STA. 0+00 TO STA. 2+77.80	F.A. RTE. SECTION COUNTY TOTAL SHEETS SHEET NO. 14-P4000-00-SW WINNEBAGO 15 4 CONTRACT NO. ILLINOIS FED. AID PROJECT
	PLOT SCALE = 48,0000' / in.	DRAWN -	REVISED -				
	PLOT DATE = 7/17/2015	CHECKED -	REVISED -				
		DATE -	REVISED -				

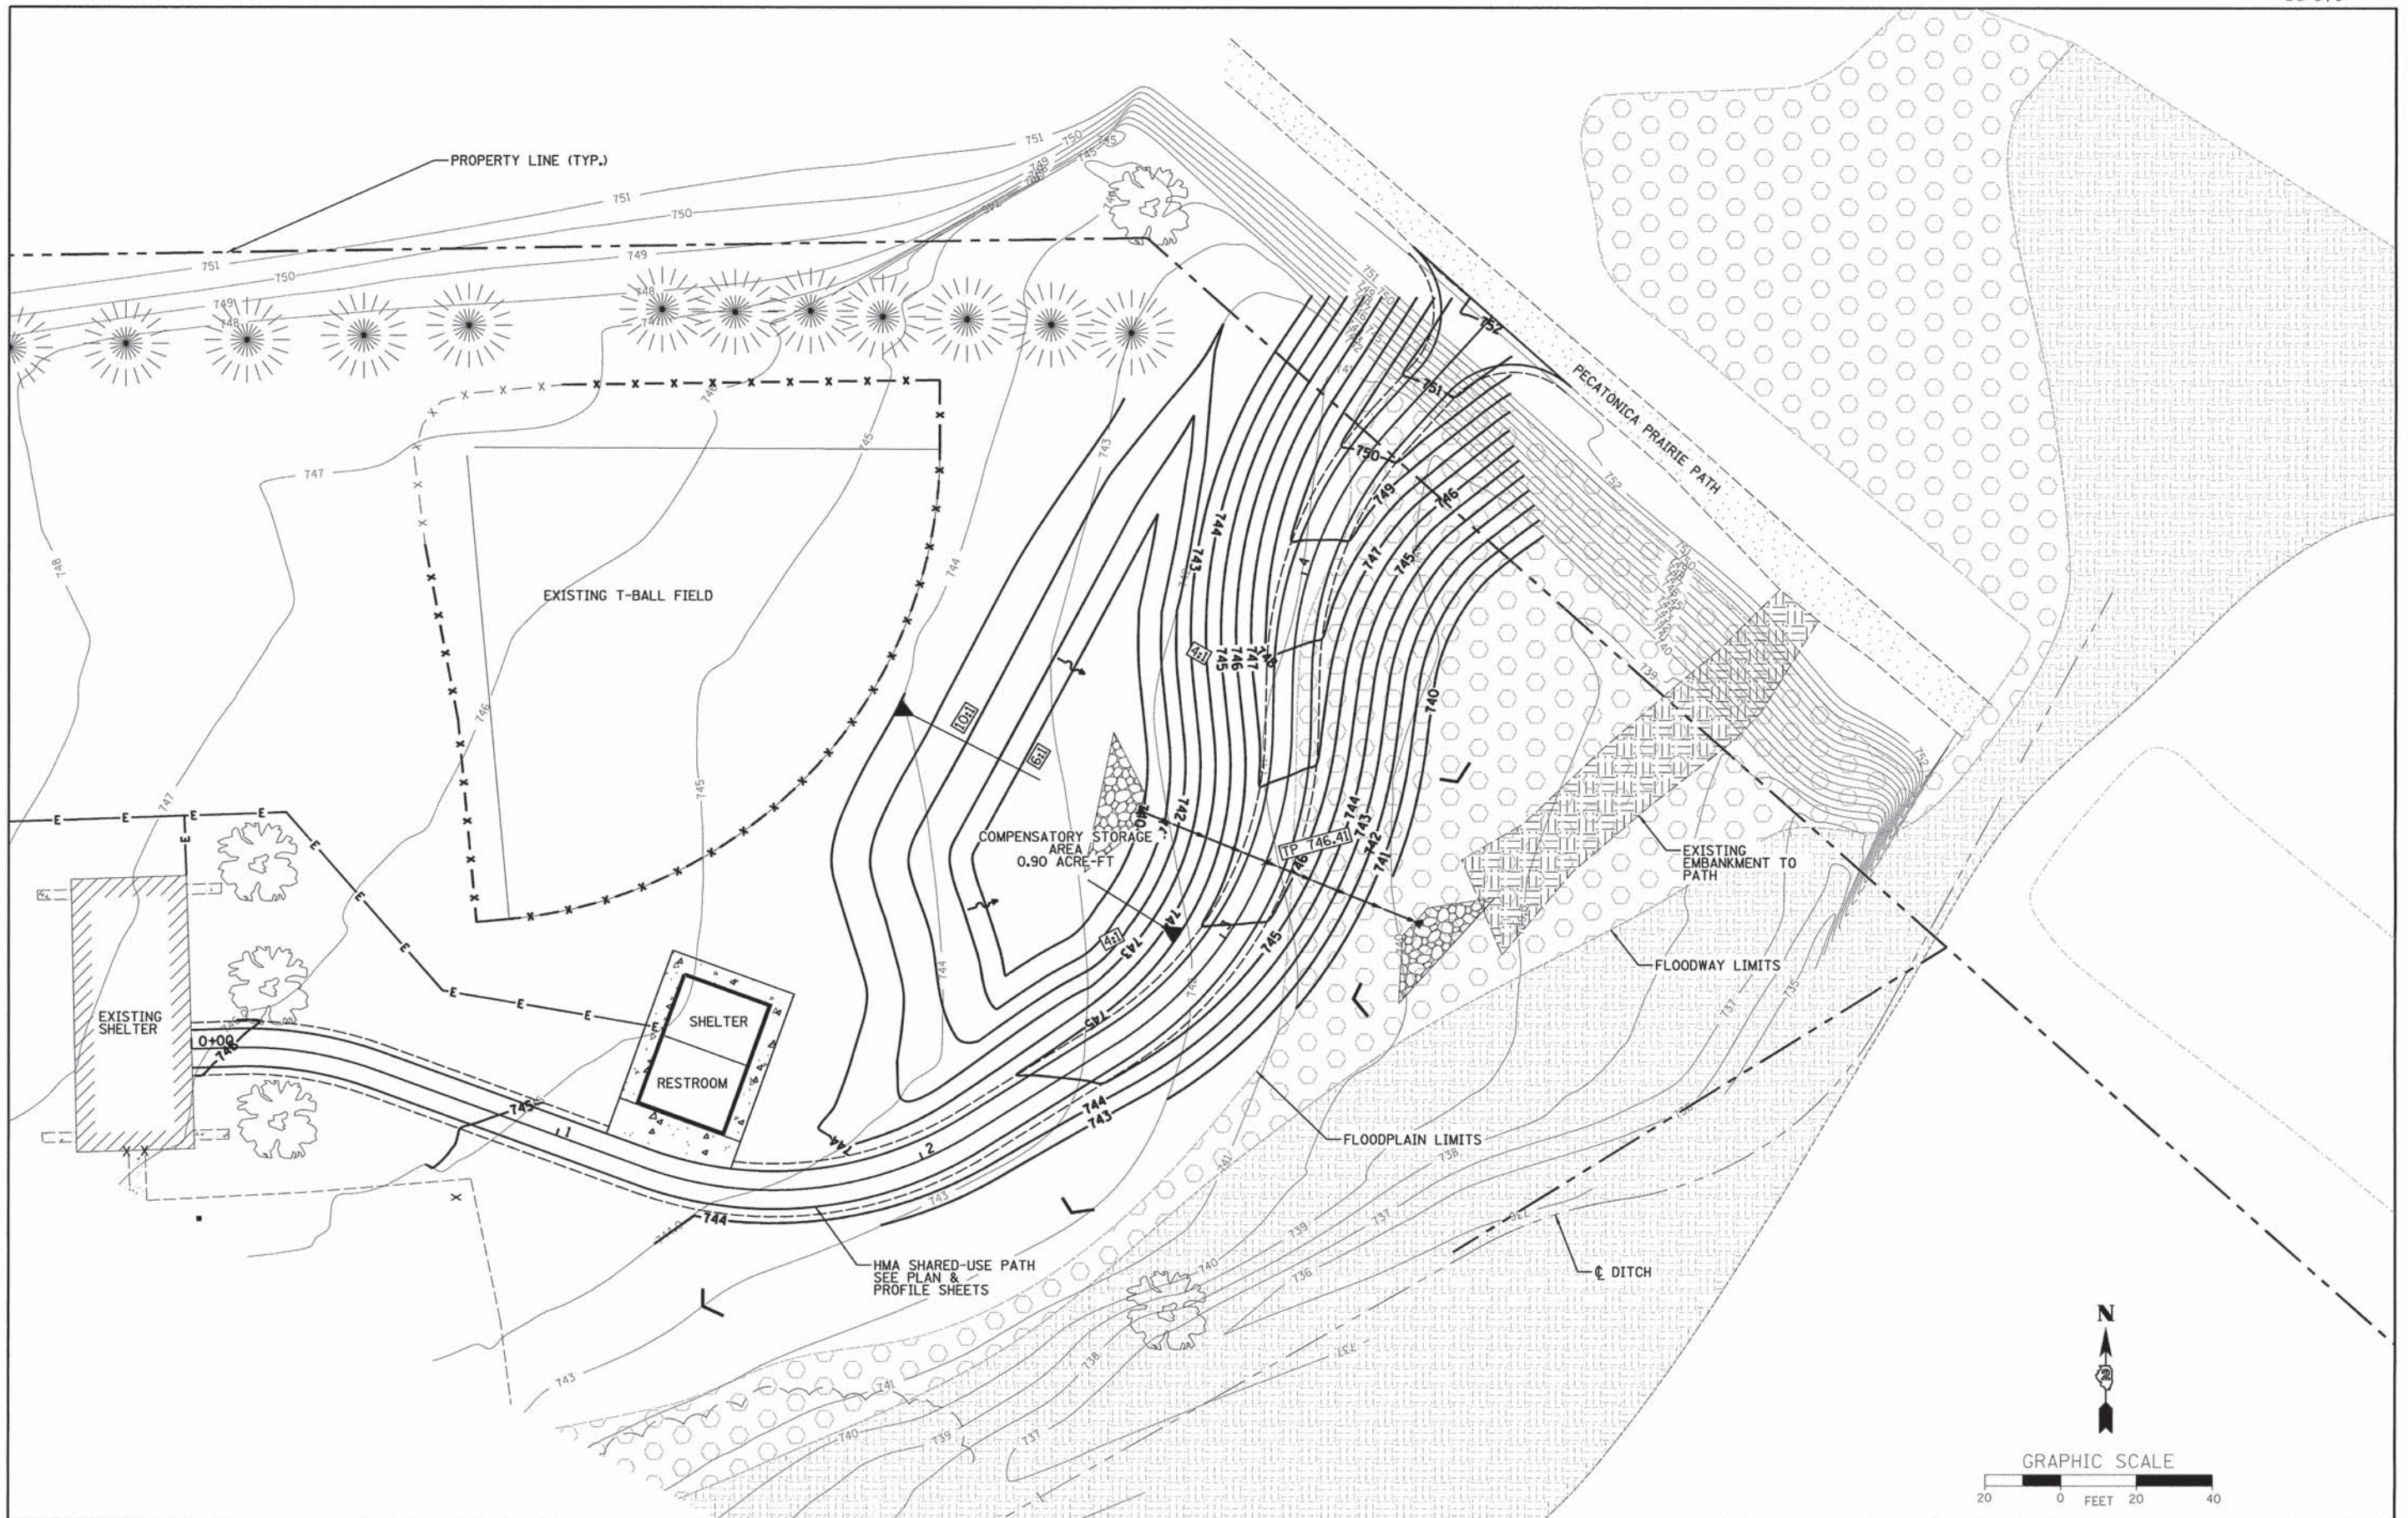


 CHASTAIN & ASSOCIATES LLC <u>CONSULTING ENGINEERS</u>	USER NAME = estone	DESIGNED -	REVISED -	CREEKSIDE PARK SHARED-USE PATH VILLAGE OF PECATONICA	SITE GRADING PLAN				F.A. RTE.	SECTION	COUNTY	TOTAL SHEETS	SHEET NO.
	PLOT SCALE = 20.0000 ' / in.	DRAWN -	REVISED -							14-P4000-00-SW	WINNEBAGO	15	5
	PLOT DATE = 7/17/2015	CHECKED -	REVISED -		1"=20' SHEET 2 OF 2 SHEETS STA. 0+00 TO STA. 5+42.34					CONTRACT NO.			
		DATE -	REVISED -							ILLINOIS FED. AID PROJECT			

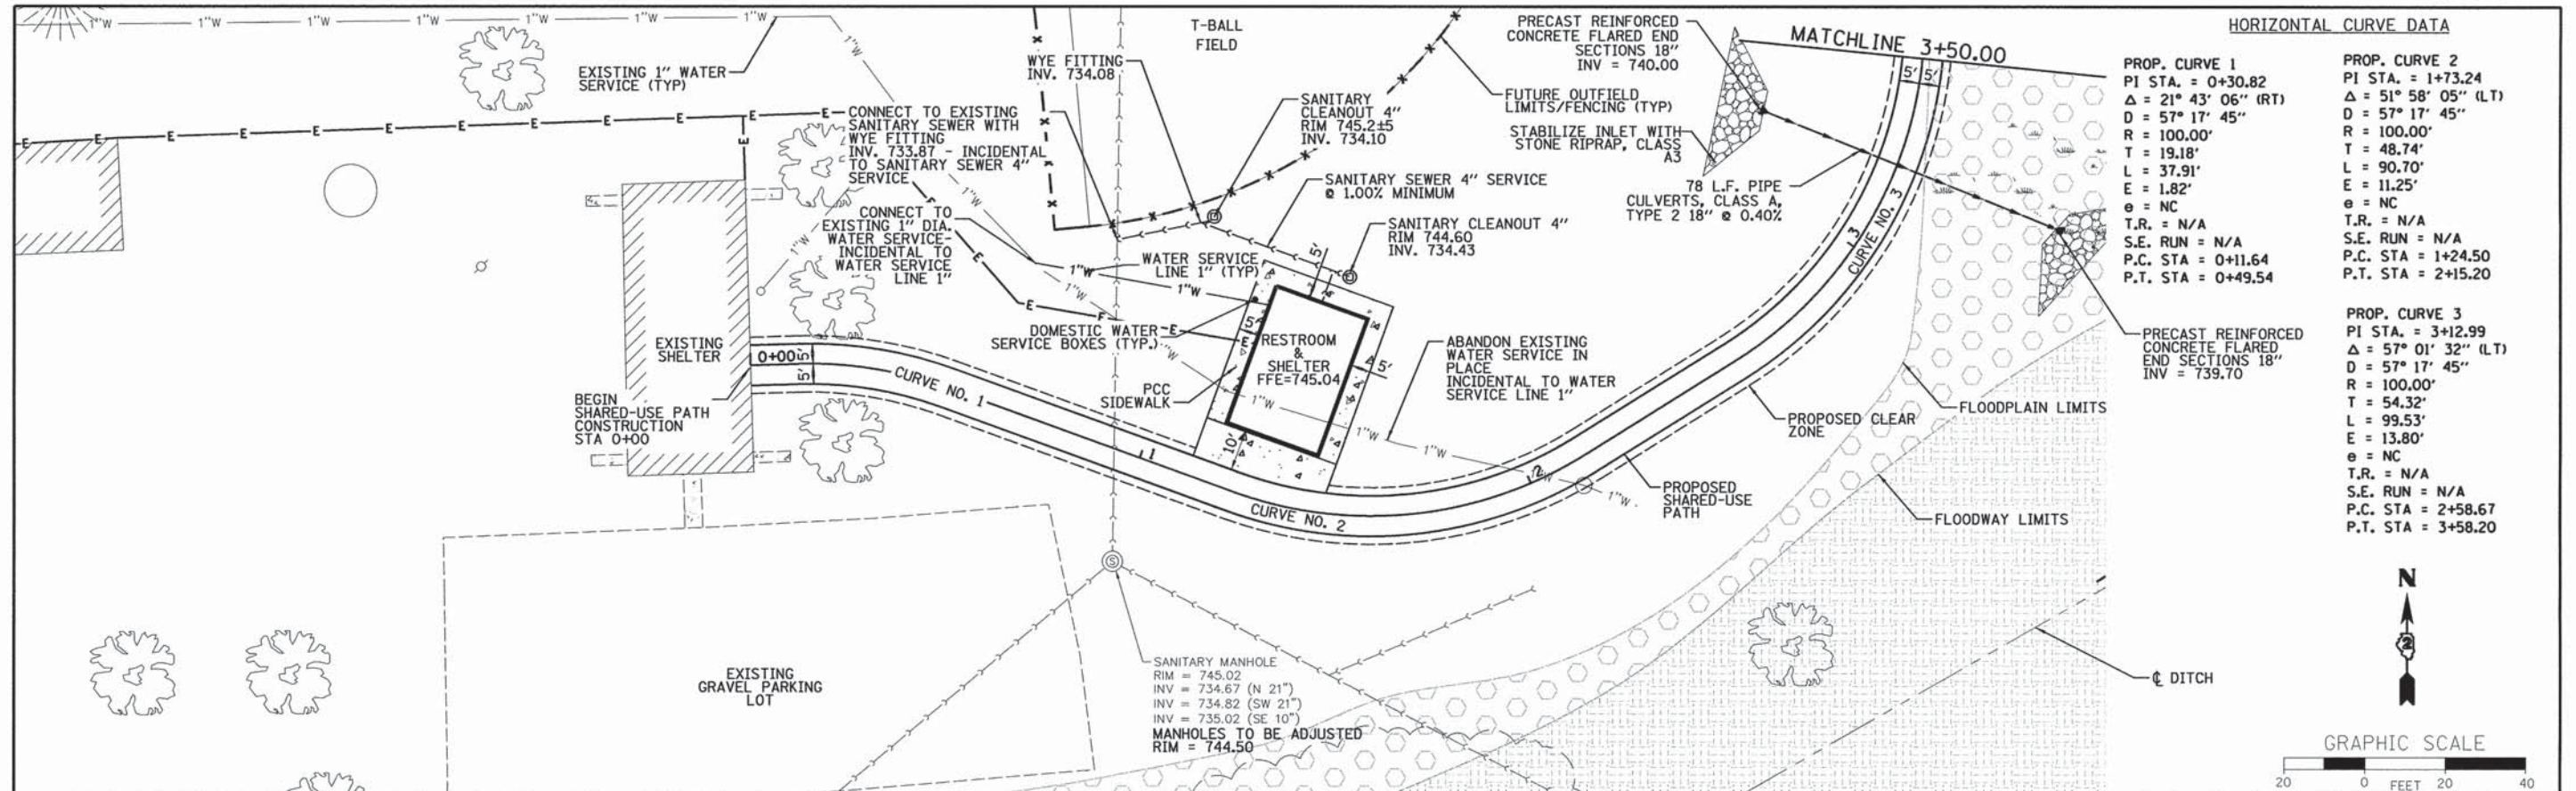

HORIZONTAL CURVE DATA

PROP. CURVE 1 PI STA. = 0+30.82 $\Delta = 21^\circ 43' 06''$ (RT) $D = 57^\circ 17' 45''$ $R = 100.00'$ $T = 19.18'$ $L = 37.91'$ $E = 1.82'$ $e = NC$ $T.R. = N/A$ $S.E. RUN = N/A$ $P.C. STA = 0+11.64$ $P.T. STA = 0+49.54$	PROP. CURVE 2 PI STA. = 1+73.24 $\Delta = 51^\circ 58' 05''$ (LT) $D = 57^\circ 17' 45''$ $R = 100.00'$ $T = 48.74'$ $L = 90.70'$ $E = 11.25'$ $e = NC$ $T.R. = N/A$ $S.E. RUN = N/A$ $P.C. STA = 1+24.50$ $P.T. STA = 2+15.20$
PROP. CURVE 3 PI STA. = 3+12.99 $\Delta = 57^\circ 01' 32''$ (LT) $D = 57^\circ 17' 45''$ $R = 100.00'$ $T = 54.32'$ $L = 99.53'$ $E = 13.80'$ $e = NC$ $T.R. = N/A$ $S.E. RUN = N/A$ $P.C. STA = 2+58.67$ $P.T. STA = 3+58.20$	

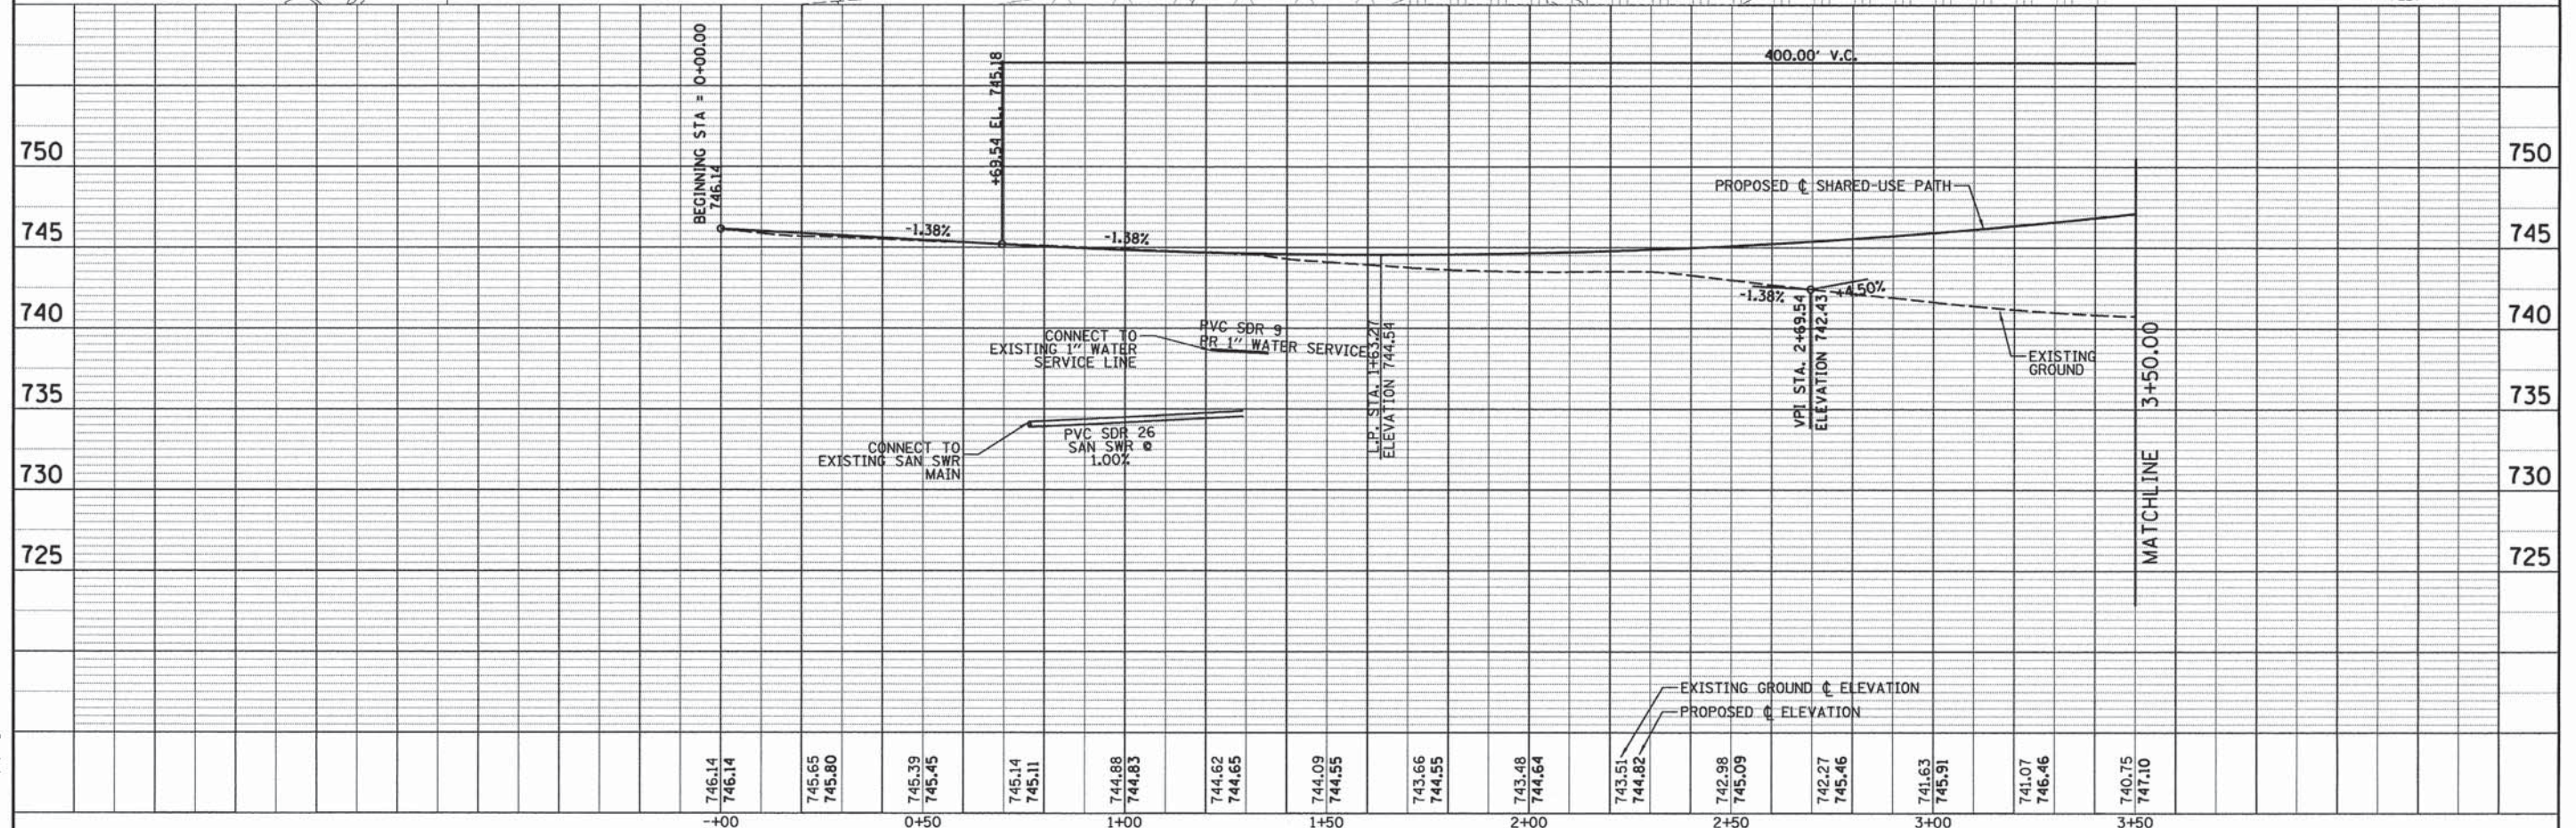

CHASTAIN & ASSOCIATES LLC CONSULTING ENGINEERS	USER NAME = estone	DESIGNED - ES	REVISED -	CREEKSIDE PARK SHARED-USE PATH VILLAGE OF PECATONICA	PLAN AND PROFILE SHARED-USE PATH	SCALE: 1"=20'	SHEET 1 OF 2 SHEETS	STA. 0+00 TO STA. 3+50	F.A. RTE.	SECTION	COUNTY	TOTAL SHEETS	SHEET NO.
	PLOT SCALE = 20.0000' / in.	DRAWN - DW	REVISED -										
	PLOT DATE = 7/17/2015	CHECKED - JS	REVISED -										
	DATE = 8/6/14	REVISED -											

HORIZONTAL CURVE DATA


PROP. CURVE 4
 PI STA. = 4+11.05
 Δ = 41° 27' 42" (RT)
 D = 57° 17' 45"
 R = 100.00'
 T = 37.85'
 L = 72.36'
 E = 6.92'
 E = NC
 T.R. = N/A
 S.E. RUN = N/A
 P.C. STA = 3+73.20
 P.T. STA = 4+45.56

BENCHMARK 1, WJ 018
 PID: D03647
 POSITION: 42° 18' 39.69" N, 89° 21' 09.14" W
 HEIGHT: 741.98



GRAPHIC SCALE

20 0 FEET 20 40

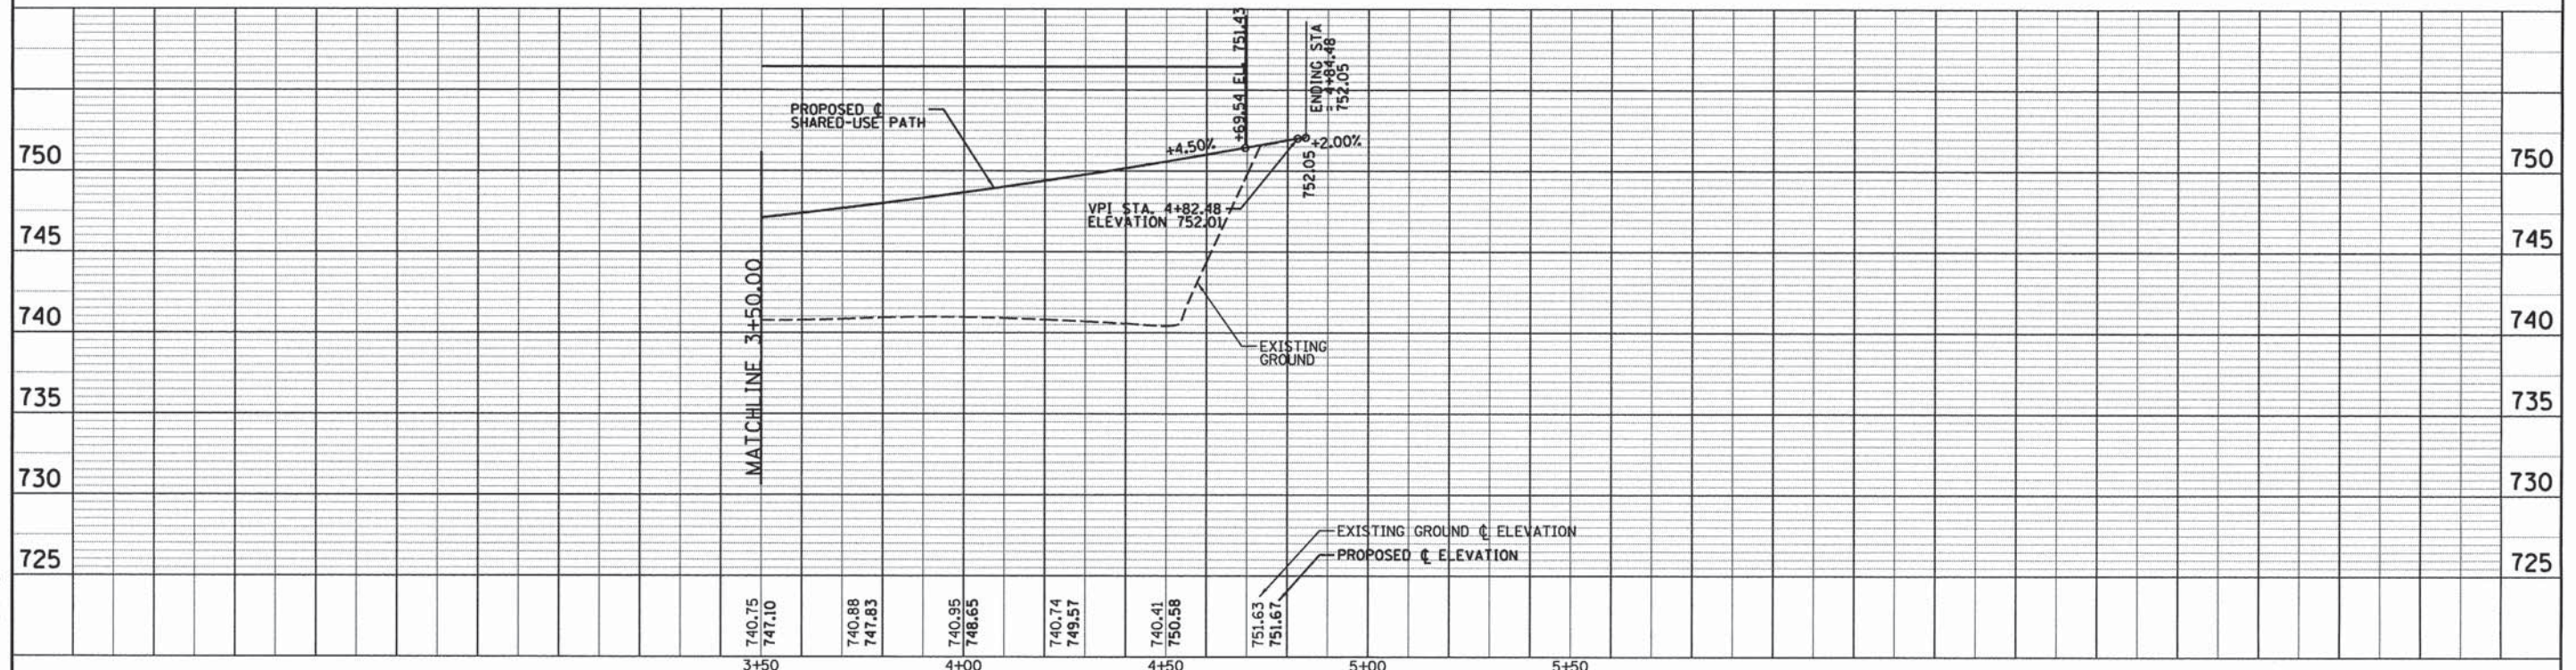

CHASTAIN & ASSOCIATES LLC
 CONSULTING ENGINEERS

USER NAME = estone

PLOT SCALE = 20.0000" / in.

PLOT DATE = 7/17/2015

DESIGNED - ES

DRAWN - DW

CHECKED - JS

DATE - 8/6/14

REVISED -

REVISED -

REVISED -

REVISED -

**CREEKSIDE PARK SHARED-USE PATH
 VILLAGE OF PECATONICA**


**PLAN AND PROFILE
 SHARED-USE PATH**

SCALE: 1"=20' SHEET 2 OF 2 SHEETS STA. 3+50 TO STA. 5+45.00

F.A. RTE.	SECTION	COUNTY	TOTAL SHEETS	SHEET NO.
	14-P4000-00-SW	WINNEBAGO	15	8
PROJECT NO. 6202				
ILLINOIS FED. AID PROJECT				

DATE	BY	DATE	BY
FINAL SURVEY	SURVEYED	PLOTTED	DATE
NOTE BOOK	NO.	NO.	NO.


DATE	BY	DATE	BY
ORIGINAL SURVEY	SURVEYED	PLOTTED	DATE
NOTE BOOK	NO.	NO.	NO.

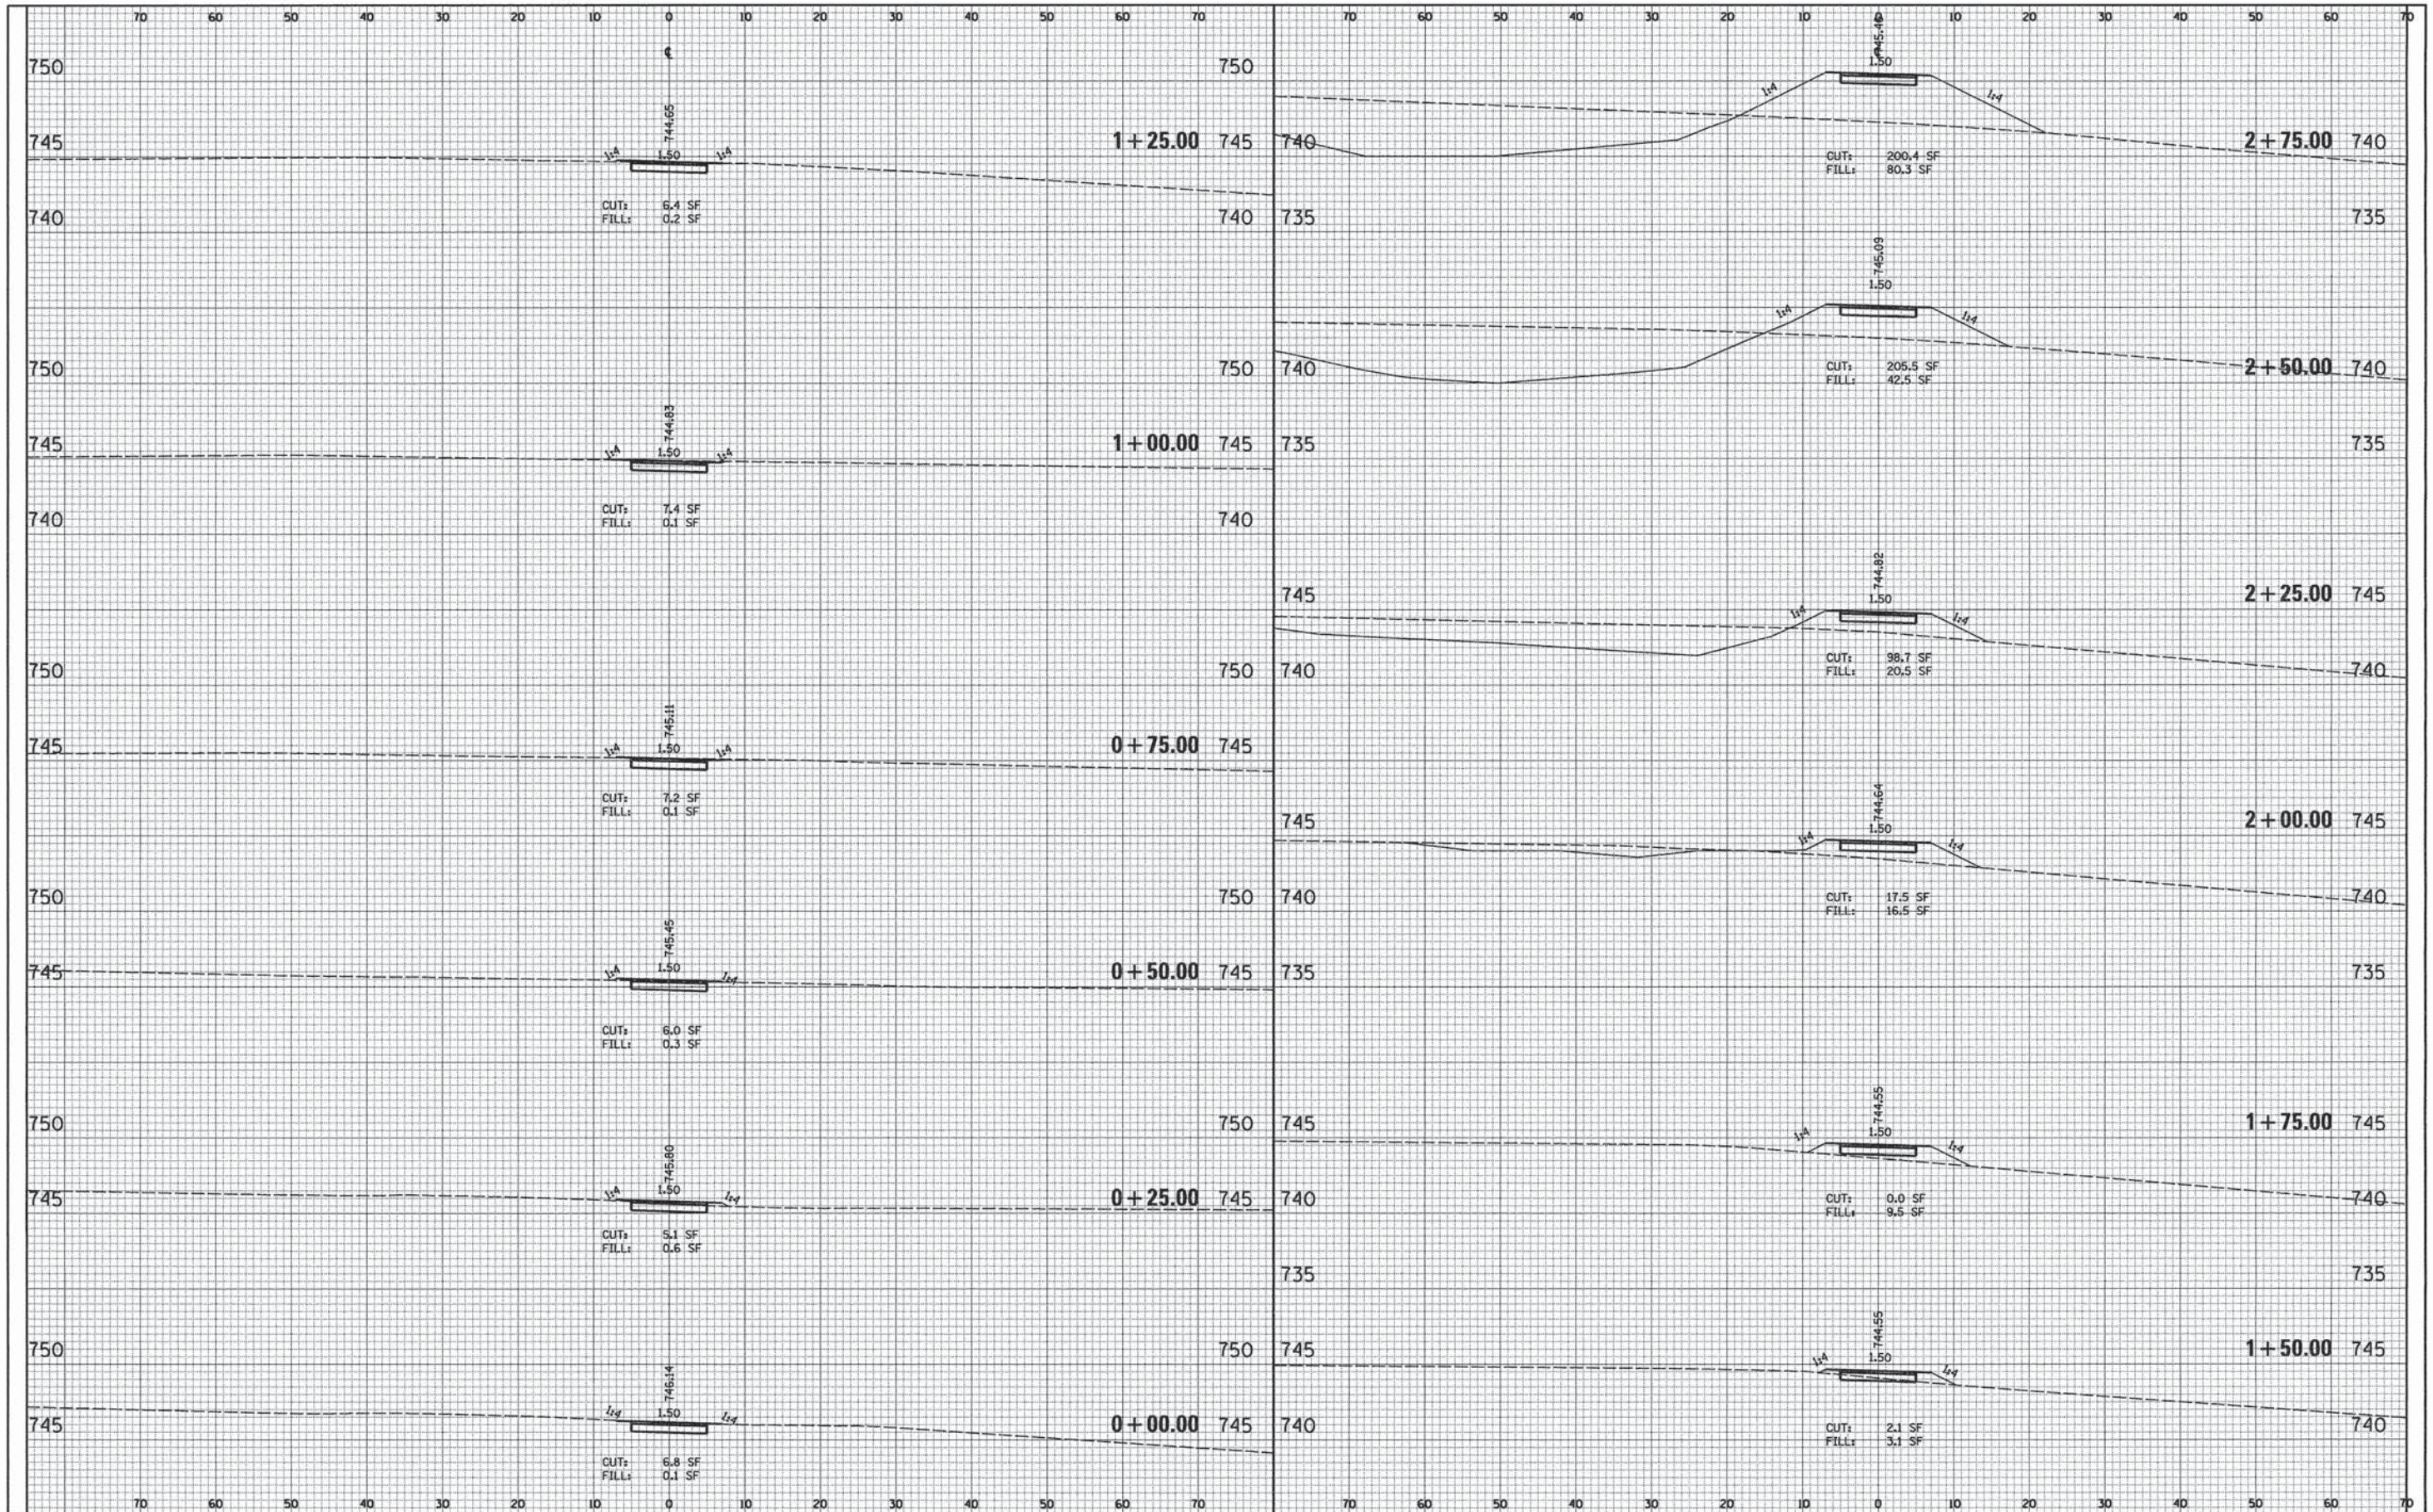


FILE NAME *	USER NAME *	DESIGNED -	REVISED -	CREEKSIDE PARK SHARED-USE PATH VILLAGE OF PECATONICA		CROSS SECTIONS SHARED-USE PATH		F.A. RTE.	SECTION	COUNTY	TOTAL SHEETS	SHEET NO.
14-Shr_Xsc.dgn		DRAWN -	REVISED -						14-P4000-00-SW	WINNEBAGO	15	9
#MODELNAME*	PLOT SCALE = 10.0000" / 1"	CHECKED -	REVISED -									
	PLOT DATE = 7/17/2015	DATE -	REVISED -									
				SCALE:		SHEET 1 OF 3 SHEETS		STA. 0+00.00 TO STA. 2+50.00		ILLINOIS FED. AID PROJECT		

FINAL	SURVEYED	DATE
SURVEY	PLOTTED	BY
NOTE BOOK	TEMPLATE	
NO.	AREAS CHECKED	



ORIGINAL	SURVEYED	DATE
SURVEY	PLOTTED	BY
NOTE BOOK	TEMPLATE	
NO.	AREAS CHECKED	

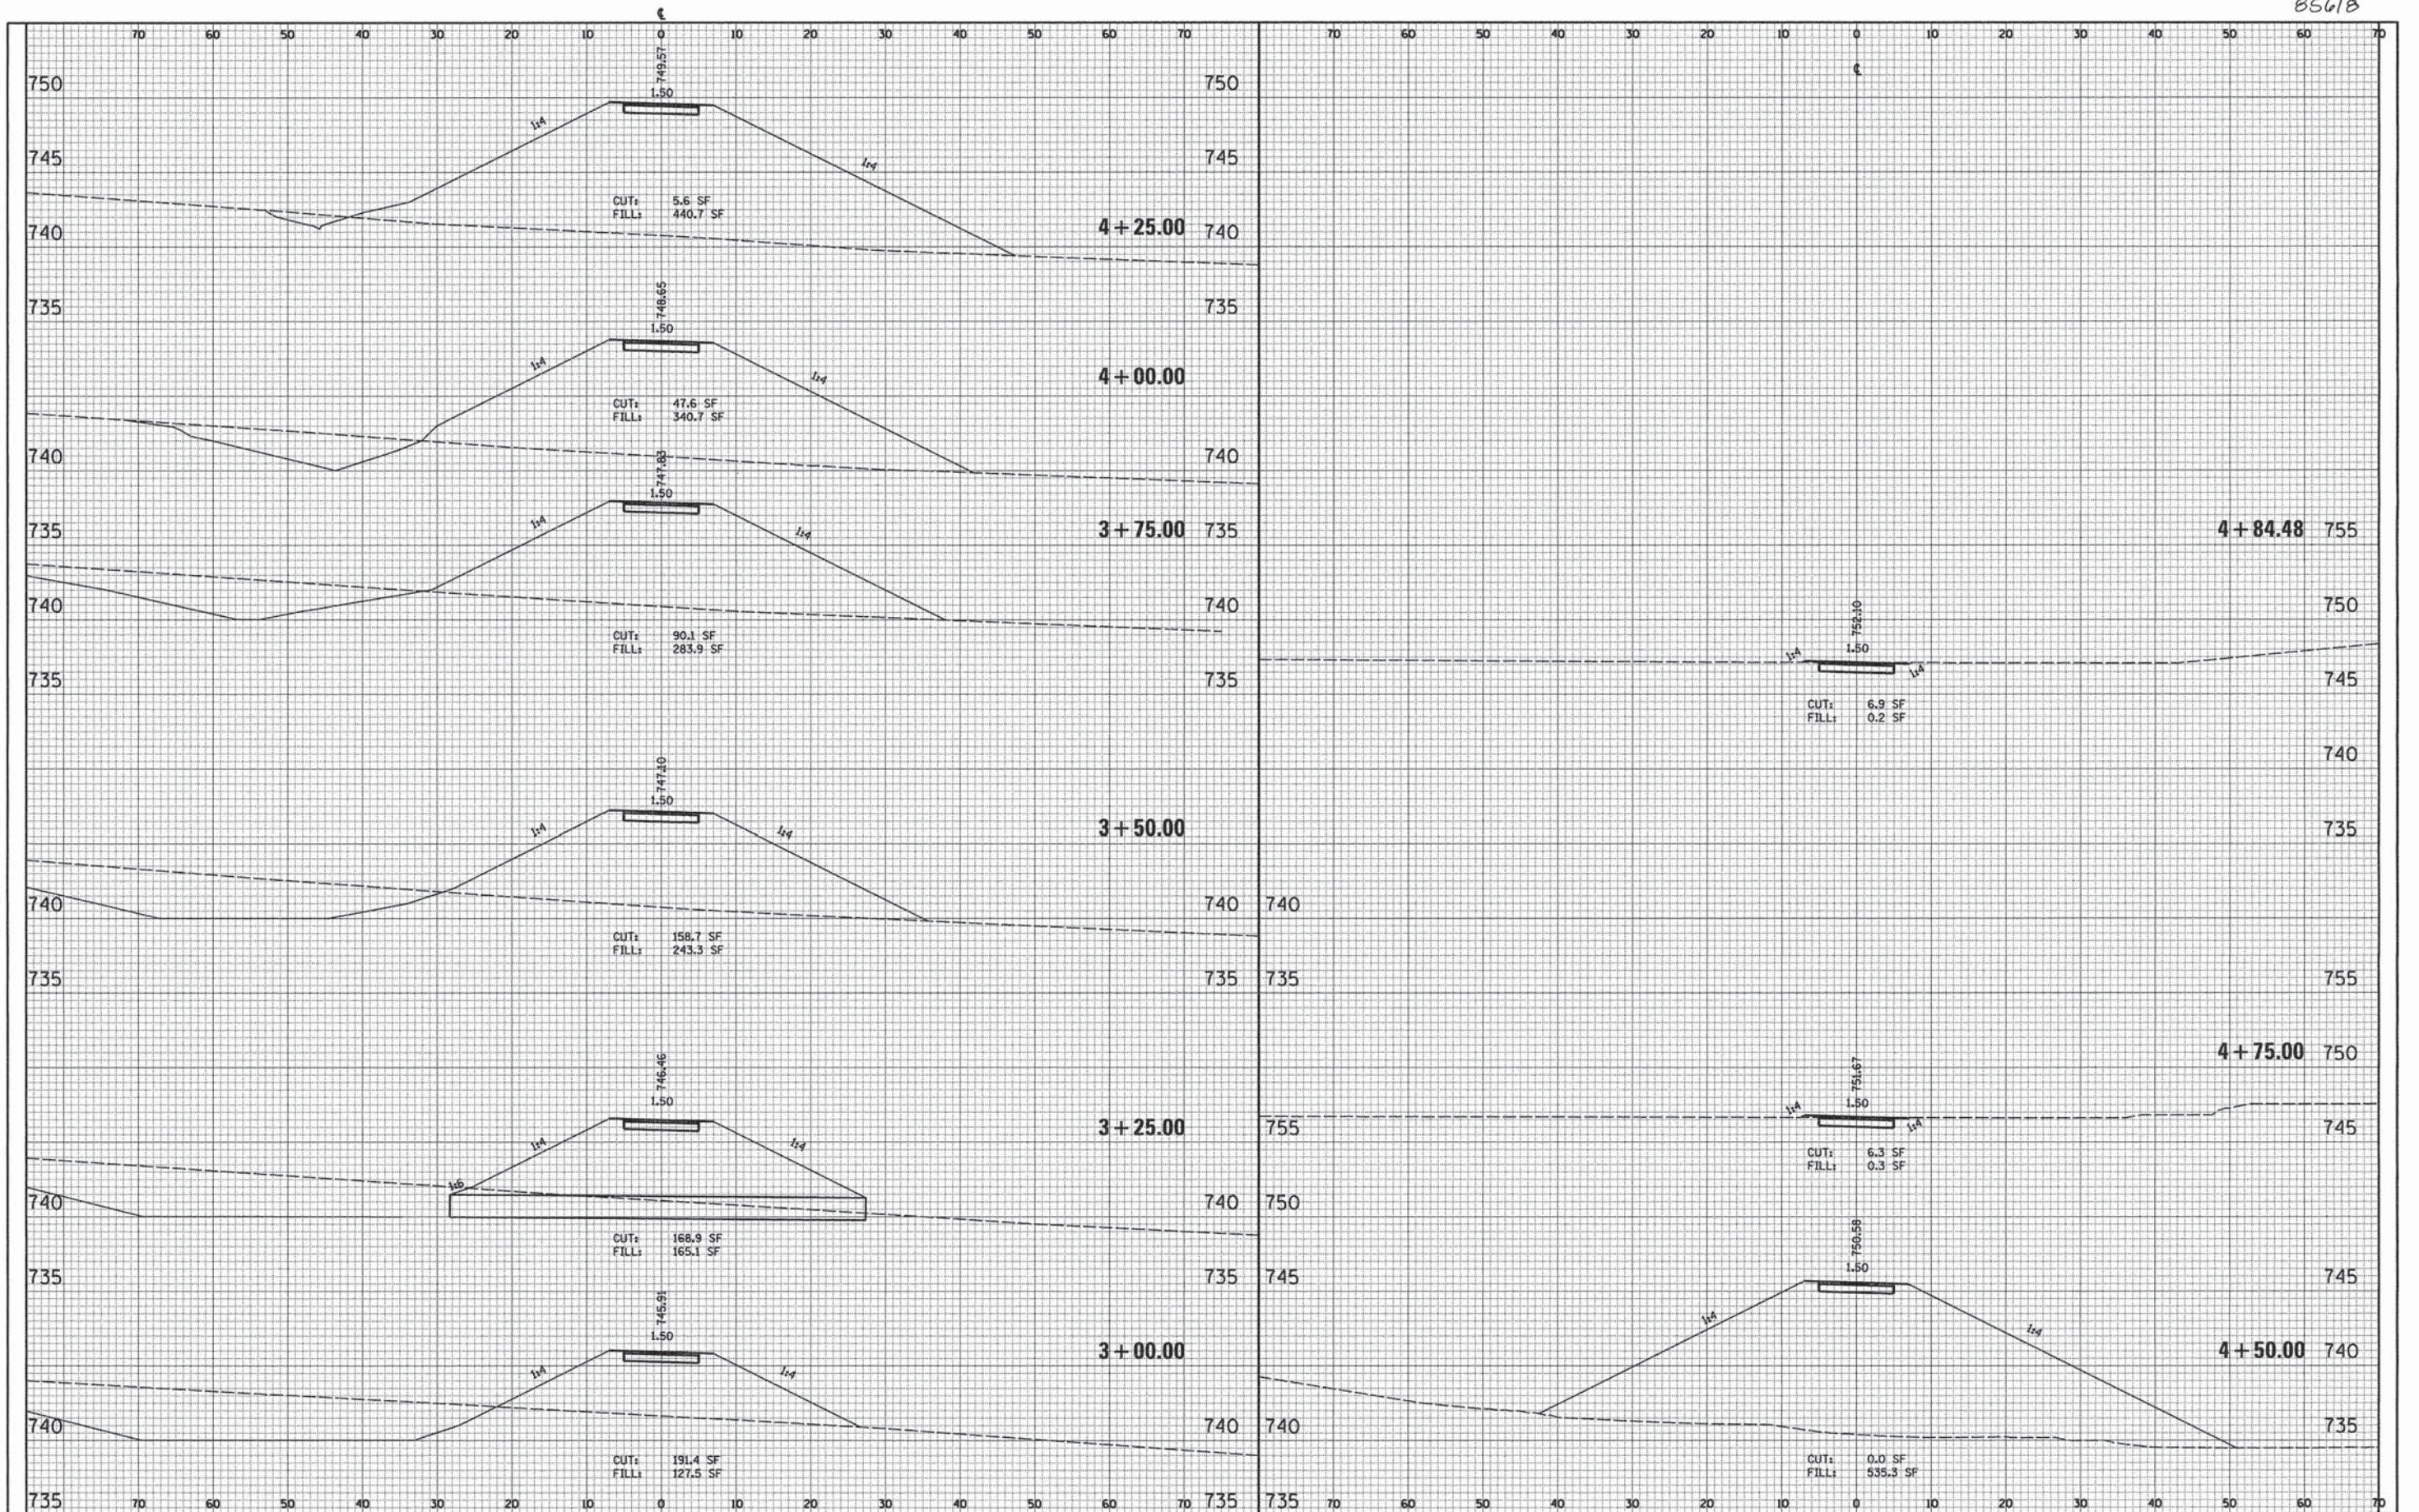

FILE NAME = 14_Sht_Xso.dgn	USER NAME = estone	DESIGNED -	REVISED -	CREEKSIDE PARK SHARED-USE PATH VILLAGE OF PECATONICA	CROSS SECTIONS SHARED-USE PATH	SCALE: SHEET 2 OF 3 SHEETS STA. 2+75.00 TO STA. 4+50.00	F.A. RTE. SECTION 14-P4000-00-SW COUNTY WINNEBAGO TOTAL SHEETS 15 SHEET NO. 10 CONTRACT NO. ILLINOIS FED. AID PROJECT
#MODELNAME#	PLOT SCALE = 10.0000" = 1'	DRAWN -	REVISED -				
	PLOT DATE = 7/17/2015	CHECKED -	REVISED -				
		DATE -	REVISED -				

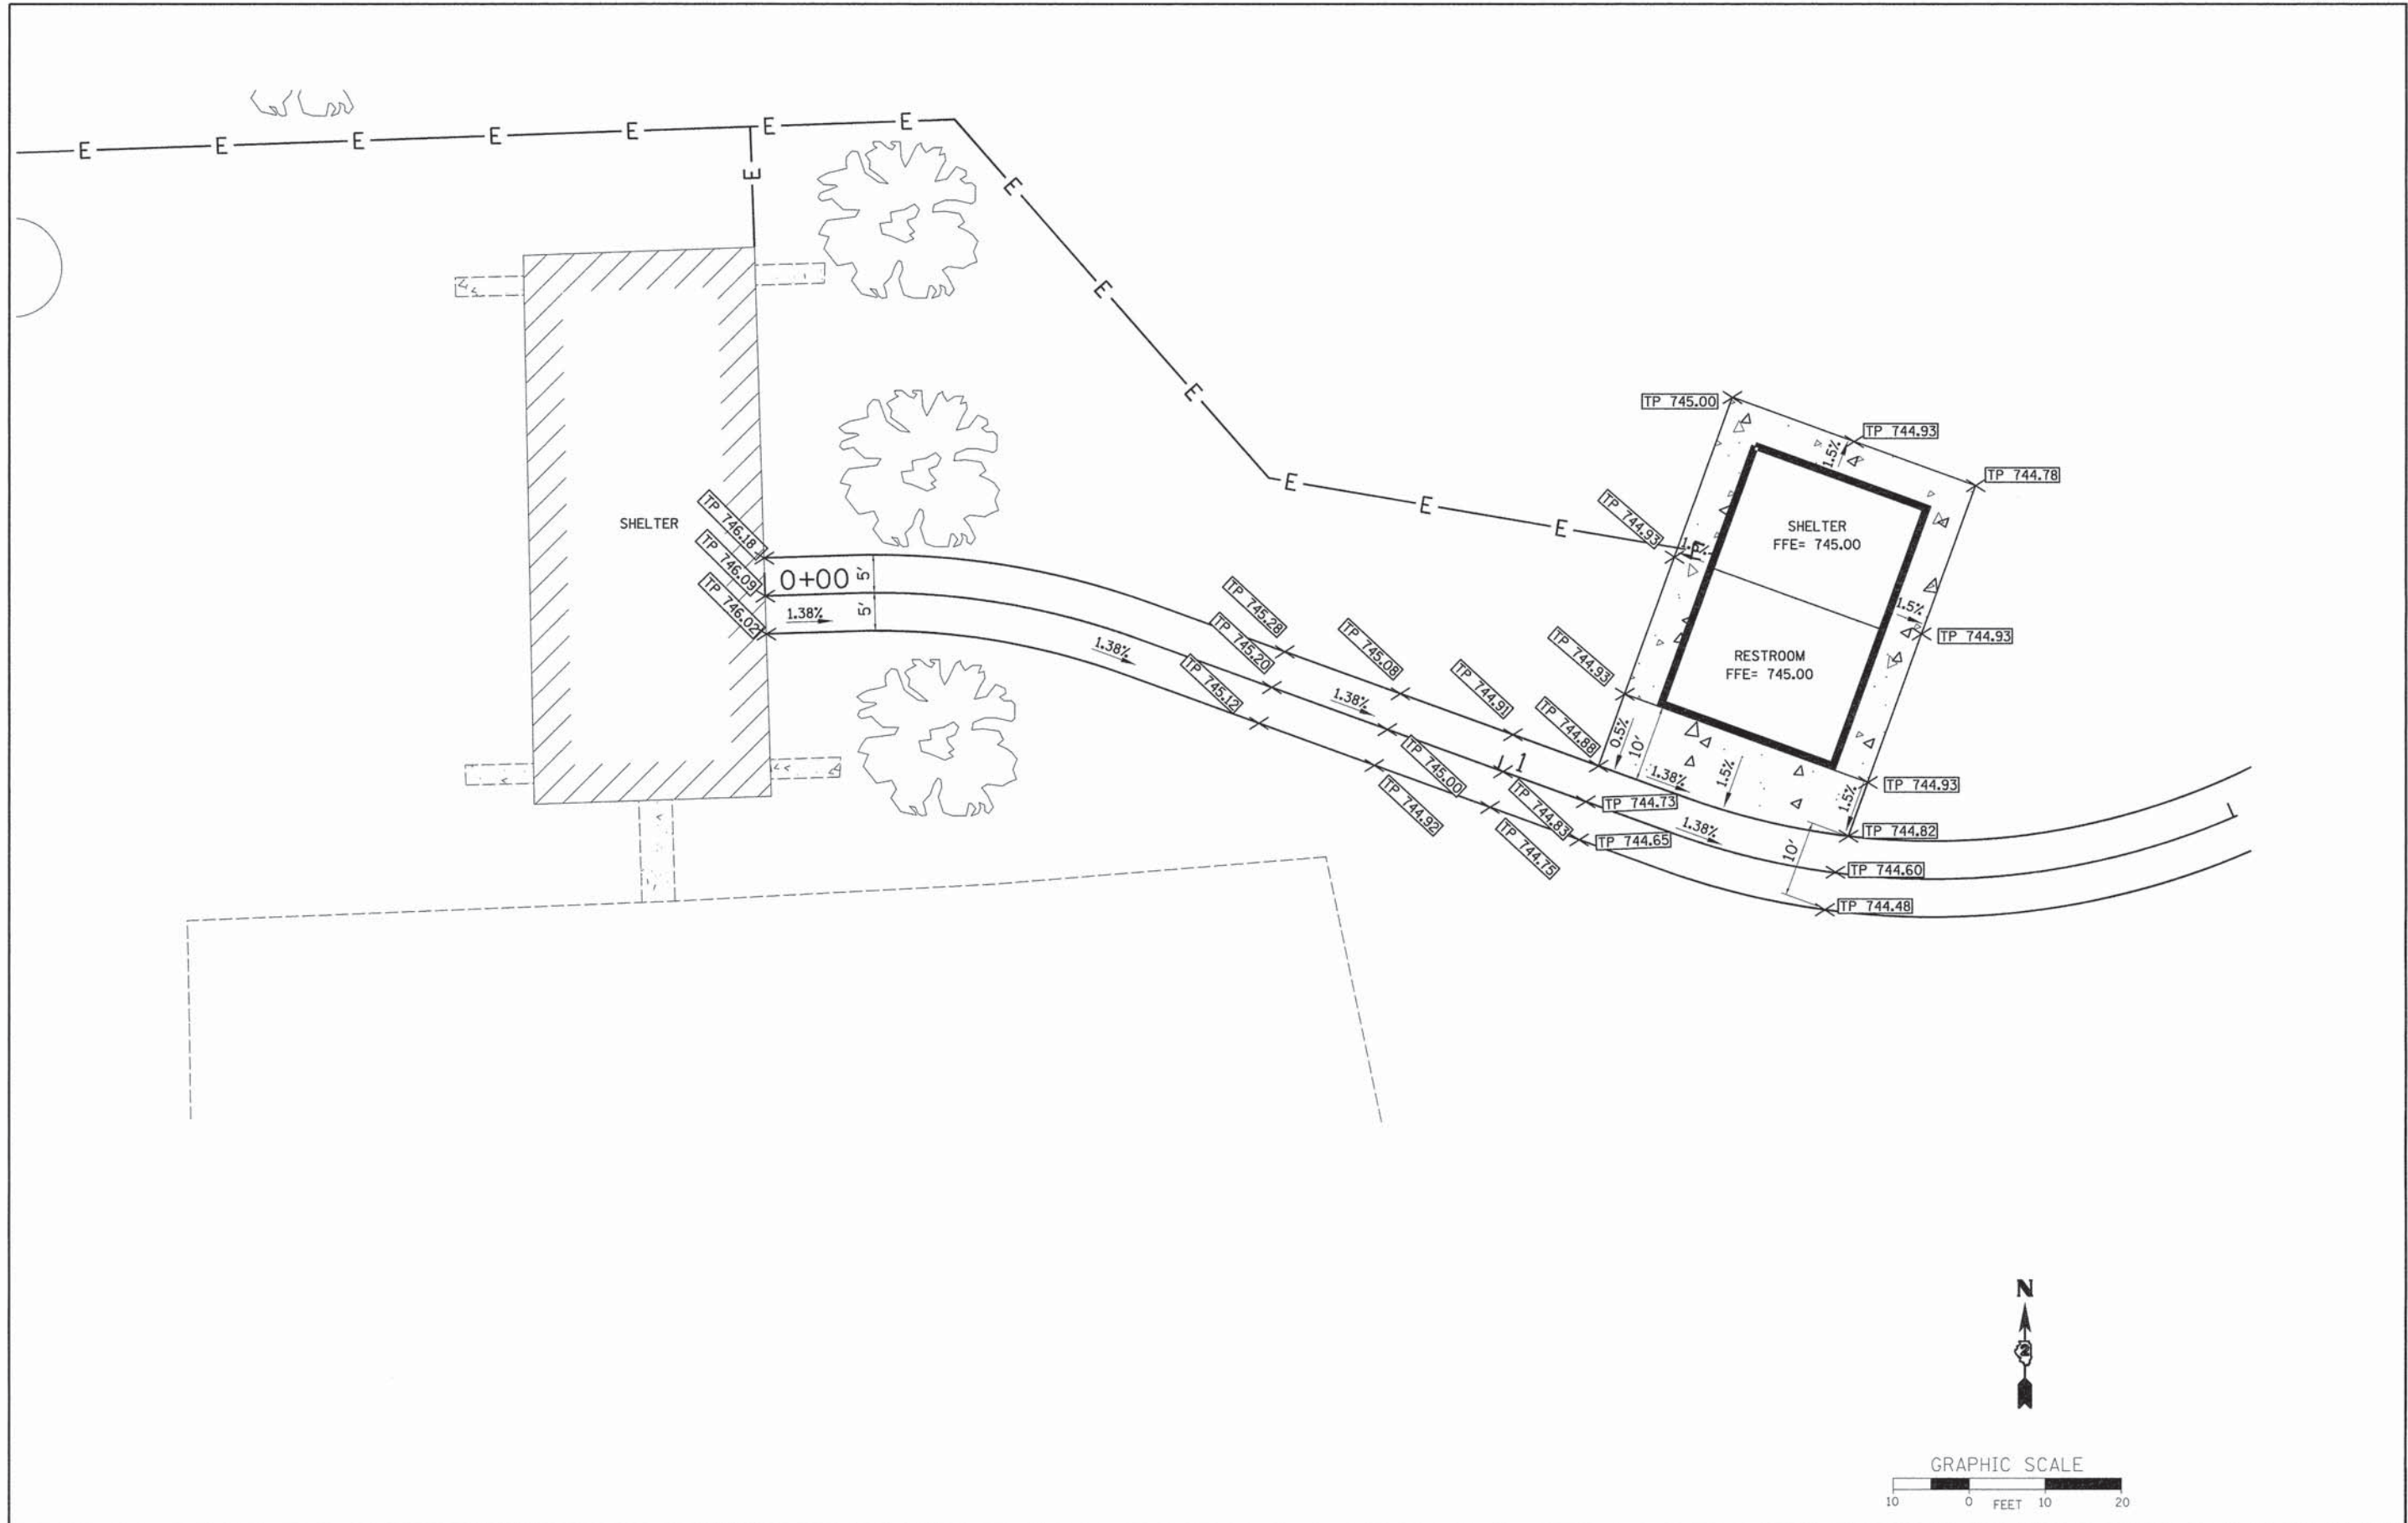


 CHASTAIN & ASSOCIATES LLC CONSULTING ENGINEERS	USER NAME = astone	DESIGNED -	REVISED -	CREEKSIDE PARK SHARED-USE PATH VILLAGE OF PECATONICA	RAMP DETAILS				F.A. RTE.	SECTION	COUNTY	TOTAL SHEETS	SHEET NO.
	PLOT SCALE = 10,000' / 1"	DRAWN -	REVISED -							14-P4000-00-SW	WINNEBAGO	15	11
	PLOT DATE = 7/17/2015	CHECKED -	REVISED -		CONTRACT NO.								
		DATE -	REVISED -		ILLINOIS FED. AID PROJECT								
					1"=10'	SHEET 6 OF SHEETS	STA. 0+00 TO STA. 2+00						

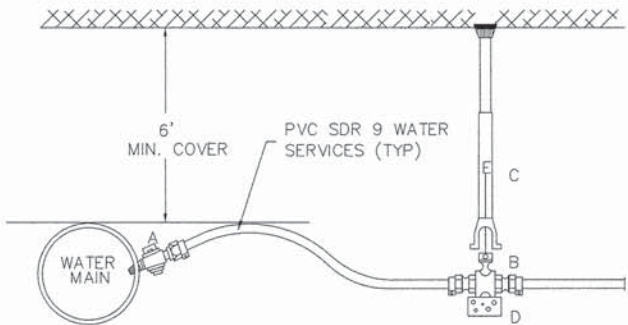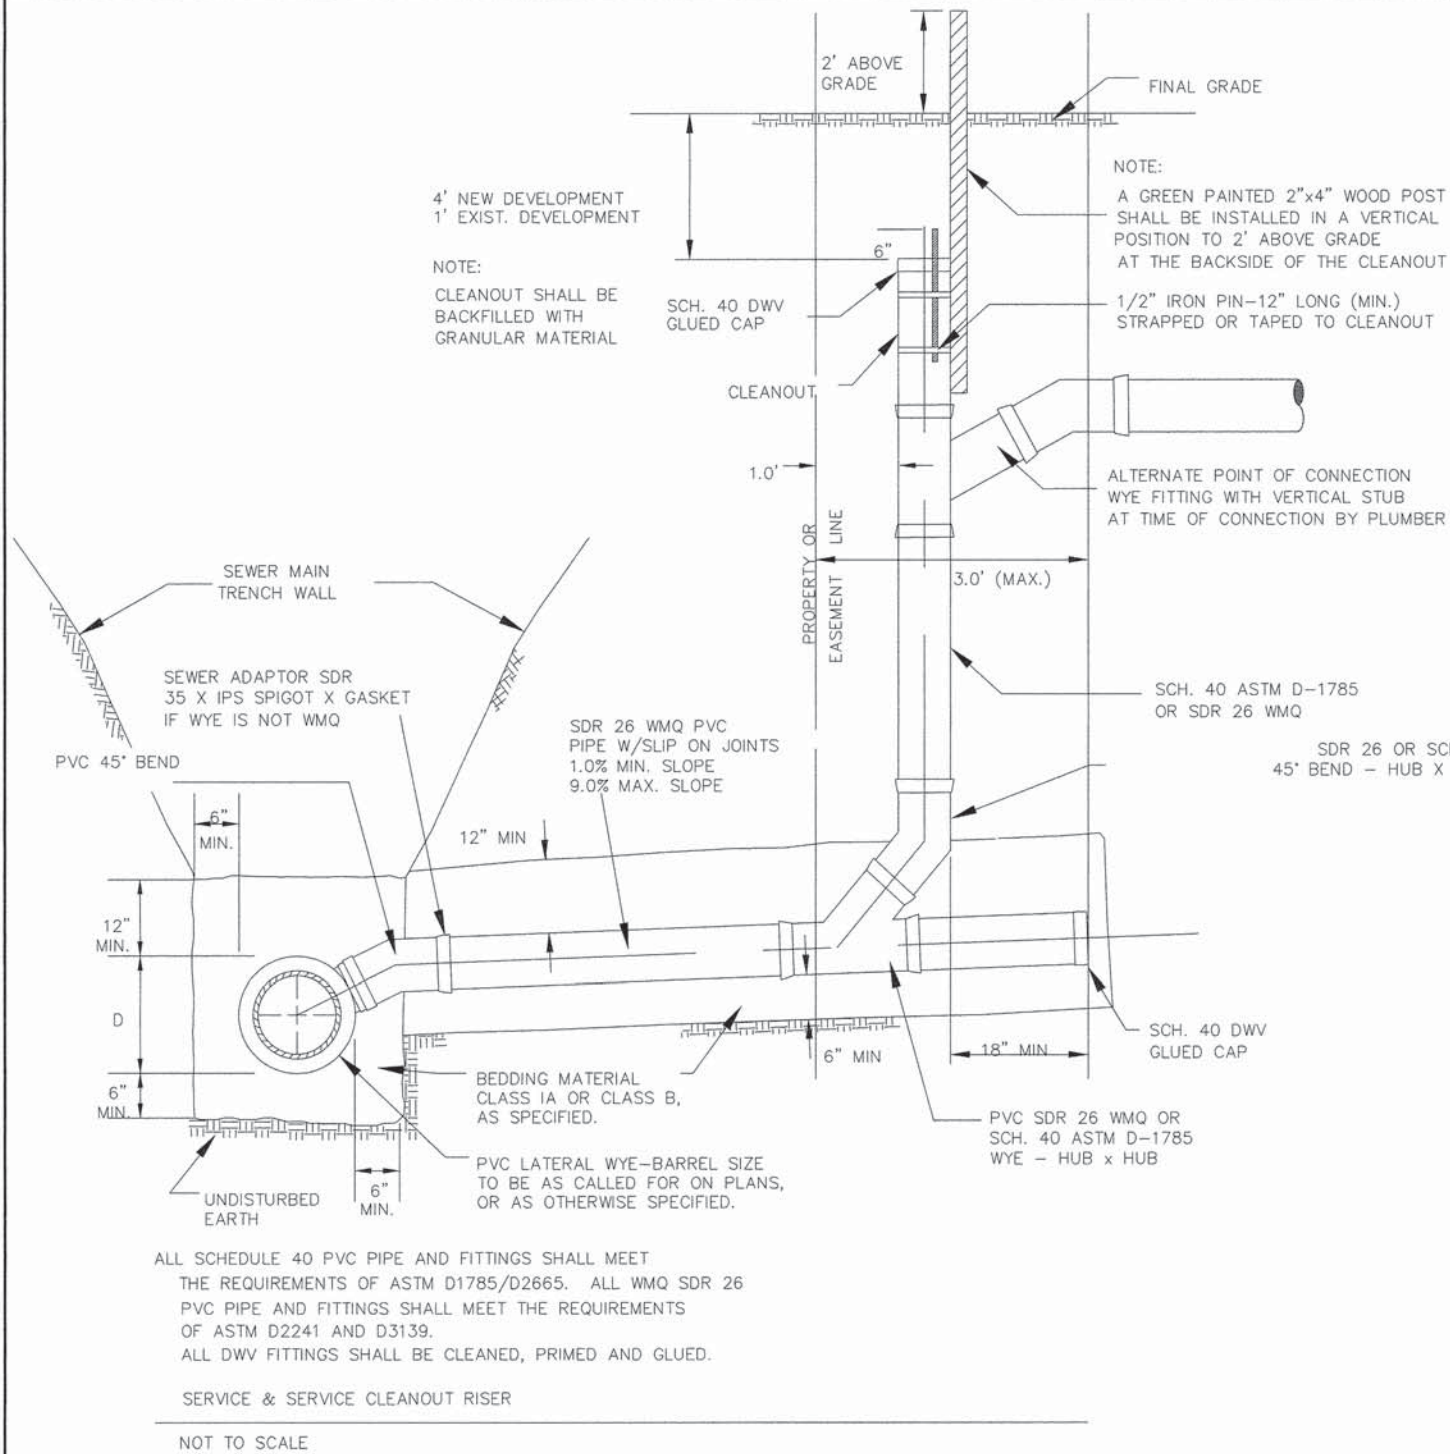


	ITEM	SIZE
A	CORB STOP	1"
B	CURB STOP	1"
C	CURB BOX	EXTEND.
D	THRUST BLOCK	16x8x6"
E	ROD	3/8"

DOMESTIC WATER SERVICE CONNECTION AND SERVICE BOX
NOT TO SCALE

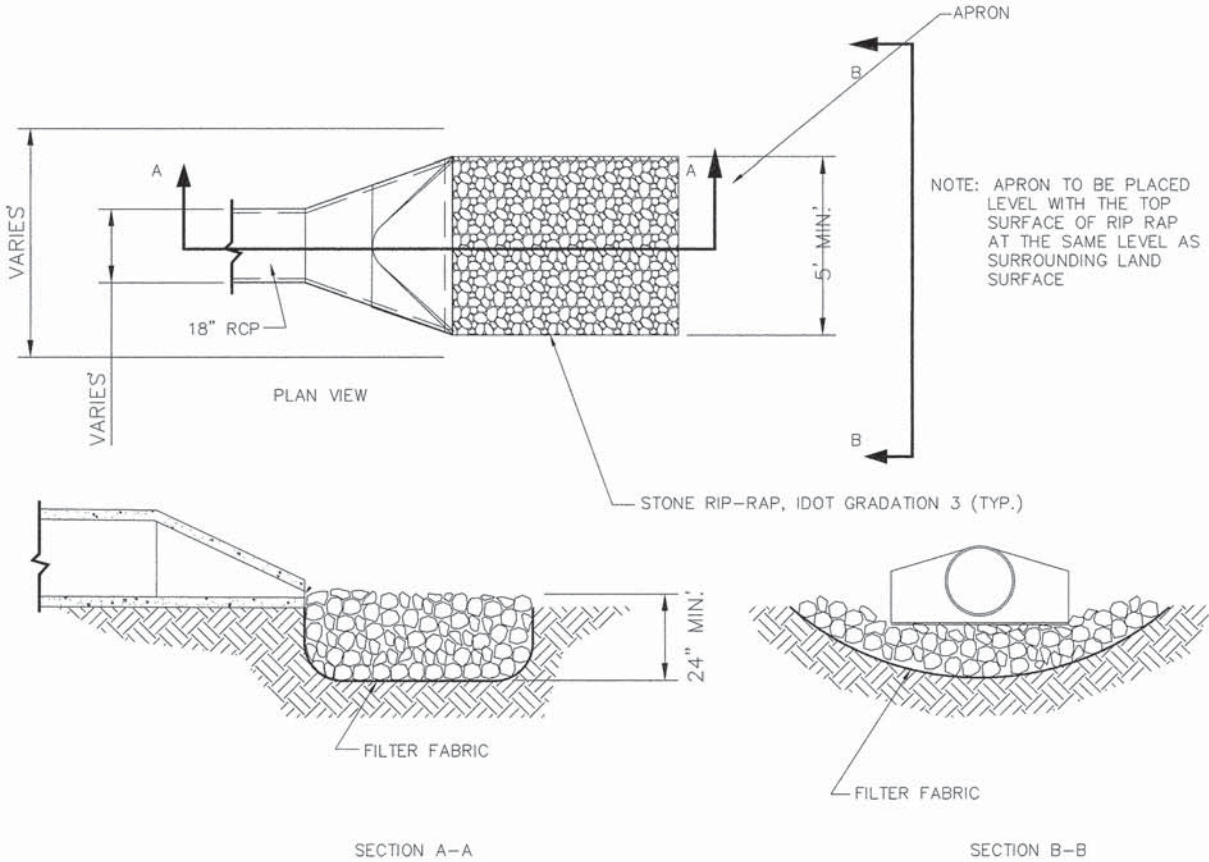


OUTLET STABILIZATION
NOT TO SCALE

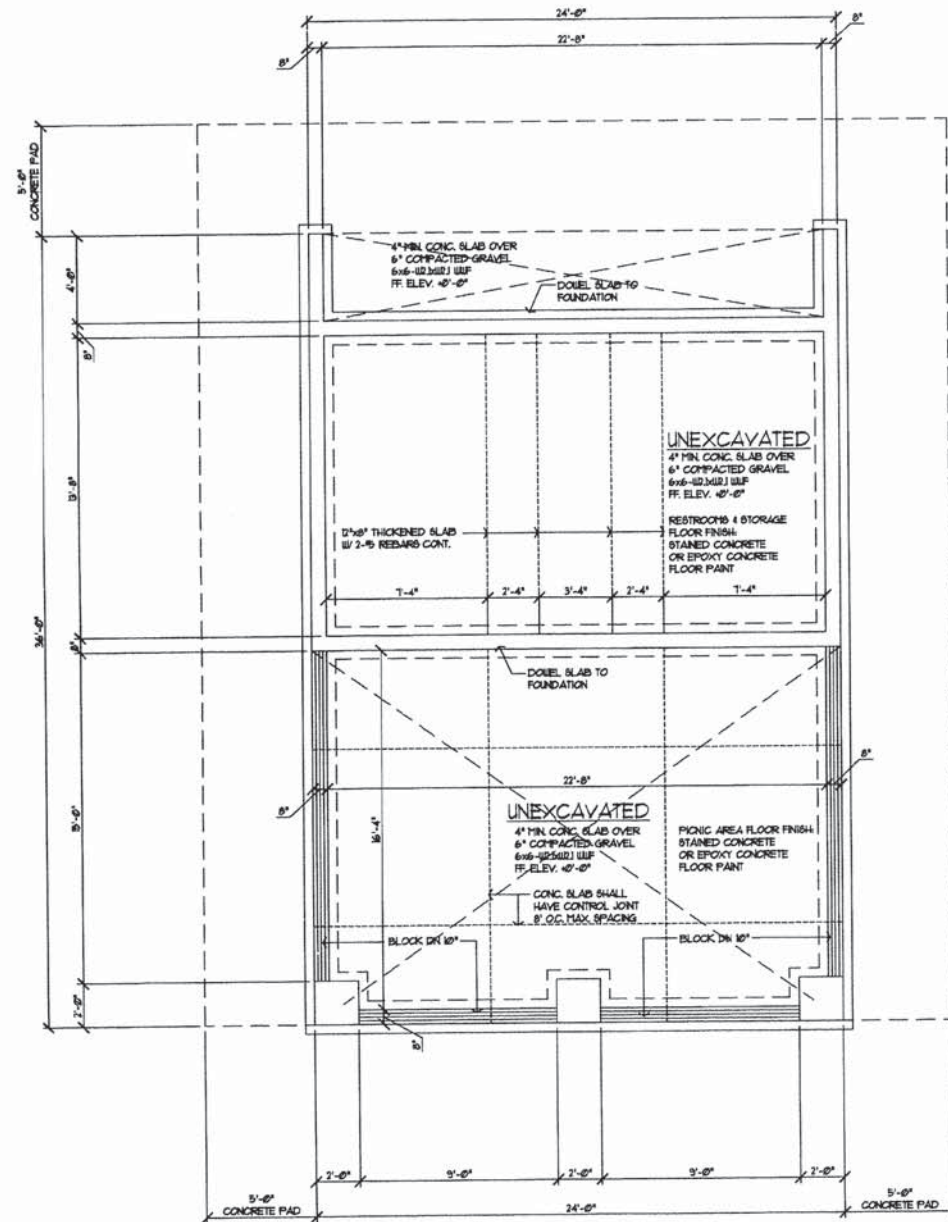

FOUNDATION PLAN

SCALE: 1/4"=1'-0"

ELECTRICAL LEGEND			
	14'x14' RECESSED FLUORESCENT LIGHT TROFFER WITH WIRE GUARD		EXHAUST FAN
	14'x14' RECESSED FLUORESCENT LIGHT TROFFER WITH WIRE GUARD & DUSK TO DAWN SENSOR		CEILING MOUNTED LIGHT MOTION SENSOR
	CEILING MOUNTED LIGHT		5' 4" UP DUPLEX OUTLET
	RECESSED CAN LIGHT		EMERGENCY LIGHTING
			ELECTRICAL PANEL

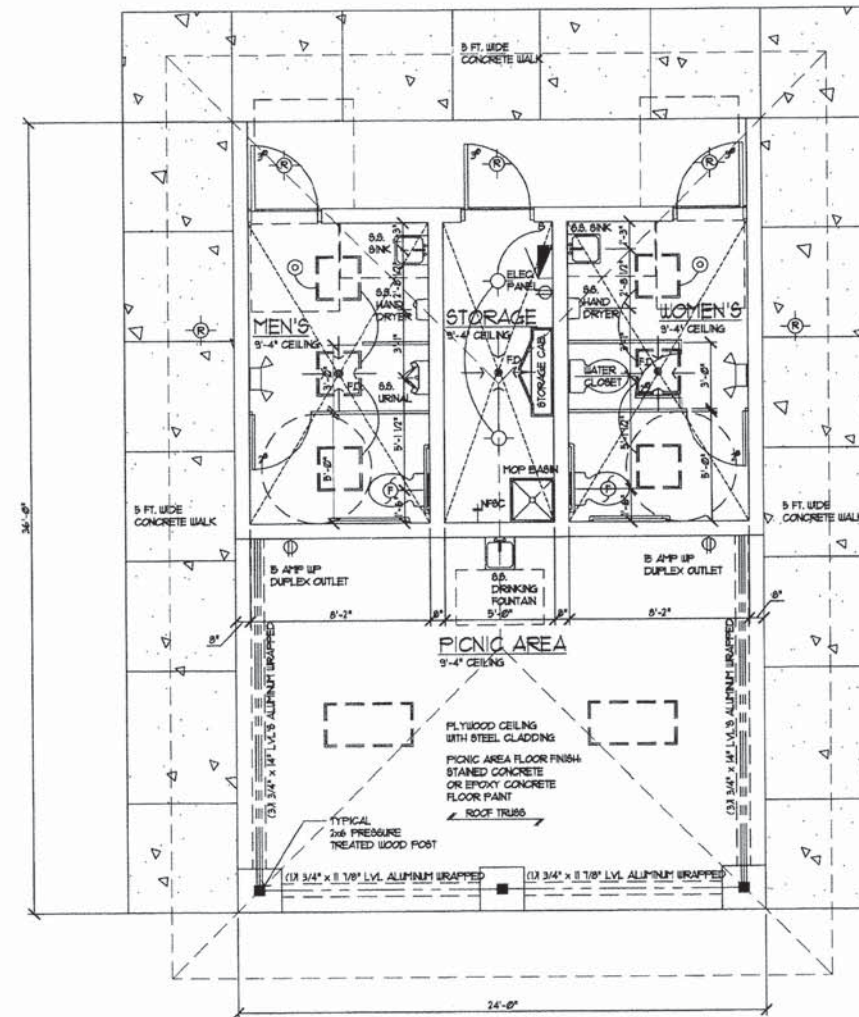

FLOOR PLAN

SCALE: 1/4"=1'-0"

864 SQ. FT.

NOTE: RESTROOM FACILITY TO BE USED FOR FUTURE INSTALLATION OF SURVEILLANCE CAMERAS AT BOTH DOORWAYS AND PICNIC AREA. STORAGE ALSO TO BE USED FOR FUTURE EQUIPMENT.

NOTE: RESTROOM FACILITY TO HAVE AN UNDERGROUND SHUT-OFF VALVE AND/OR MEANS TO DRAIN THE LINES OF THE ENTIRE BUILDING DURING WINTER MONTHS.

CODES:	
ALL MATERIALS AND WORKMANSHIP SHALL CONFORM TO THE FOLLOWING CODES:	
NEC 2008 NATIONAL ELECTRICAL CODE & AMENDMENTS	
IRC 2006 INTL. RESIDENTIAL CODE & AMENDMENTS	
IBC 2006 INTL. BUILDING CODE & AMENDMENTS	
IFC 2006 INTL. FIRE CODE & AMENDMENTS	
IMC 2006 INTL. MECHANICAL CODE & AMENDMENTS	
IECC 2006 INTL. ENERGY CONSERVATION CODE	
IFGC 2006 INTL. FIRE GAS CODE	
IEBC 2006 INTL. EXISTING BUILDING CODE	
NFPA 101 2003 LIFE SAFETY CODE	
UPH 2004 ILLINOIS PLUMBING CODE & AMENDMENTS	
ILLINOIS ACCESSIBILITY CODE	

CHASTAIN & ASSOCIATES LLC
CONSULTING ENGINEERS


USER NAME = \$USER\$	DESIGNED = _____	REVISED = _____
PLOT SCALE = \$SCALE\$	DRAWN = _____	REVISED = _____
PLOT DATE = \$DATE\$	CHECKED = _____	REVISED = _____
	CATE = _____	REVISED = _____

CREEKSIDE PARK SHARED-USE PATH
VILLAGE OF PECATONICA

BARCHITECTURE
ARCHITECTS


Handwritten signature and date: 6/1/15

SCALE: _____	SHEET _____ OF _____ SHEETS	STA. _____ TO STA. _____	F.A. RTE. _____	SECTION 14-P4000-00-SW	COUNTY _____	TOTAL SHEET NO. 15	SHEET NO. 13	CONTRACT NO. 85618	ILLINOIS FED. RD. PROJECT
--------------	-----------------------------	--------------------------	-----------------	------------------------	--------------	--------------------	--------------	--------------------	---------------------------

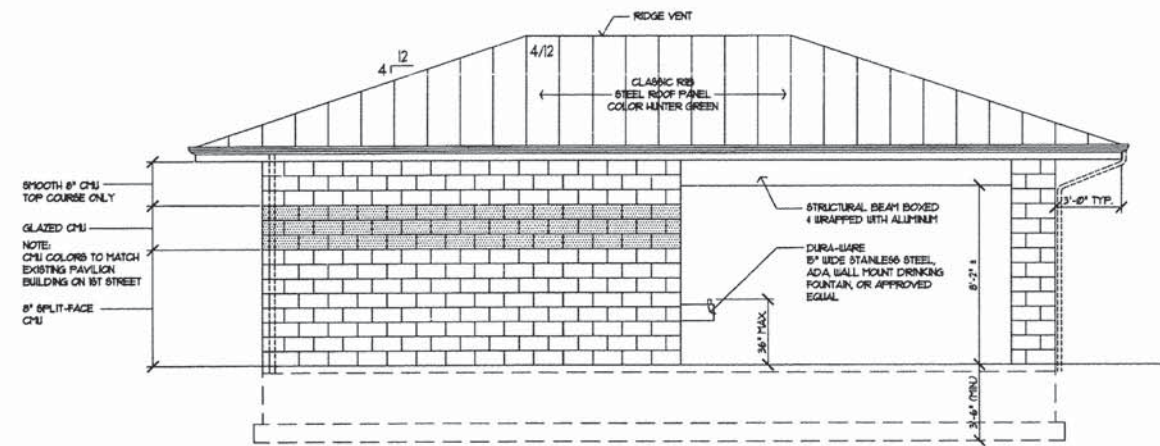


LEFT SIDE ELEVATION

SCALE: 1/4"=1'-0"

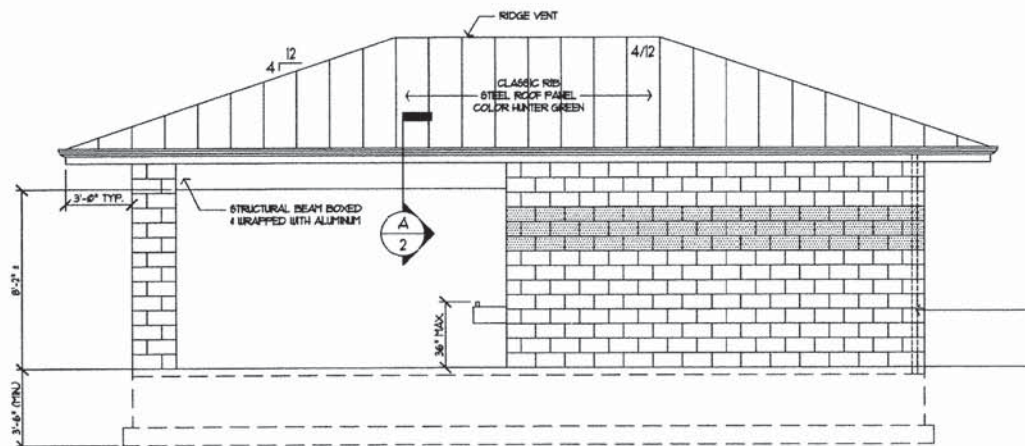


RIGHT SIDE ELEVATION

SCALE: 1/4"=1'-0"

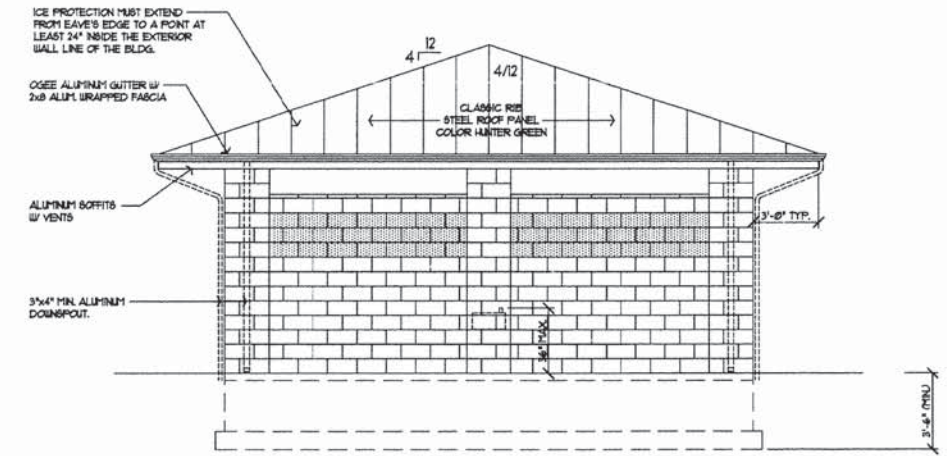

FRONT ELEVATION

SCALE: 1/4"=1'-0"

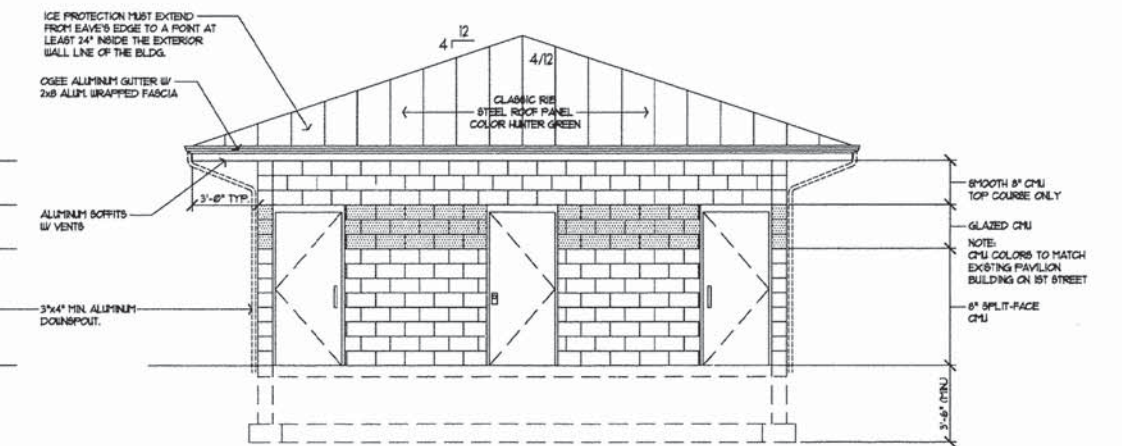


REAR ELEVATION

SCALE: 1/4"=1'-0"


ROOF VENTS (PER SECTION R-006 IN 2006 IRC)			
ATTIC AREA	SQ. FT. OF VENT REQ'D. (1/3000)	VENT SUPPLIED	
	2.88 SQ. FT.	ROOF VENTS (# 6/8" sq. ft.)	EAVE VENTS (# 6/8" sq. ft.)
864 SQ. FT.	353 SQ. FT.	3 VENTS	10 VENTS

ROOF NOTES:
 -ALL RIDGE, HIP, AND VALLEY MEMBERS SHALL BE THICK ENOUGH TO ACCEPT FULL BEARING FROM RAFTERS.
 -ALL LINE VALLEYS OVER 10'-0" LONG SHALL BE DOUBLED.
 -2X6 COLLAR TIES TO BE INSTALLED @ 4'-0" O.C. AT A MIN. OF 1/3 OF THE HEIGHT DOWN FROM THE RIDGE.

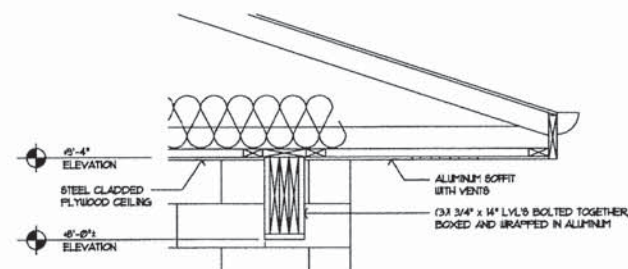

SECTION DETAIL-A

SCALE: 3/4"=1'-0"

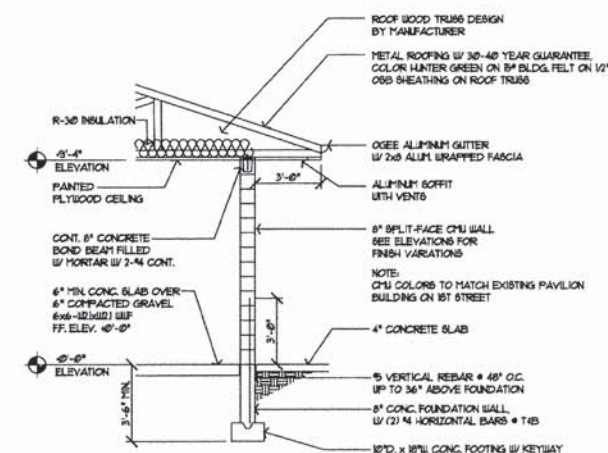

WALL SECTION

SCALE: 1/4"=1'-0"

CHASTAIN & ASSOCIATES LLC
 CONSULTING ENGINEERS

USER NAME = \$USER\$	DESIGNED =	REvised =
PLOT SCALE = \$SCALE\$	DRAWN =	REvised =
PLOT DATE = \$DATE\$	CHECKED =	REvised =
	DATE =	REvised =


CREEKSIDE PARK SHARED-USE PATH
 VILLAGE OF PECATONICA

JB ARCHITECTURE
 1000 W. 12th St.
 Peoria, IL 61614
 (312) 244-1111

Adrian G. Miller

F.A. RTE.	SECTION	COUNTY	TOTAL SHEETS	SHEET NO.
	14-P4000-00-SW		15	14
CONTRACT NO. 85618				
ILLINOIS FED. AID PROJECT				


SCALE: SHEET OF SHEETS STA. TO STA.

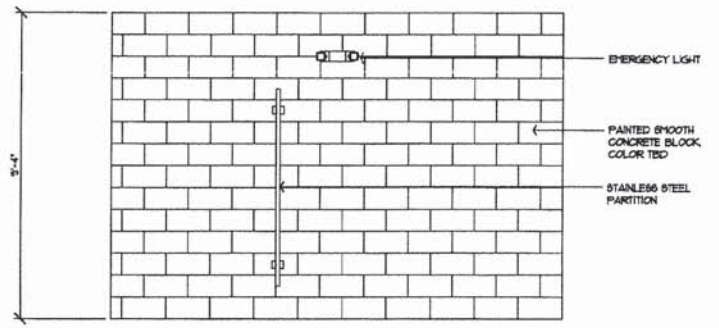

MEN'S ELEVATION-A

SCALE: 3/8"=1'-0"


NOTE:
EACH DOOR SHALL CONTAIN LOOKABLE
ENTRANCE HANDLE WITH DEAD BOLT, WITH
ALL LOCKS AND KEYS MATCHING EXISTING
PARK MAINTENANCE KEY SYSTEM.

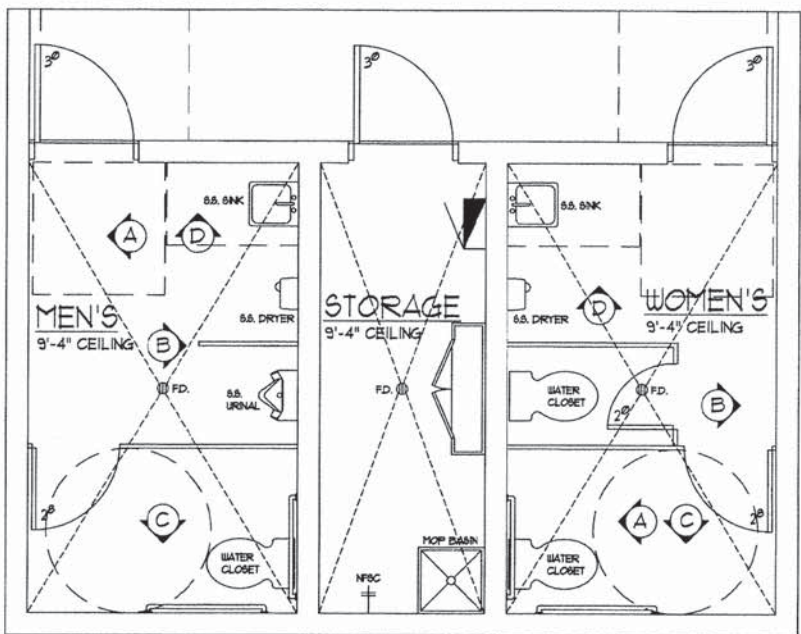

FLOOR PLAN - FOR REFERENCE ONLY


SCALE: 3/8"=1'-0"

864 SQ. FT.

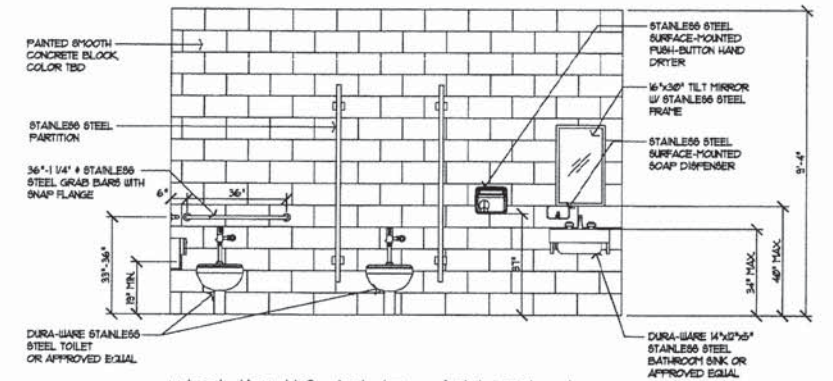


WOMEN'S ELEVATION-A

SCALE: 3/8"=1'-0"

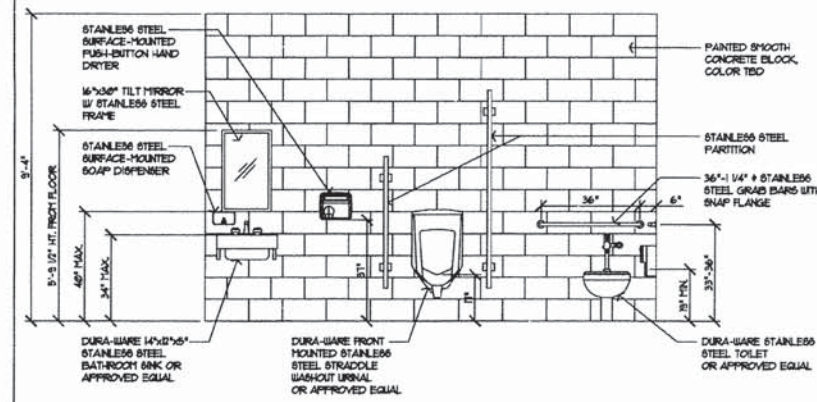


MEN'S ELEVATION-B

SCALE: 3/8"=1'-0"

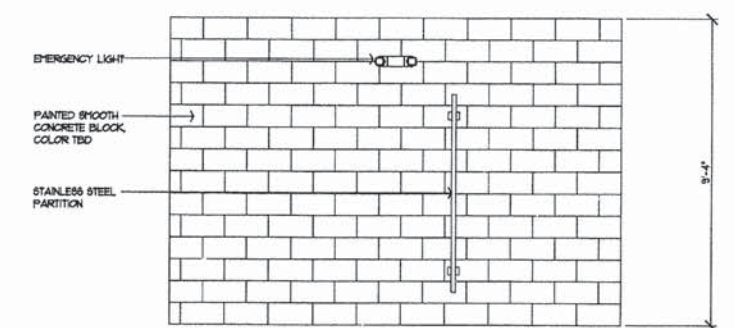


WOMEN'S ELEVATION-B

SCALE: 3/8"=1'-0"

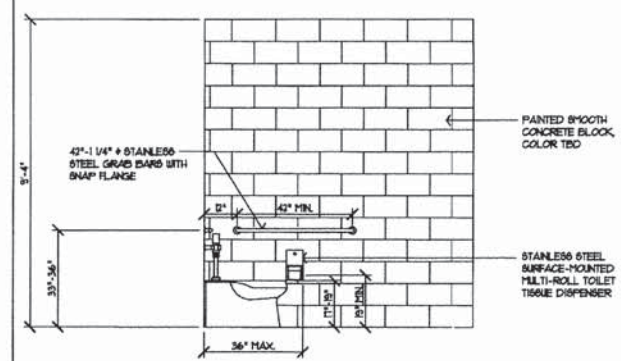


MEN'S ELEVATION-C

SCALE: 3/8"=1'-0"

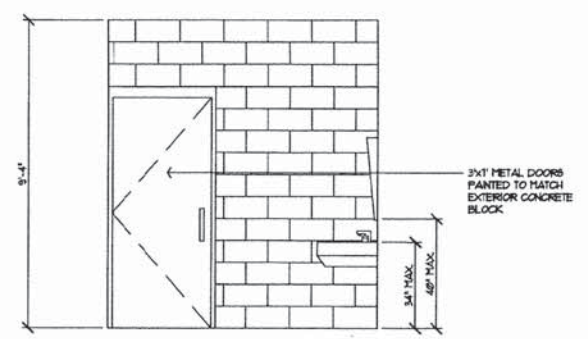


MEN'S ELEVATION-D

SCALE: 3/8"=1'-0"

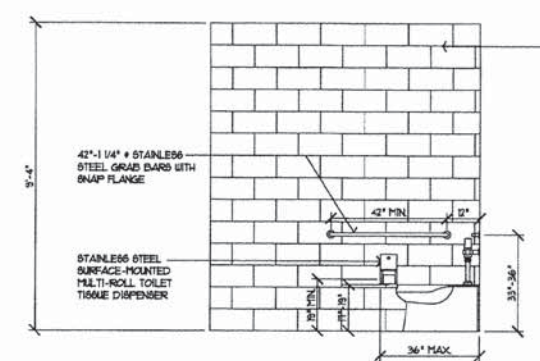

WOMEN'S ELEVATION-C

SCALE: 3/8"=1'-0"

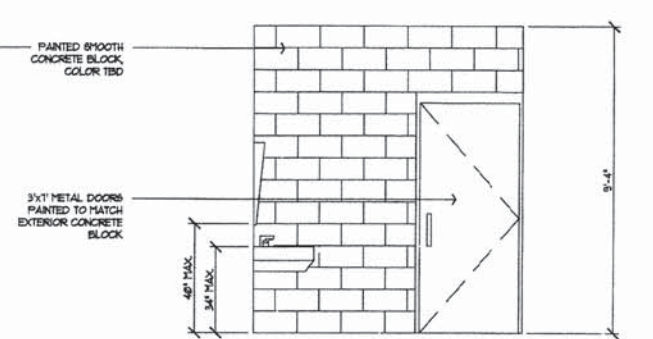

WOMEN'S ELEVATION-D

SCALE: 3/8"=1'-0"