 



**STAGE 2
SUGGESTED SEQUENCE OF OPERATIONS**



1. TRAFFIC CONTROL WILL BE INSTALLED ACCORDING TO HIGHWAY STANDARD 701306 FOR RESURFACING OPERATIONS. NO OVERNIGHT LANE CLOSURES WILL BE ALLOWED.
2. MOVE TRAFFIC TO RUNAROUND AND CONSTRUCT THE PROPOSED PAVEMENT FROM STATION 83+50 TO STATION 87+00.

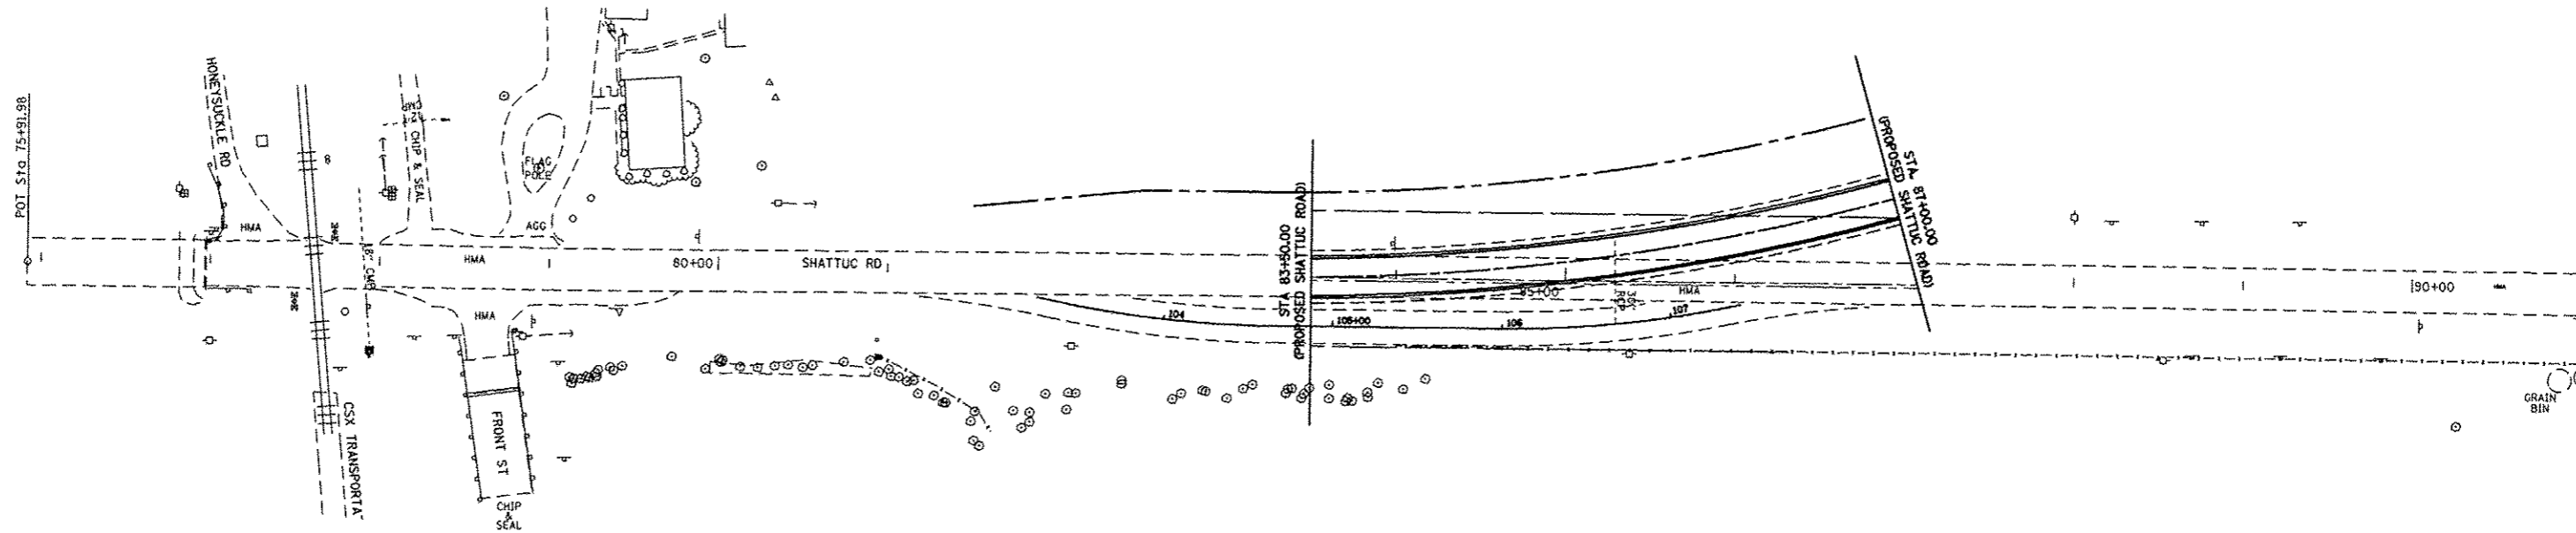

FILE NAME =	USER NAME = bergmd	DESIGNED -	REVISED -	STATE OF ILLINOIS DEPARTMENT OF TRANSPORTATION	SHATTUC ROAD REALIGNMENT STAGE 2 CONSTRUCTION	F.A.P. RTE.	SECTION	COUNTY	TOTAL SHEETS	SHEET NO.	
ci:\pwork\pwidot\bergmd\d0309875\0876053-sh2-staging2.dgn		DRAWN -	REVISED -			327	21-1-1, 27-1	CLINTON	96	20	
PLOT SCALE = 100.0000 / in.		CHECKED -	REVISED -			CONTRACT NO. 76D53					
PLOT DATE = 6/15/2012		DATE -	REVISED -			ILLINOIS FED. AID PROJECT					