 



STAGE 4
SUGGESTED SEQUENCE OF OPERATIONS

1. REMOVE REMAINING EXISTING SHATTUC RD PAVEMENT BETWEEN NEW SHATTUC ROAD ALIGNMENT AND SERVICE ROAD.
2. REMOVE THE RUNAROUND AND THE TEMPORARY, CULVERT, CATCH BASIN, AND FRAME AND GRATE.

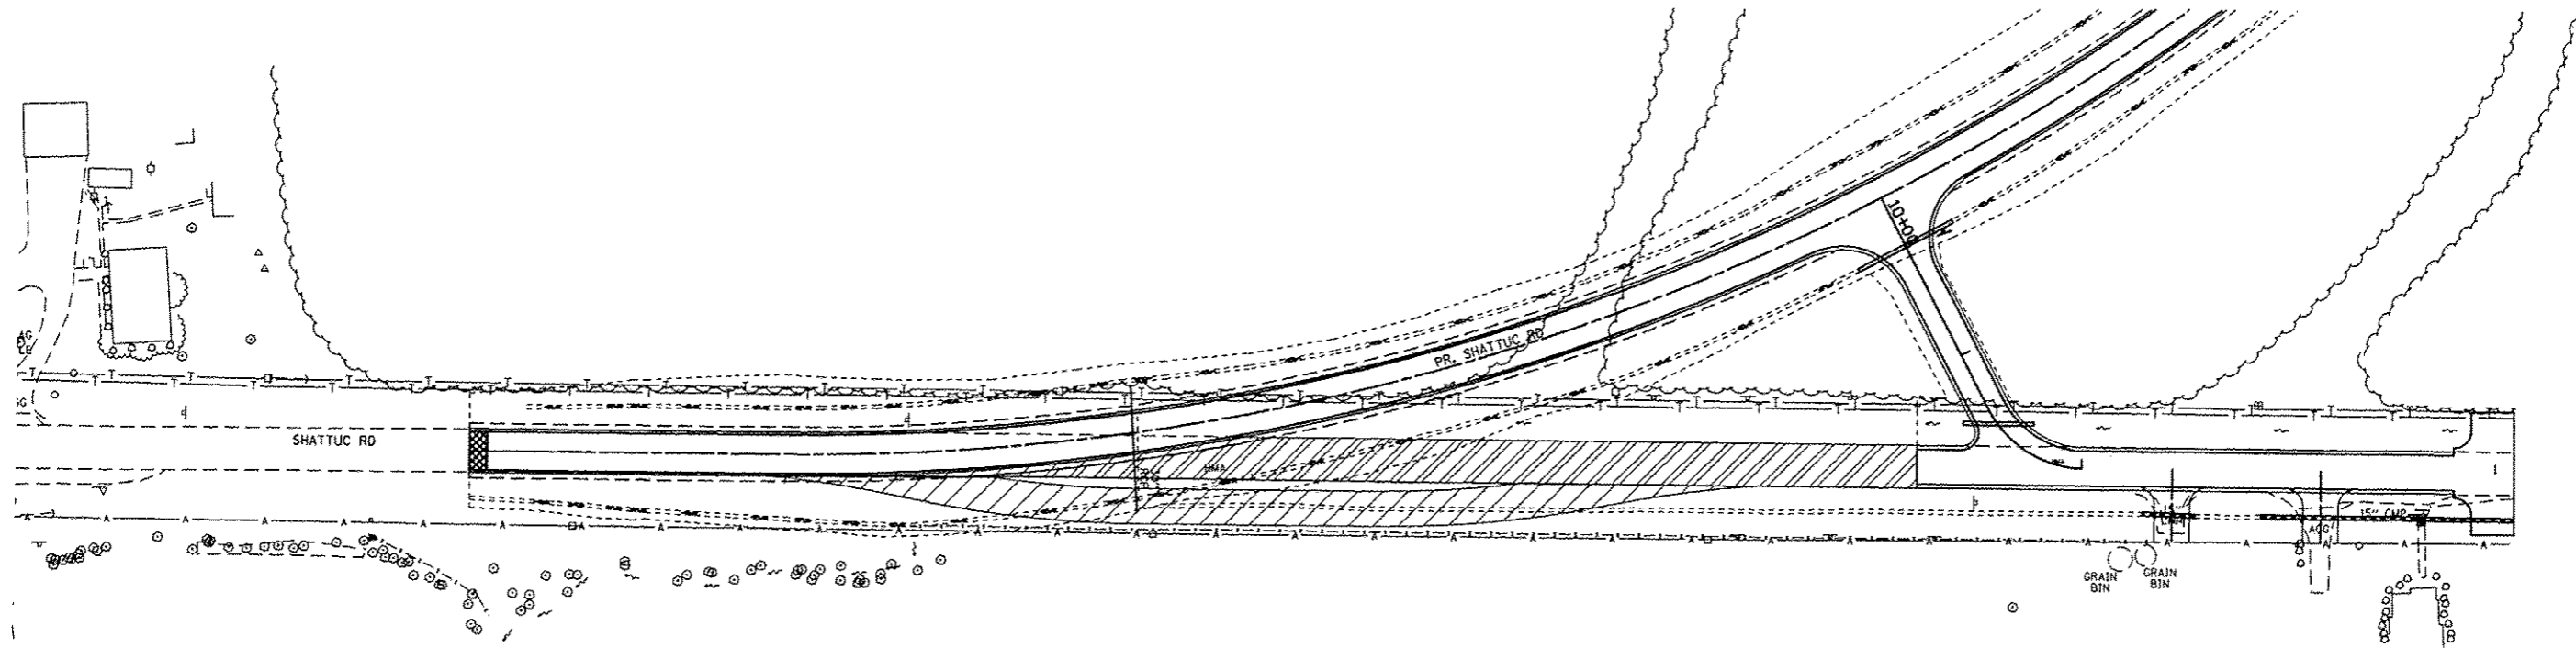

FILE NAME =	USER NAME = bergnd	DESIGNED -	REVISED -	STATE OF ILLINOIS DEPARTMENT OF TRANSPORTATION	SHATTUC ROAD REALIGNMENT STAGE 3 CONSTRUCTION	F.A.P. RTE.	SECTION	COUNTY	TOTAL SHEETS	SHEET NO.
c:\pwwork\pwwork\bergnd\d0309075\08760	53-ah1-staging3.dgn	DRAWN -	REVISED -			327	21-I-1, 27-I	CLINTON	96	22
	PLOT SCALE = 100.0000 / in.	CHECKED -	REVISED -			CONTRACT NO. 76053				
	PLOT DATE = 6/15/2012	DATE -	REVISED -			ILLINOIS FED. AID PROJECT				
					SCALE: _____	SHEET NO. 4 OF 4 SHEETS		STA. _____ TO STA. _____		