

ALL KEYED NOTES APPLY TO THIS SHEET ONLY.

KEYED NOTES:


1. PORTLAND CEMENT CONCRETE 81400100 - HANDHOLE IDOT STANDARD 814001-02. GROUND HANDHOLE PER IDOT STANDARD 873001-02.
2. 2" CONDUIT, 2*6 AND 1*6 GND FOR CIRCUIT LC5-2 AND 2*6 AND 1*6 GND FOR CIRCUIT LC5-4.
3. 2" CONDUIT, 2*6 AND 1*6 GND FOR CIRCUIT LC5-4.
4. 2" CONDUIT, 2*6 AND 1*6 GND FOR CIRCUIT LC5-5.
5. LIGHTING CONTROLLER, BASE MOUNTED, 240V, 200 AMP, *LC5.
6. 2" CONDUIT, 2*6 AND 1*6 GND FOR CIRCUIT LC5-1.
7. 2" CONDUIT, 2*6 AND 1*6 GND FOR CIRCUIT LC5-2.
8. 2" CONDUIT, 2*6 AND 1*6 GND FOR CIRCUIT LC5-6.
9. 2" CONDUIT, 2*6 AND 1*6 GND FOR CIRCUIT LC5-3.

KEYED NOTES (CONTINUED):

10. 2" CONDUIT, 2*6 AND 1*6 GND FOR CIRCUIT LC4-1.
11. 2" CONDUIT, 2*6 AND 1*6 GND FOR CIRCUIT LC4-2.
12. 2" CONDUIT, 2*6 AND 1*6 GND FOR CIRCUIT LC5-1 AND 2*6 AND 1*6 GND FOR CIRCUIT LC5-2 AND 2*6 AND 1*6 GND FOR CIRCUIT LC5-4 AND 2*6 AND 1*6 GND FOR CIRCUIT LC5-6.
13. 2" CONDUIT, 2*6 AND 1*6 GND FOR CIRCUIT LC5-2 AND 2*6 AND 1*6 GND FOR CIRCUIT LC5-4 AND 2*6 AND 1*6 GND FOR CIRCUIT LC5-6.

NOTES:

1. STATIONS AND OFFSETS SHOWN ON THIS SHEET ARE TO THE CENTER OF HANDHOLE AND LIGHT POLE FOUNDATIONS.
2. COORDINATE INSTALLATION OF UNDERGROUND CONDUIT AND LIGHT FIXTURES WITH ALL EXISTING UNDERGROUND SYSTEMS AND PROPOSED LANDSCAPE FEATURES AND PLANTINGS.
3. SEE IRRIGATION PLANS FOR UNDERGROUND CONDUIT AND PIPING. COORDINATE INSTALLATION OF UNDERGROUND FACILITIES.
4. UTILITY SERVICE FROM AMEREN TO LC5 IS CURRENTLY BEING REVIEWED BY AMEREN AND WILL BE COORDINATED WITH SUCCESSFUL CONTRACTOR.
5. 'F' DESIGNATIONS OF LIGHT FIXTURES SHOWN ON LIGHTING DETAILS SHEET.

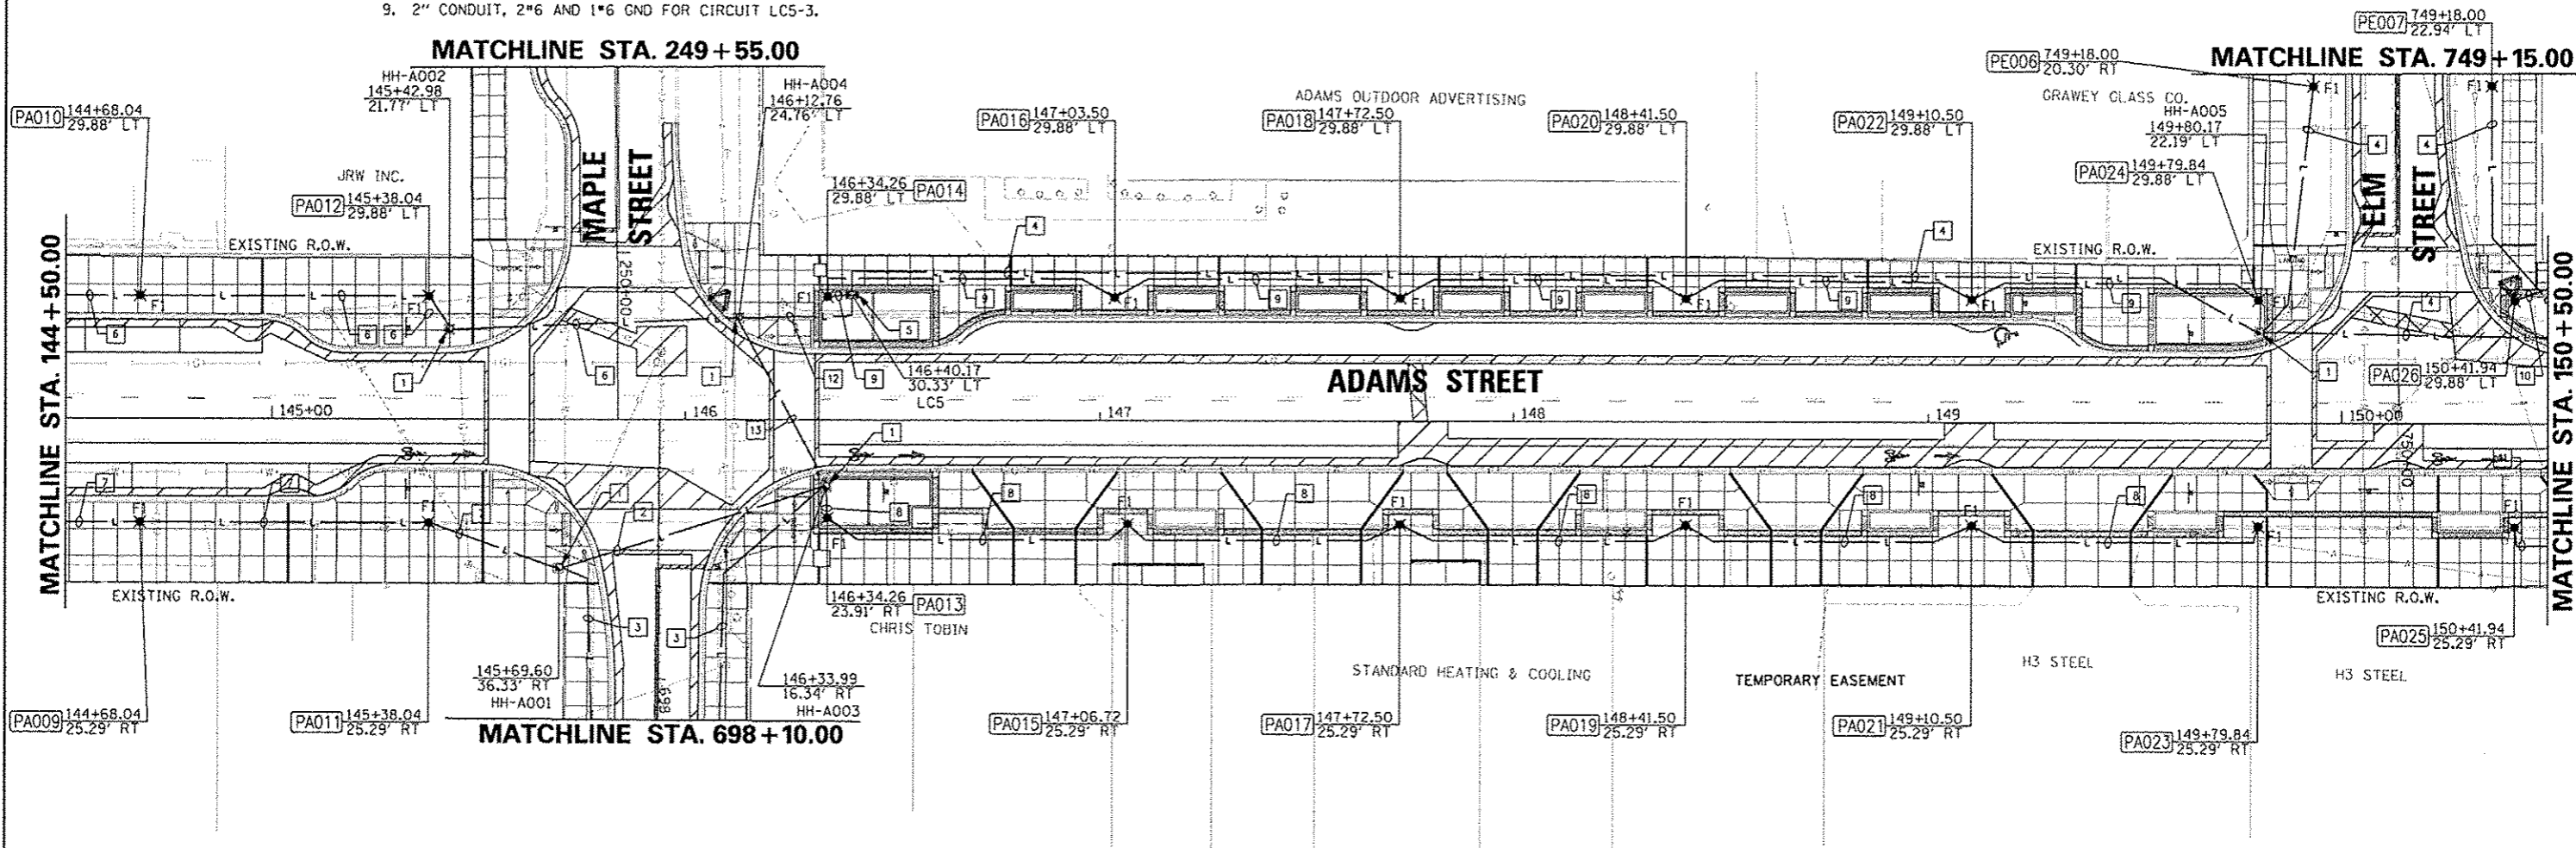

| | | | | | | | | | | |
|--|------------------------|----------------|-----------|---|---------------------------------------|----------------|--|--------------------|------------------|---------------------------------------|
| FILE NAME = c:\pwise\work\do_not_delete\dmx73318\041 | USER NAME = msnak01398 | DESIGNED - JDE | REVISED - | STATE OF ILLINOIS DEPARTMENT OF TRANSPORTATION | ADAMS STREET LIGHTING PLAN | F.A.U. RTE. 12 | SECTION 12-00356-01-PV | COUNTY PEORIA | TOTAL SHEETS 519 | SHEET NO. 355 |
| PLDT SCALE = 3/4" = 1' / in. | CHECKED - BMS | DATE - 7/18/12 | REVISED - | | | SCALE: 1"=20' | SHEET NO. OF SHEETS STA. 144+50.00 TO STA. 150+50.00 | CONTRACT NO. 89626 | | ILLINOIS FED. AID PROJECT TIC-5093158 |
| PLDT DATE = 07/23/2012 | DATE - 7/18/12 | REVISED - | REVISED - | | | | | | | |
| | | | | | | | | | | |

Farnsworth GROUP
 7707 N. KNOXVILLE AVE, SUITE 100
 PEORIA, ILLINOIS 61614
 (309) 693-0888 / (800) 653-9820 Fax
 www.fsg.com