



ALL KEYED NOTES APPLY TO THIS SHEET ONLY.

KEYED NOTES:

1. PORTLAND CEMENT CONCRETE 81400100 - HANDHOLE IDOT STANDARD 814001-02. GROUND HANDHOLE PER IDOT STANDARD 873001-02.
2. 2" CONDUIT, 2*6 AND 1*6 GND FOR CIRCUIT LC4-5.
3. 2" CONDUIT, 2*6 AND 1*6 GND FOR CIRCUIT LC4-8.
4. 2" CONDUIT, 2*6 AND 1*6 GND FOR CIRCUIT LC4-10.
5. 2" CONDUIT, 2*6 AND 1*6 GND FOR CIRCUIT LC4-8 AND 2*6 AND 1*6 GND FOR CIRCUIT LC4-10.
6. 2" CONDUIT, 2*6 AND 1*6 GND FOR CIRCUIT LC4-7.
7. 2" CONDUIT, 2*4 AND 1*4 GND FOR CIRCUIT LC4-9.
8. 2" CONDUIT, 2*6 AND 1*6 GND FOR CIRCUIT LC4-7 AND 2*4 AND 1*4 GND FOR CIRCUIT LC4-9.
9. 2" CONDUIT, 2*6 AND 1*6 GND FOR CIRCUIT LC4-6.
10. SEE MAST ARM LOADING DIAGRAMS FOR TRAFFIC CONTROL DEVICES MOUNTED TO THIS POLE.

NOTES:

1. STATIONS AND OFFSETS SHOWN ON THIS SHEET ARE TO THE CENTER OF HANDHOLE AND LIGHT POLE FOUNDATIONS.
2. COORDINATE INSTALLATION OF UNDERGROUND CONDUIT AND LIGHT FIXTURES WITH ALL EXISTING UNDERGROUND SYSTEMS AND PROPOSED LANDSCAPE FEATURES AND PLANTINGS.
3. SEE IRRIGATION PLANS FOR UNDERGROUND CONDUIT AND PIPING. COORDINATE INSTALLATION OF UNDERGROUND FACILITIES.
4. 'F' DESIGNATIONS OF LIGHT FIXTURES SHOWN ON LIGHTING DETAILS SHEET.

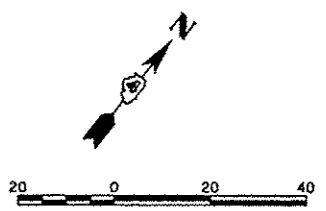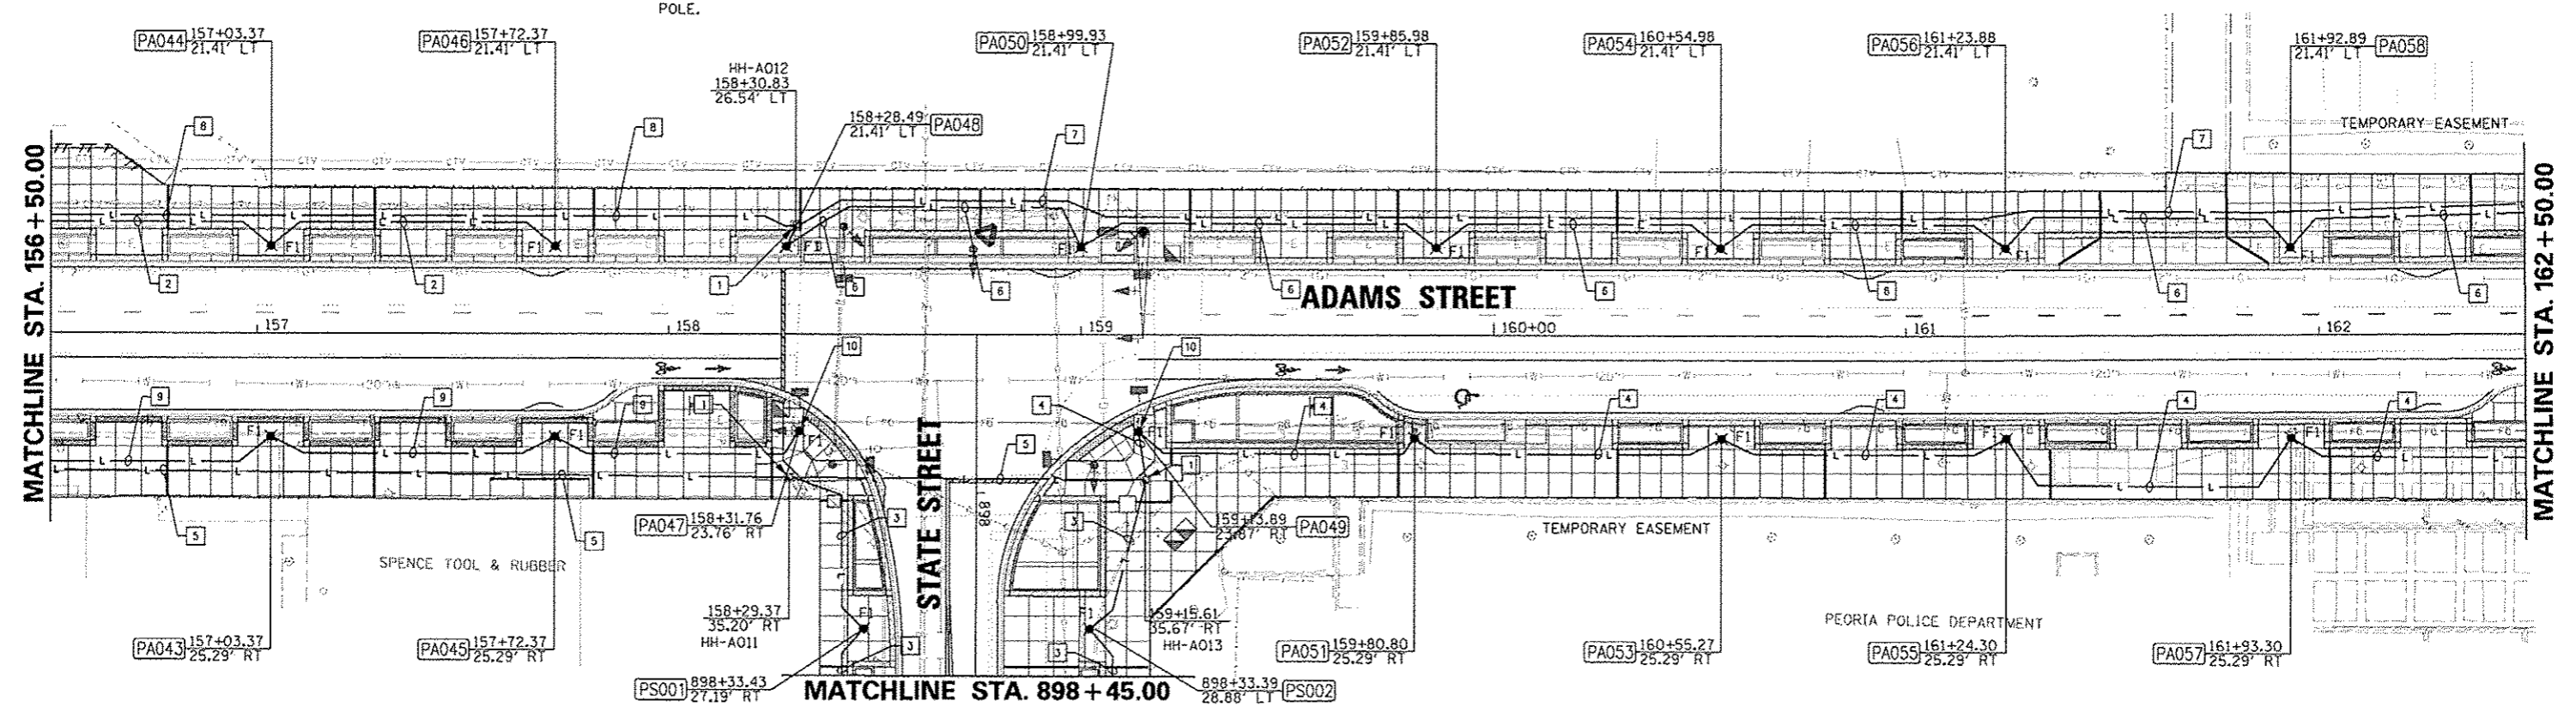

FILE NAME = c:\pwise_work\do_not_delete\dms73318\041	USER NAME = mansk01390	DESIGNED - JDE	REVISED -	STATE OF ILLINOIS DEPARTMENT OF TRANSPORTATION	ADAMS STREET LIGHTING PLAN	F.A.U. RTE.	SECTION	COUNTY	TOTAL SHEETS	SHEET NO.
	PLT SCALE = 3/8" = 1' / in.	DRAWN - TMT	REVISED -			12-00356-01-PV	PEORIA	519	357	
	PLT DATE = 07/23/2012	CHECKED - BMS	REVISED -			CONTRACT NO. 89626				
		DATE - 7/18/12	REVISED -			ILLINOIS FED. AID PROJECT TIG-50931581				
				SCALE: 1"=20'		SHEET NO. OF SHEETS		STA. 156+50.00 TO STA. 162+50.00		