

NOTES:


1. STATIONS AND OFFSETS SHOWN ON THIS SHEET ARE TO THE CENTER OF HANDHOLE AND LIGHT POLE FOUNDATIONS.
2. COORDINATE INSTALLATION OF UNDERGROUND CONDUIT AND LIGHT FIXTURES WITH ALL EXISTING UNDERGROUND SYSTEMS AND PROPOSED LANDSCAPE FEATURES AND PLANTINGS.
3. SEE IRRIGATION PLANS FOR UNDERGROUND CONDUIT AND PIPING. COORDINATE INSTALLATION OF UNDERGROUND FACILITIES.
4. UTILITY SERVICE FROM AMEREN TO LC6 IS CURRENTLY BEING REVIEWED BY AMEREN AND WILL BE COORDINATED WITH SUCCESSFUL CONTRACTOR.
5. 'F' DESIGNATIONS OF LIGHT FIXTURES SHOWN ON LIGHTING DETAILS SHEET.

ALL KEYED NOTES APPLY TO THIS SHEET ONLY.

KEYED NOTES:

1. PORTLAND CEMENT CONCRETE 81400100 - HANDHOLE IDOT STANDARD 814001-02. GROUND HANDHOLE PER IDOT STANDARD 873001-02.
2. 2" CONDUIT, 2*6 AND 1*6 GND FOR CIRCUIT LC6-1 AND 2*6 AND 1*6 GND FOR CIRCUIT LC6-2 AND 2*6 AND 1*6 GND FOR CIRCUIT LC6-3 AND 2*6 AND 1*6 GND FOR CIRCUIT LC6-4.
3. 2" CONDUIT, 2*6 AND 1*6 GND FOR CIRCUIT LC6-1.
4. 2" CONDUIT, 2*6 AND 1*6 GND FOR CIRCUIT LC6-3.
5. LIGHTING CONTROLLER, BASE MOUNTED, 240V, 200 AMP, "LC6.
6. REMOVE COBRA HEAD LIGHT FIXTURE FROM POLE AND REPLACE WITH NEW TYPE F3 FIXTURE.
7. 2" CONDUIT, 2*6 AND 1*6 GND FOR CIRCUIT LC6-4.
8. 2" CONDUIT, 2*6 AND 1*6 GND FOR CIRCUIT LC6-4 AND 2*6 AND 1*6 GND FOR CIRCUIT LC6-2.
9. SEE MAST ARM LOADING DIAGRAMS FOR TRAFFIC CONTROL DEVICES MOUNTED TO POLE. ONE SET OF BANNER ARMS SHALL REMAIN ON OPPOSITE SIDE OF POLE FROM TRAFFIC CONTROL DEVICE.
10. POLE SHALL BE MOUNTED SO THAT FIXTURES ARE PERPENDICULAR TO OAK STREET.

USA TECHNOLOGIES

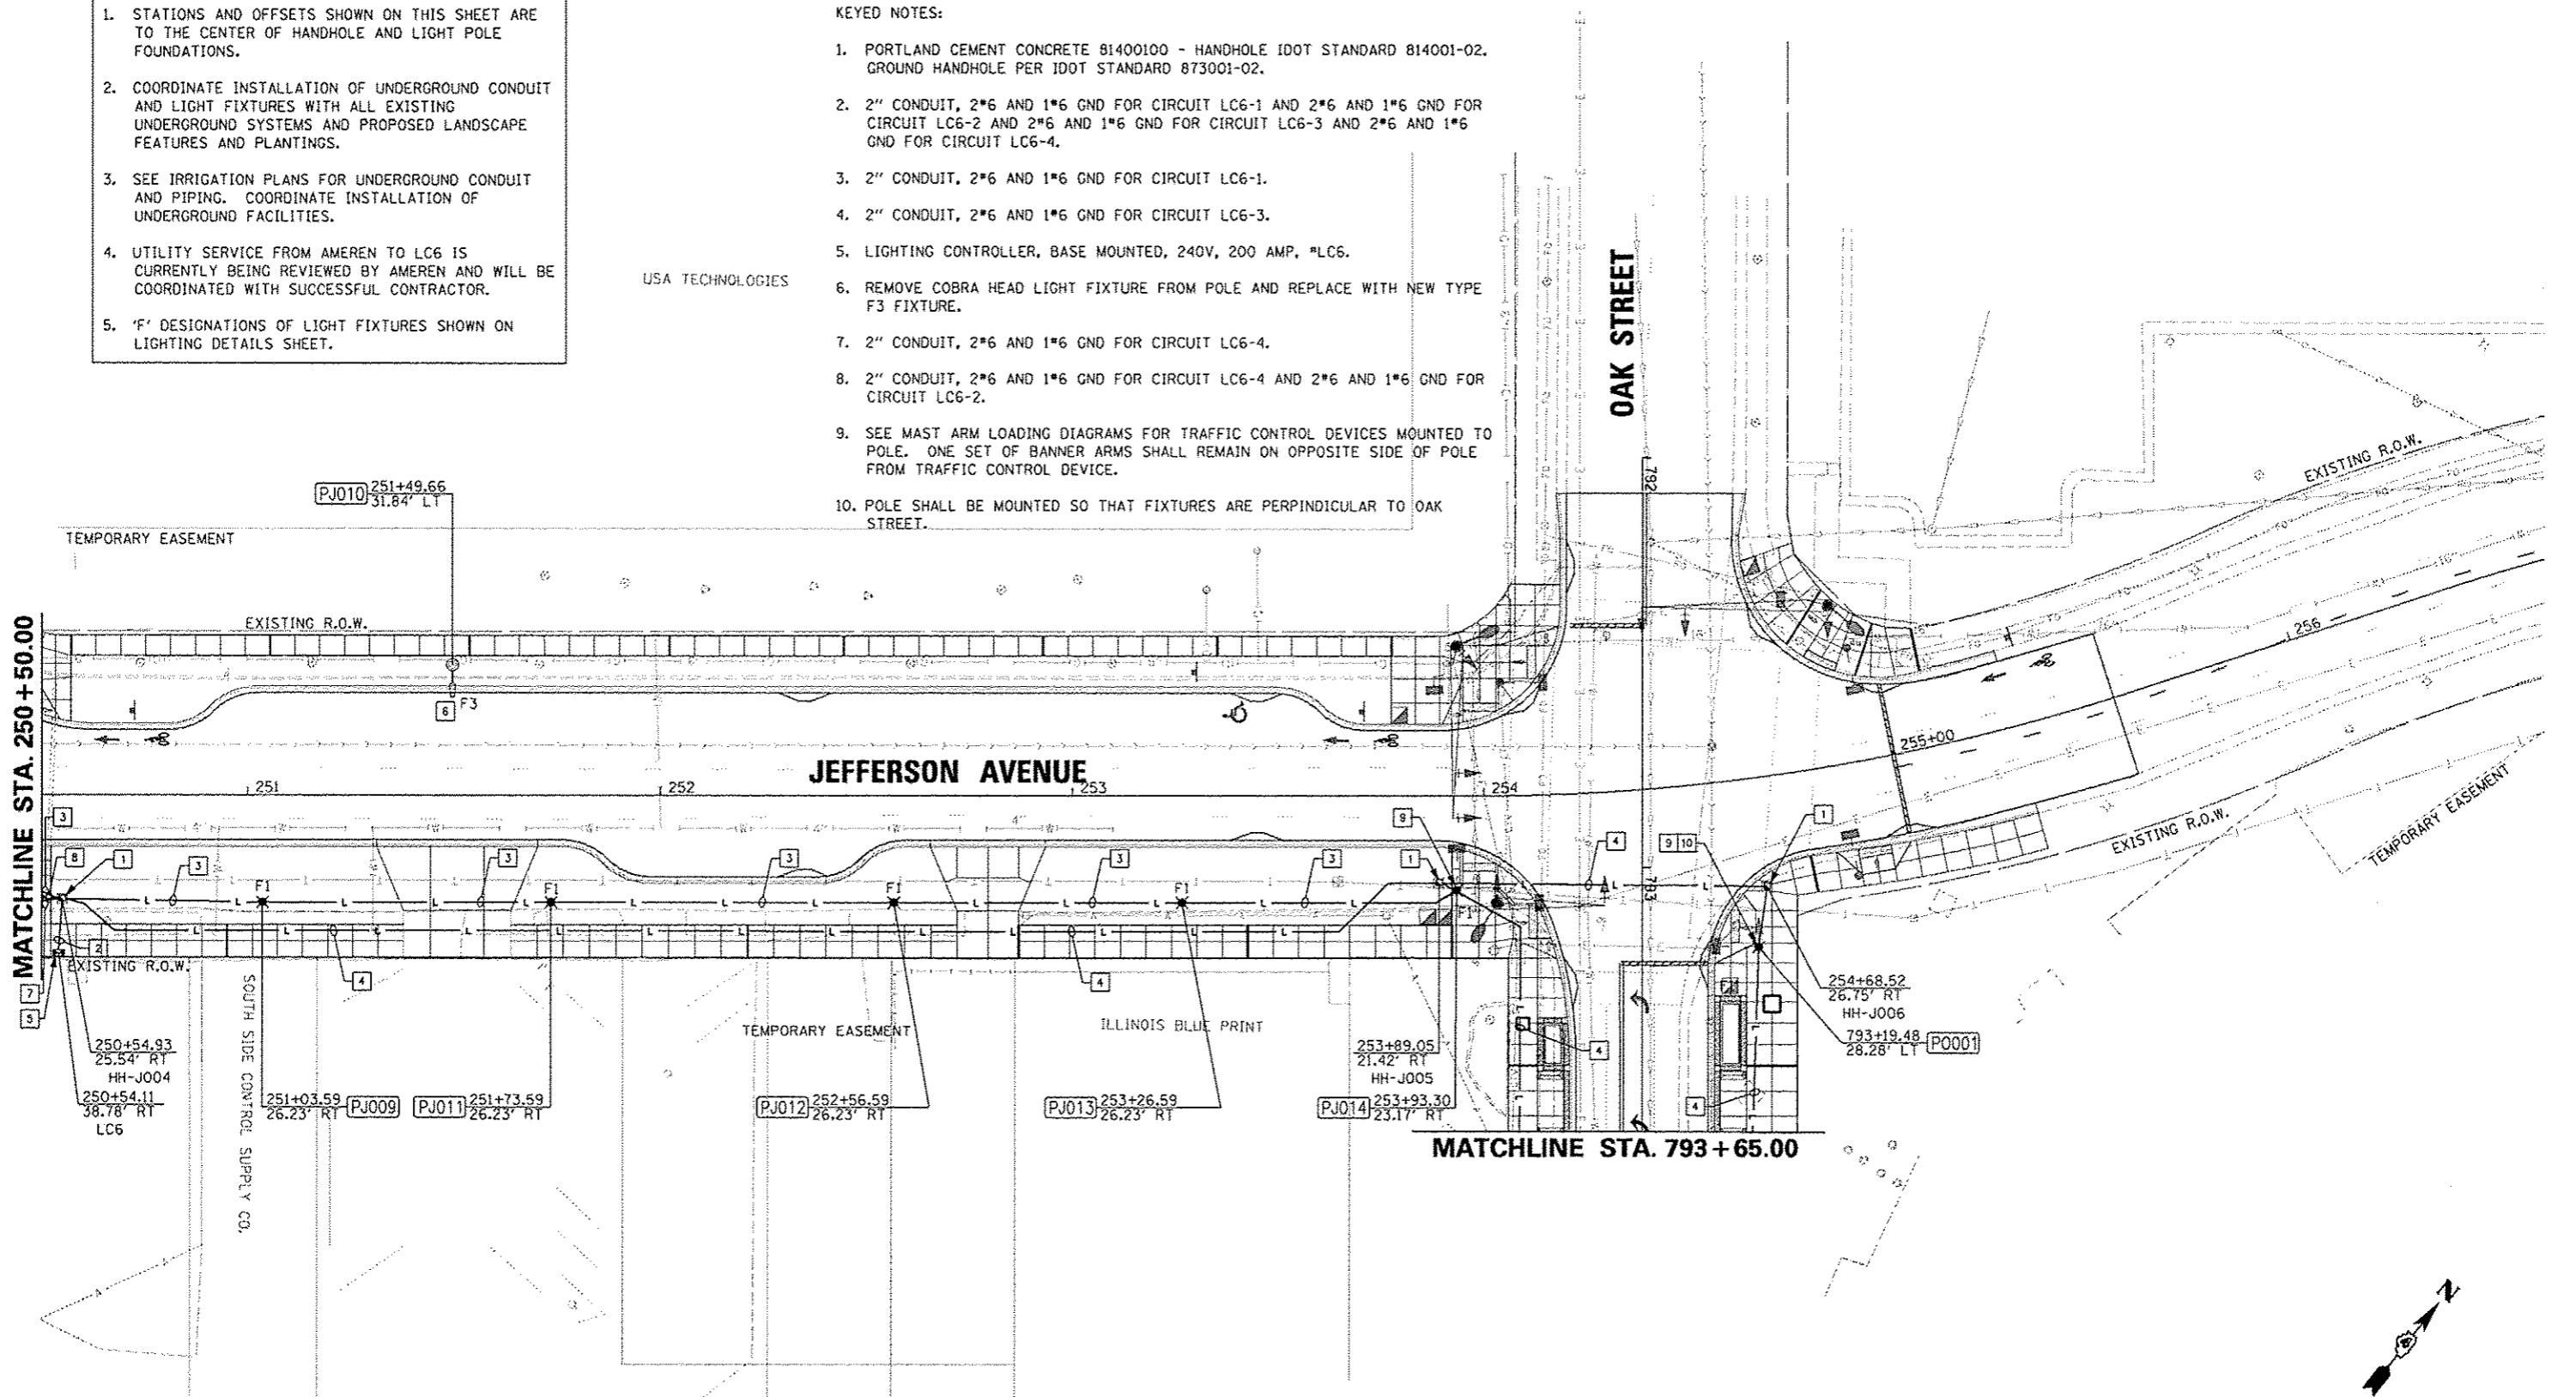

MATCHLINE STA. 250 + 50.00

MATCHLINE STA. 793 + 65.00

FILE NAME * or\pwise_work\do_no_t_delete\ids*73318\041	USER NAME * mersak01390	DESIGNED - JDE	REVISED -	STATE OF ILLINOIS DEPARTMENT OF TRANSPORTATION	JEFFERSON AVENUE LIGHTING PLAN		F.A.U. RTE.	SECTION	COUNTY	TOTAL SHEETS	SHEET NO.
	AL0155-eh-t-light027.dgn	DRAWN - TMT	REVISED -		SCALE: 1"=20'	SHEET NO. OF SHEETS	STA. 250+50.00 TO STA. 255+00.00	12-00356-01-PV	PEORIA	519	361
	PLOT SCALE = 3/8"=1' / in.	CHECKED - BMS	REVISED -				CONTRACT NO.89626		ILLINOIS FED. AID PROJECT TIC-599301581		
	PLOT DATE = 07/20/2012	DATE - 7/18/12	REVISED -								

Farnsworth GROUP
7707 N. KNOXVILLE AVE, SUITE 100
PEORIA, ILLINOIS 61614
(309) 699-8868 / (309) 689-9820 Fax
www.Fw.com