



ALL KEYED NOTES APPLY TO THIS SHEET ONLY.

KEYED NOTES:

1. 2" CONDUIT, 2\*4 AND 1\*4 GND FOR CIRCUIT LC2-14.
2. 2" CONDUIT, 2\*6 AND 1\*6 GND FOR CIRCUIT LC2-16.

NOTES:

1. STATIONS AND OFFSETS SHOWN ON THIS SHEET ARE TO THE CENTER OF HANDHOLE AND LIGHT POLE FOUNDATIONS.
2. COORDINATE INSTALLATION OF UNDERGROUND CONDUIT AND LIGHT FIXTURES WITH ALL EXISTING UNDERGROUND SYSTEMS AND PROPOSED LANDSCAPE FEATURES AND PLANTINGS.
3. SEE IRRIGATION PLANS FOR UNDERGROUND CONDUIT AND PIPING. COORDINATE INSTALLATION OF UNDERGROUND FACILITIES.
4. 'F' DESIGNATIONS OF LIGHT FIXTURES SHOWN ON LIGHTING DETAILS SHEET.

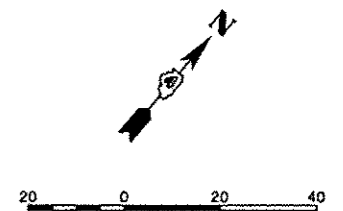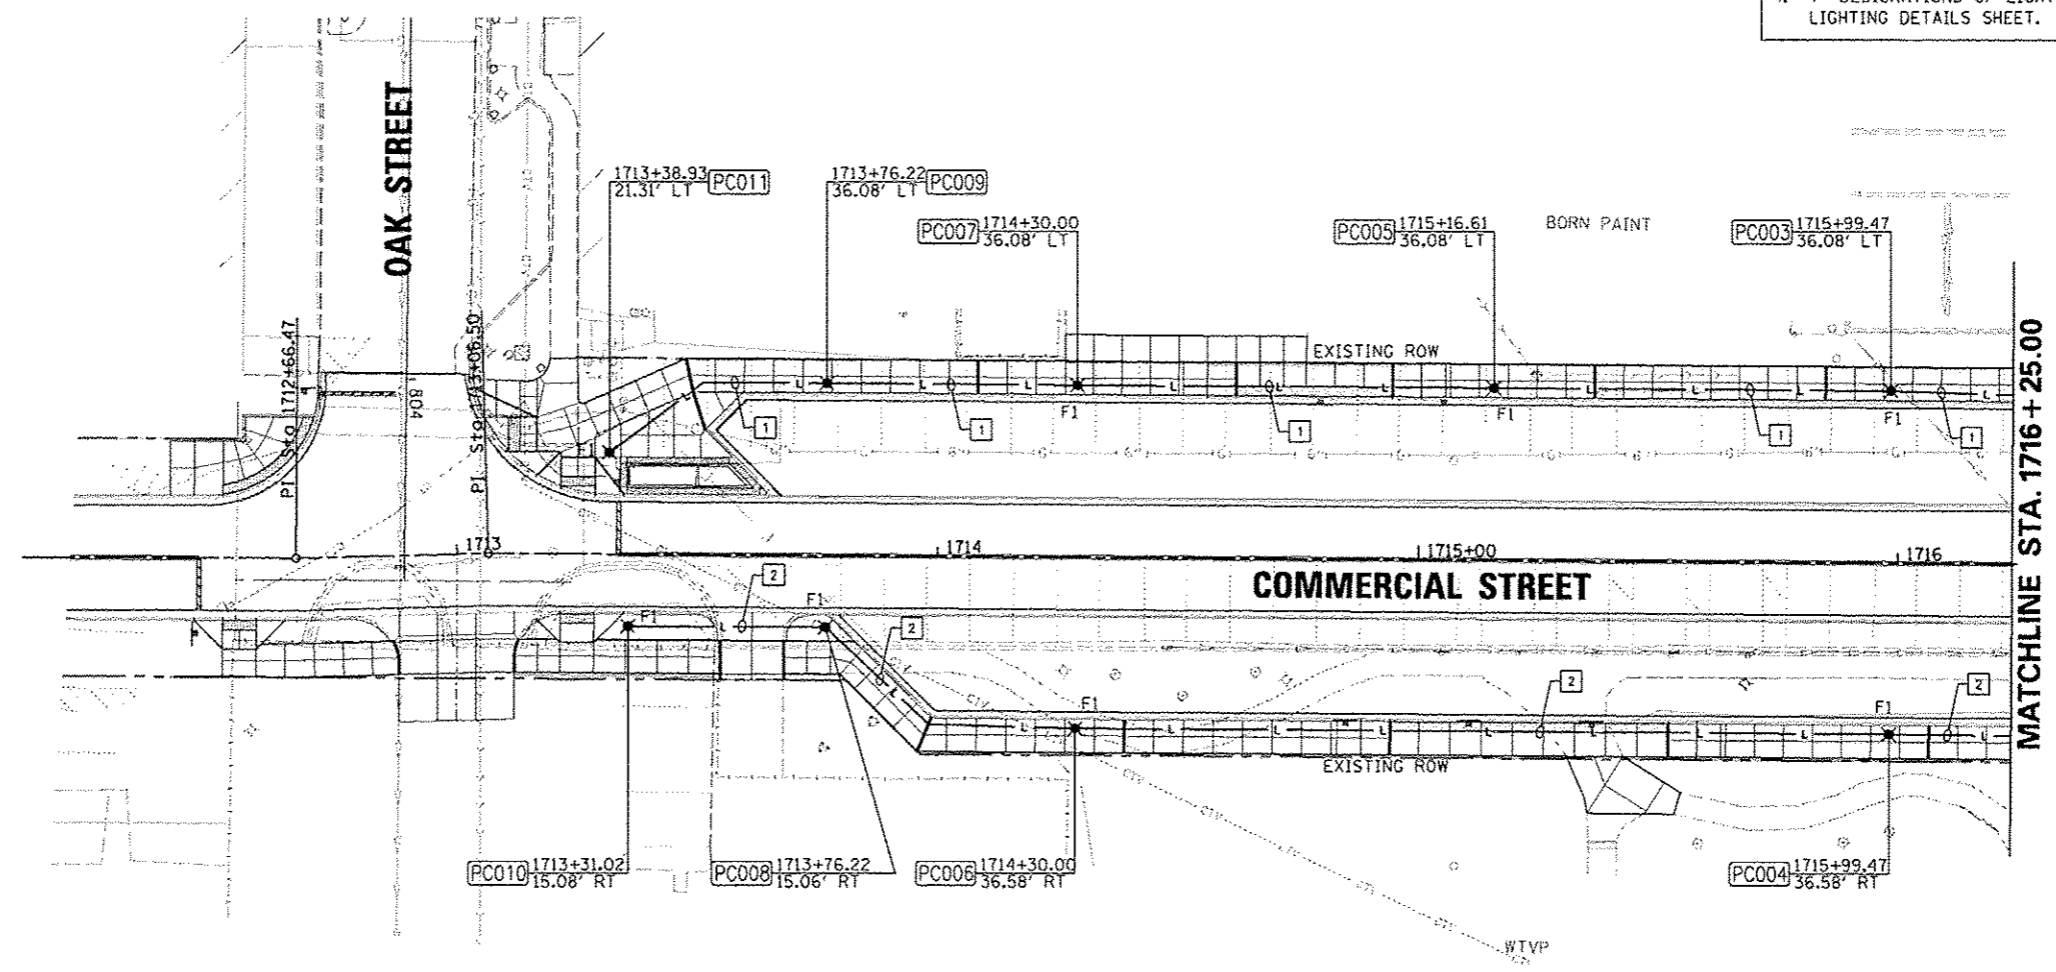

FILE NAME *	USER NAME * mansk01310	DESIGNED - JOE	REVISED -	<b>STATE OF ILLINOIS DEPARTMENT OF TRANSPORTATION</b>	<b>COMMERCIAL STREET LIGHTING PLAN</b>			F.A.U. R.T.E.	SECTION	COUNTY	TOTAL SHEETS	SHEET NO.
c:\pwise\work\do_not_delete\des73318\041	PL0155-ght-light036.dgn	DRAWN - TMT	REVISED -		SCALE: 1"=20'	SHEET NO. OF SHEETS	STA. 1713+00.00 TO STA. 1716+25.00	12-00356-01-PV	PEORIA	519	362	
	PLOT SCALE = 3/4"=1'-0"	CHECKED - BMS	REVISED -					CONTRACT NO. 89626				
	PLOT DATE = 07/23/2012	DATE - 7/18/12	REVISED -					ILLINOIS FED. AID PROJECT				110-50931(58)

**Farnsworth GROUP**  
 7707 N. KNOXVILLE AVE, SUITE 100  
 PEORIA, ILLINOIS 61614  
 (309) 699-3838 / (309) 699-9820 Fax  
 www.f-w.com