
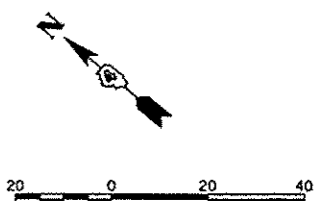


- NOTES:
1. STATIONS AND OFFSETS SHOWN ON THIS SHEET ARE TO THE CENTER OF HANDHOLE AND LIGHT POLE FOUNDATIONS.
 2. COORDINATE INSTALLATION OF UNDERGROUND CONDUIT AND LIGHT FIXTURES WITH ALL EXISTING UNDERGROUND SYSTEMS AND PROPOSED LANDSCAPE FEATURES AND PLANTINGS.
 3. SEE IRRIGATION PLANS FOR UNDERGROUND CONDUIT AND PIPING. COORDINATE INSTALLATION OF UNDERGROUND FACILITIES.
 4. 'F' DESIGNATIONS OF LIGHT FIXTURES SHOWN ON LIGHTING DETAILS SHEET.

- ALL KEYED NOTES APPLY TO THIS SHEET ONLY.
- KEYED NOTES:
1. 2" CONDUIT, 2*4 AND 1*4 GND FOR CIRCUIT LC2-5.
 2. 2" CONDUIT, 2*6 AND 1*6 GND FOR CIRCUIT LC5-4.
 3. SPLICE 2*4, 1*4 GND INTO COILED WIRE IN HANDHOLE. EXTEND INTO EXISTING CONDUIT STUB AND NEW CONDUIT.
 4. INTERCEPT EXISTING 2" CONDUIT AND EXTEND 2*4, 1*4 GND FOR EXISTING CIRCUIT LC2-5 TO NEW FIXTURES.

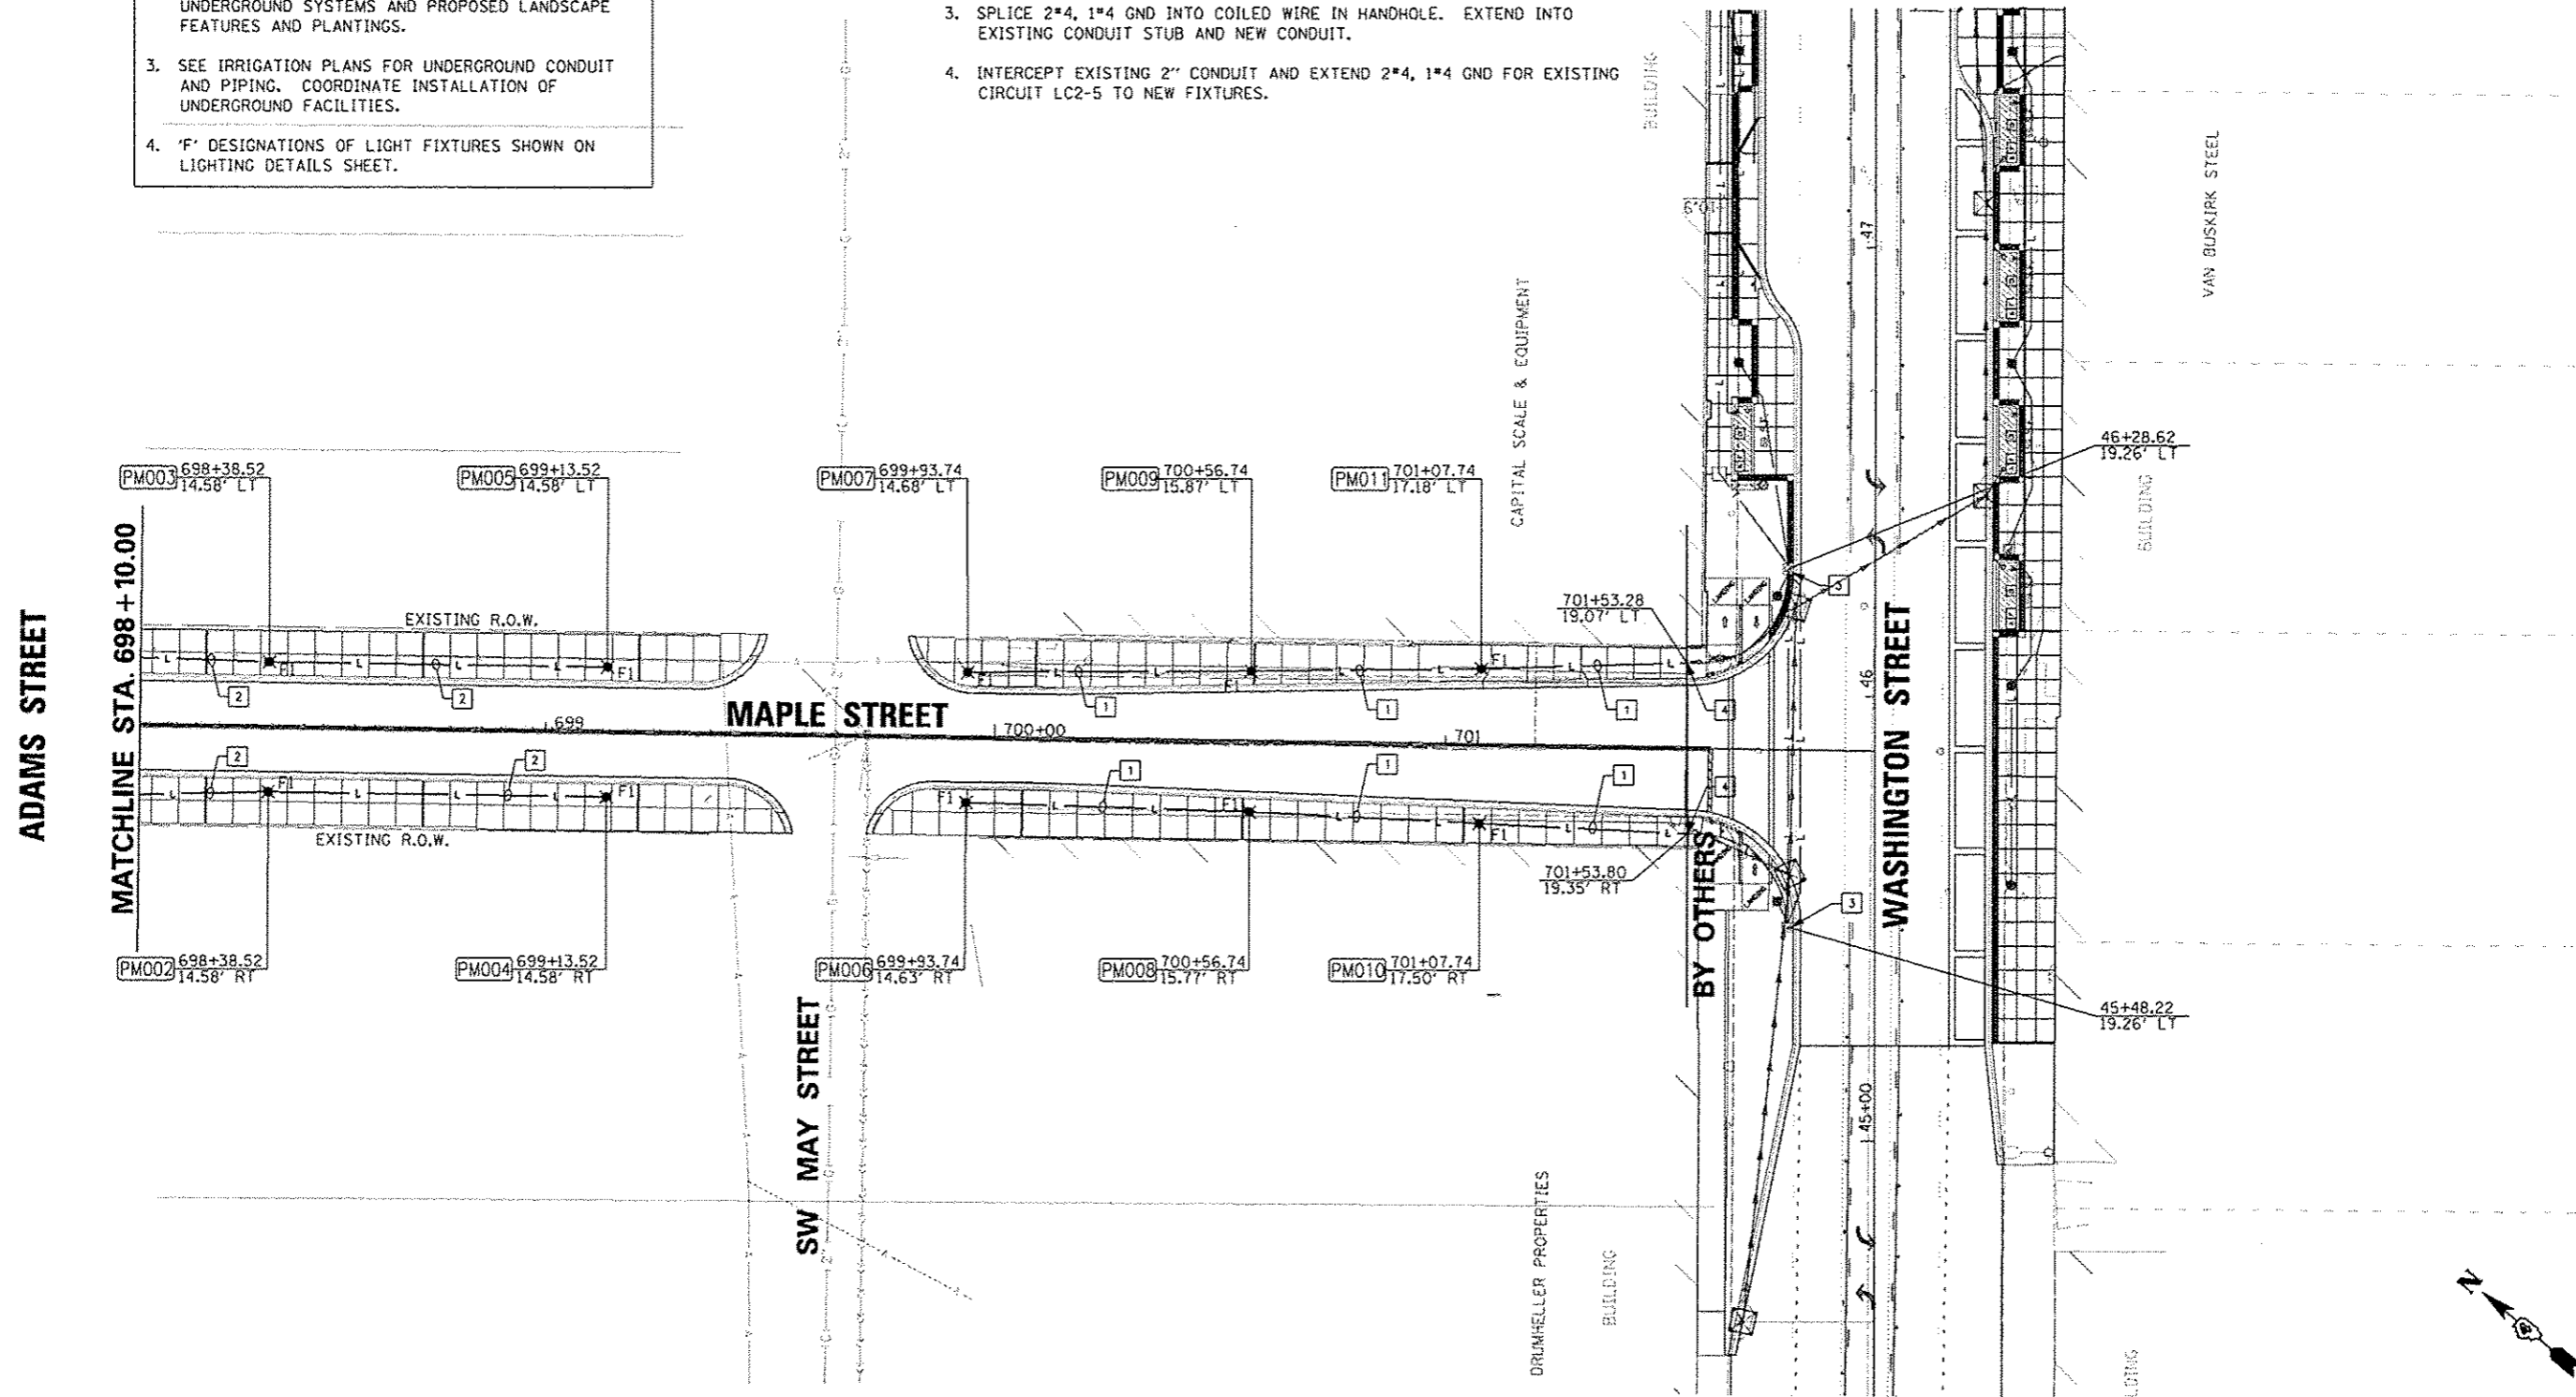

FILE NAME *	USER NAME = dcvsc00870	DESIGNED - JOE	REVISED -	STATE OF ILLINOIS DEPARTMENT OF TRANSPORTATION	MAPLE STREET LIGHTING PLAN	F.A.U. RTE.	SECTION	COUNTY	TOTAL SHEETS	SHEET NO.
or\pwise_work\do_not_delete\dm73318\041	PL0195-shr-light029.dgn	DRAWN - TMT	REVISED -			12-00356-01-PV	PEORIA	519	364	
	PLOT SCALE = 3/4"=1'-0"	CHECKED - BMS	REVISED -			CONTRACT NO. 89626		ILLINOIS FED. AID PROJECT TIG-5093(158)		
	PLOT DATE = 08/23/2012	DATE - 7/18/12	REVISED -			SCALE: 1"=20'	SHEET NO. OF SHEETS	STA. 698+10.00 TO STA. 701+95.00		

Farnsworth GROUP
 7707 N. KNOXVILLE AVE, SUITE 100
 PEORIA, ILLINOIS 61614
 (309) 699-0888 / (309) 699-9820 Fax
 www.f-w.com