



ALL KEYED NOTES APPLY TO THIS SHEET ONLY.

KEYED NOTES:

- EXISTING CITY GRANVILLE FIXTURE. REMOVE 2 FIXTURE HEADS, REPLACE WITH 2 TYPE F2 FIXTURE HEADS.
- EXISTING CITY GRANVILLE FIXTURE. REMOVE 3 FIXTURE HEADS, REPLACE WITH 3 TYPE F2 FIXTURE HEADS.
- 2" CONDUIT FOR FUTURE.
- 2" CONDUIT, 2*4 AND 1*4 GND FOR CIRCUIT LC4-9.

NOTES:

- STATIONS AND OFFSETS SHOWN ON THIS SHEET ARE TO THE CENTER OF HANDHOLE AND LIGHT POLE FOUNDATIONS.
- COORDINATE INSTALLATION OF UNDERGROUND CONDUIT AND LIGHT FIXTURES WITH ALL EXISTING UNDERGROUND SYSTEMS AND PROPOSED LANDSCAPE FEATURES AND PLANTINGS.
- SEE IRRIGATION PLANS FOR UNDERGROUND CONDUIT AND PIPING. COORDINATE INSTALLATION OF UNDERGROUND FACILITIES.
- 'F' DESIGNATIONS OF LIGHT FIXTURES SHOWN ON LIGHTING DETAILS SHEET.

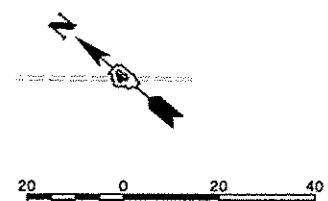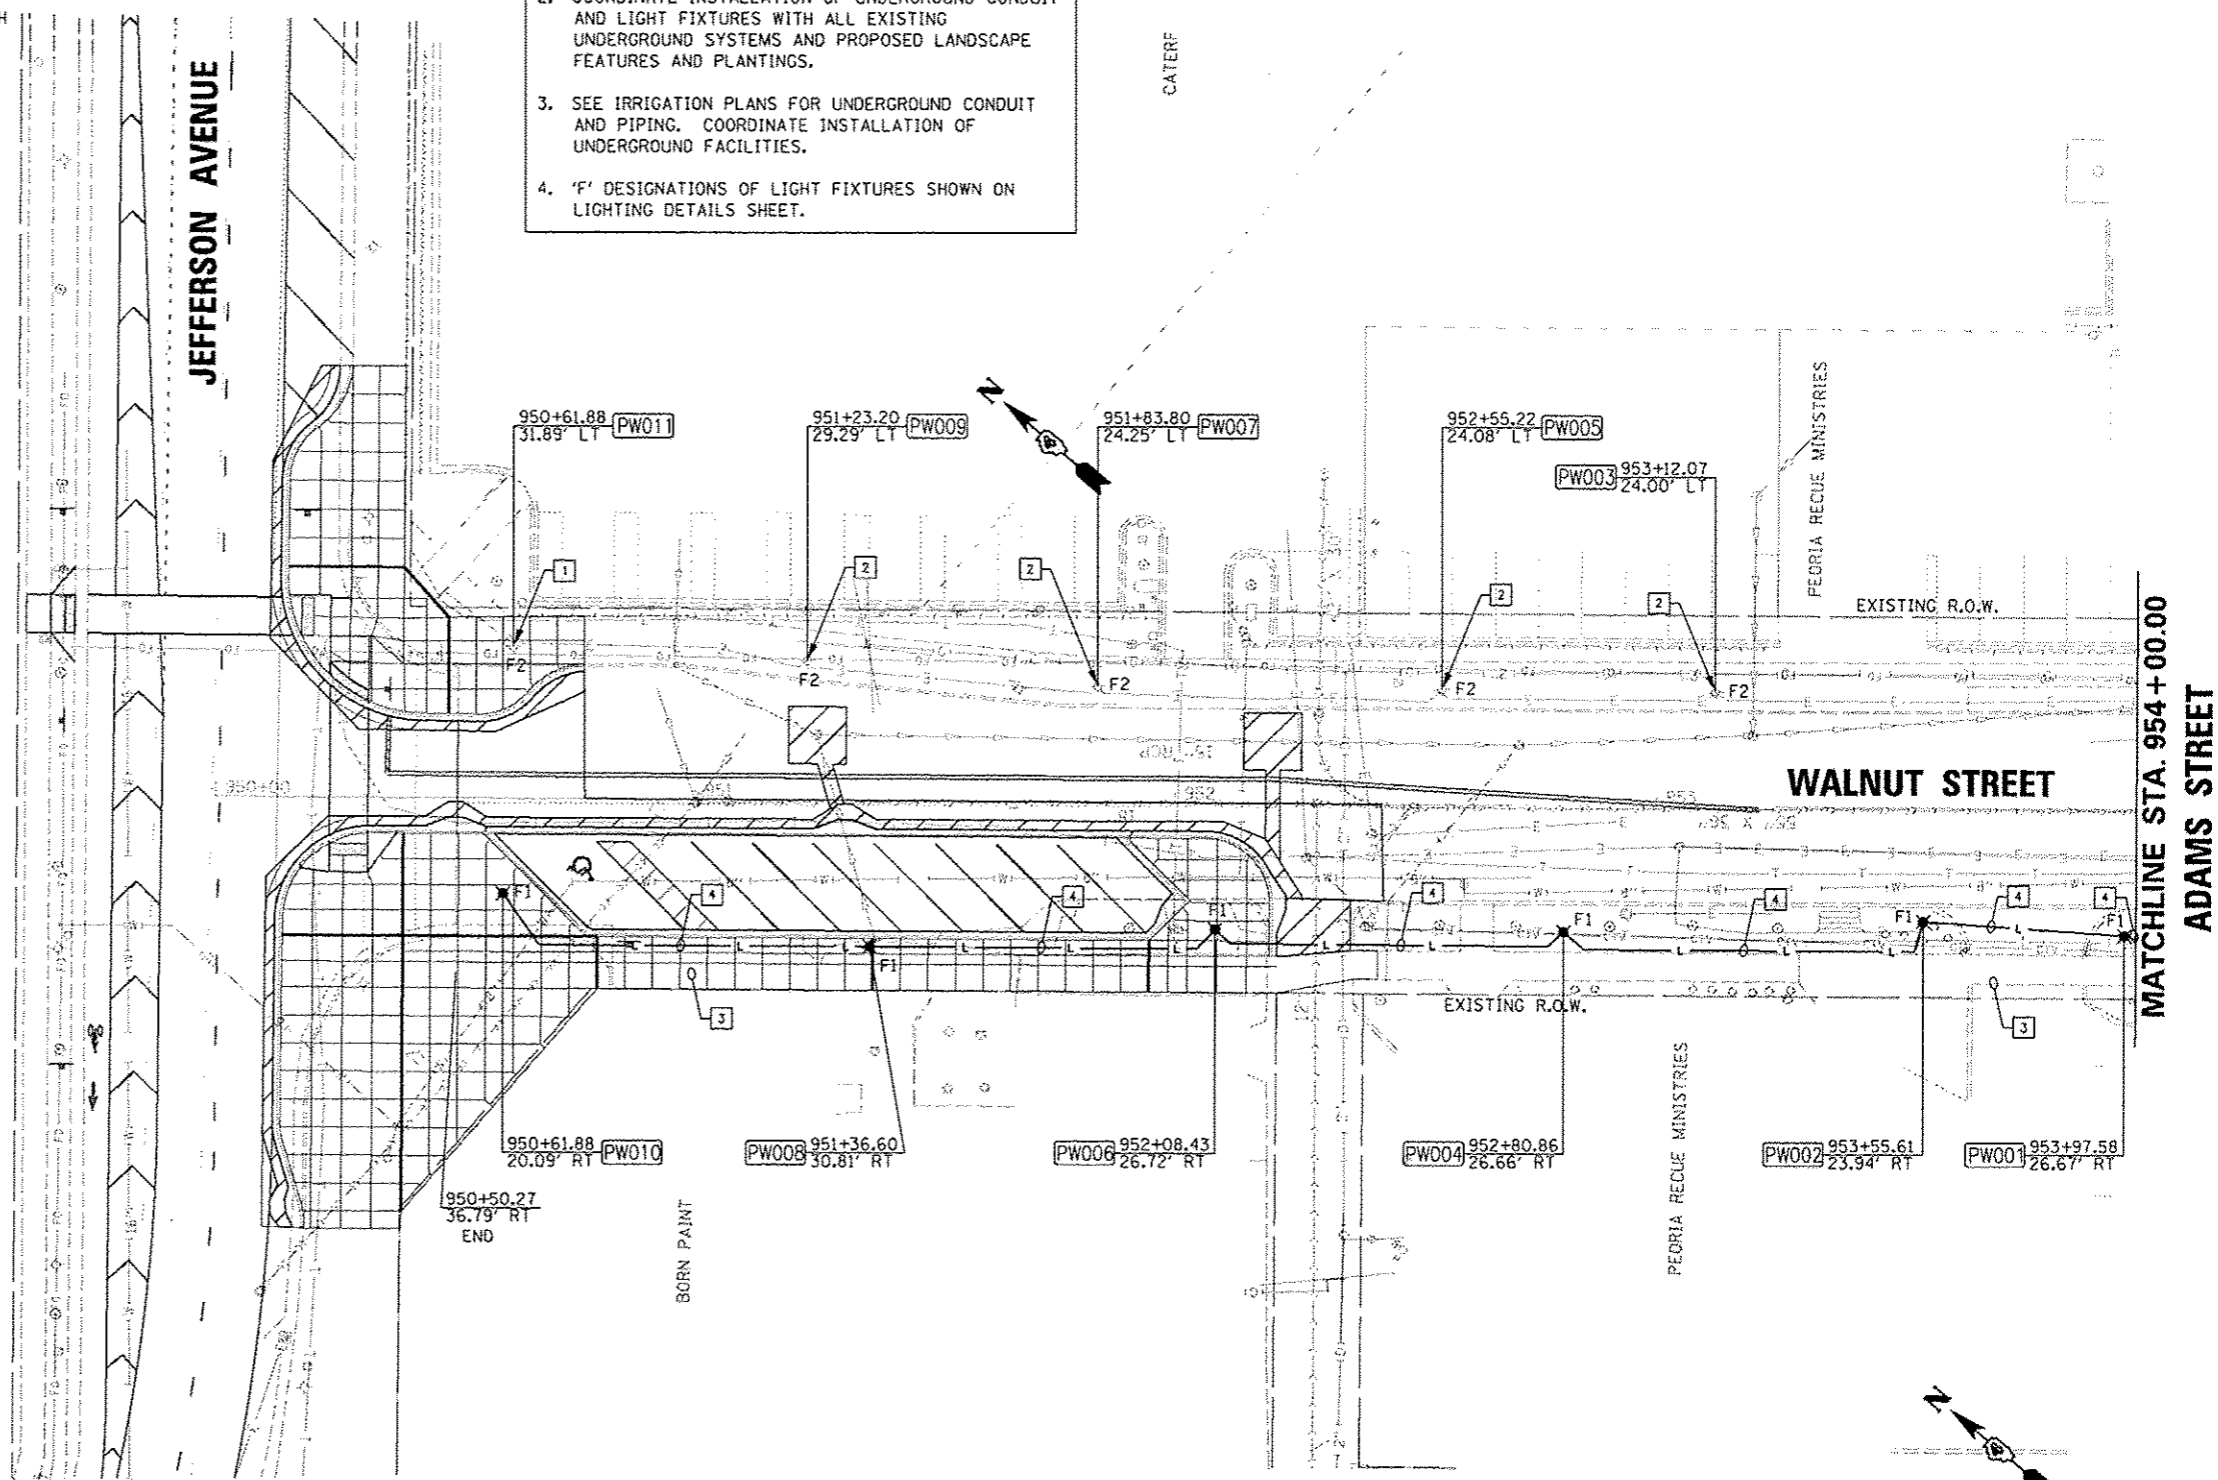

FILE NAME = c:\pview\work\do_not_delete\dms73318\041	USER NAME = manak01390	DESIGNED - JOE	REVISED -	STATE OF ILLINOIS DEPARTMENT OF TRANSPORTATION	WALNUT STREET LIGHTING PLAN	F.A.U. RTE.	SECTION	COUNTY	TOTAL SHEETS	SHEET NO.
	PL01 SCALE = 3/16" = 1' / in.	DRAWN - TMT	REVISED -			12-00356-01-PV	PEORIA	519	370	
PL01 DATE = 07/23/2012	CHECKED - BMS	DATE - 7/18/12	REVISED -	SCALE: 1"=20'	SHEET NO. OF SHEETS	STA. 950+00.00 TO STA. 954+00.00	CONTRACT NO. 89626		ILLINOIS FED. AID PROJECT TIG-30931581	

Farnsworth GROUP
 7707 N. KNOXVILLE AVE, SUITE 100
 PEORIA, ILLINOIS 61614
 (309) 699-9626 / (309) 699-9620 Fax
 www.fw.com