



**TYPICAL SPLICE DETAIL**

N.T.S.

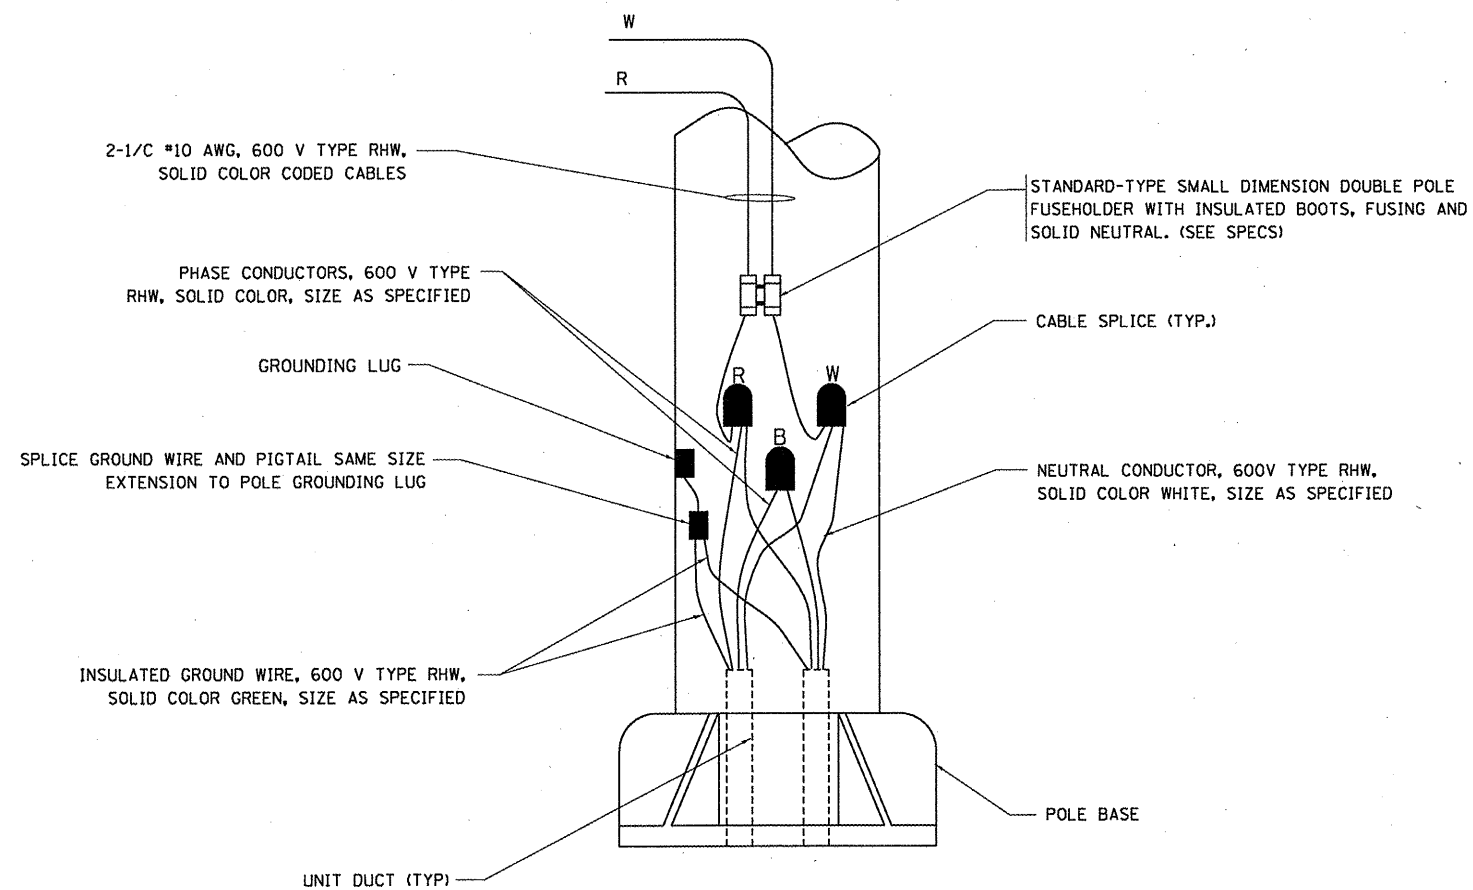

**POLE WIRING DETAIL**

N.T.S.

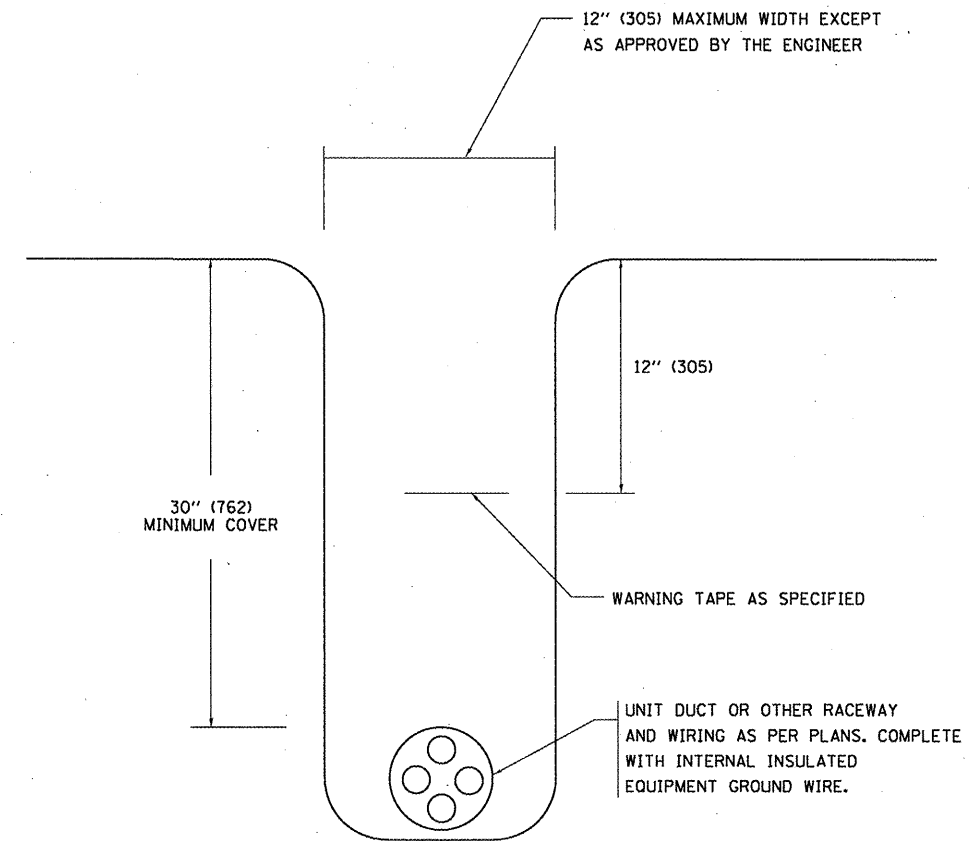

**TYPICAL WIRING IN TRENCH DETAIL**

N.T.S.

FILE NAME =	USER NAME = hmdeneh	DESIGNED -	REVISED - 08-08-03
ca:\pwork\pwork\hmdeneh\0252916\01s	Std.dgn	DRAWN -	REVISED -
	PLOT SCALE = 1/8" = 1' / in.	CHECKED -	REVISED -
	PLOT DATE = 9/9/2011	DATE -	REVISED -

**STATE OF ILLINOIS  
DEPARTMENT OF TRANSPORTATION**

**MISC. ELECTRICAL DETAILS  
SHEET A**

SCALE: NONE SHEET NO. 1 OF 1 SHEETS STA. TO STA.

F.A.I. RTE.	SECTION	COUNTY	TOTAL SHEETS	SHEET NO.
I-290	2011-061-BR	COOK & DUPAGE	29	28
BE-702			CONTRACT NO. 60P79	
FED. ROAD DIST. NO. 1 ILLINOIS FED. AID PROJECT				