


*REF-LITE#
*REF-LITE#

CONTRACT# 60363

F.A. RTE.	SECTION	COUNTY	TOTAL SHEETS	SHEET NO.
*	*	*	608	328
STA.		TO STA.		
FED. ROAD DIST. NO.	ILLINOIS	FED. AID PROJECT		
*26HB-1BR & 114R-1				

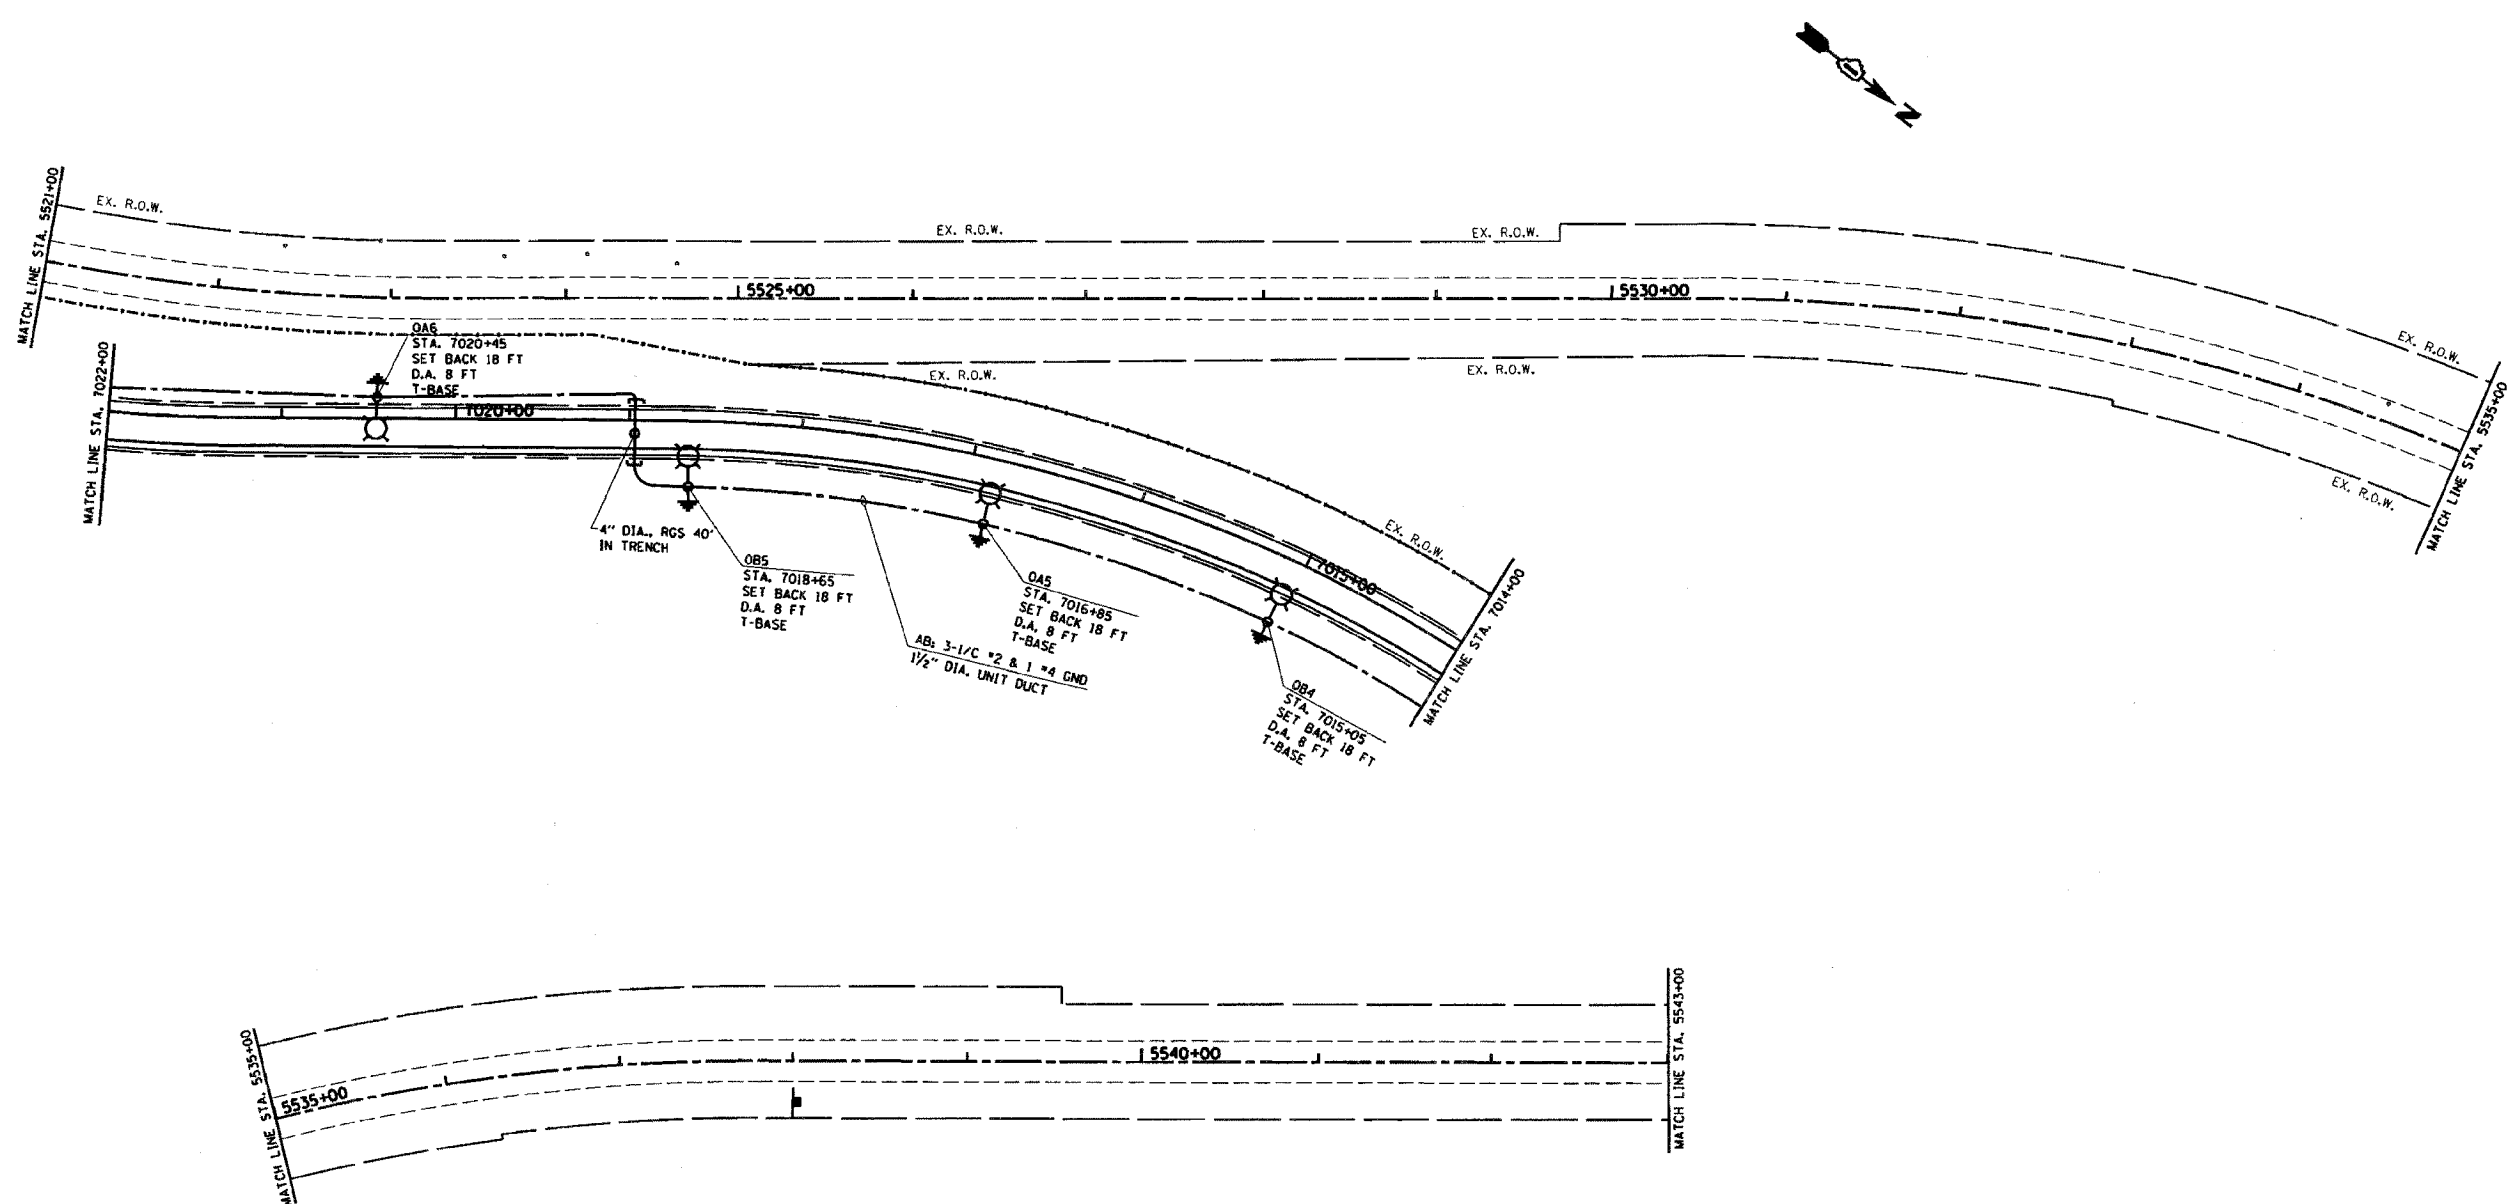

REVISIONS		ILLINOIS DEPARTMENT OF TRANSPORTATION
NAME	DATE	
		I-55 AT IL. ROUTE 59 IDOT LIGHTING PLAN
VERT. SCALE: 1"=50' HORIZ. SCALE: 1"=50' DATE 3/13/2008		DRAWN BY T.G. CHECKED BY

3/13/2008
c:\projects\26397\sh_lighting.dgn
bauerdl