



HANSON PROFESSIONAL SERVICES INC.

815 Commerce Drive, Suite 200
Oak Brook, Illinois 60523
Telephone: 630.990.3800
Fax: 630.990.3801

Illinois Professional Design Firm
Registration No. 184-001084

© Copyright Hanson Professional Service Inc. 2008



JOLIET REGIONAL PORT DISTRICT


1 George Michas Drive
Romeoville, Illinois 60446
Telephone: 815.838.9497
Fax: 815.838.9524

EXTEND RUNWAY 2-20; CONSTRUCT
TAXIWAY TURNAROUND

AIP PROJECT NO. 3-17-0140-B42
IDA PROJECT NO. LOT-3792

NOTES

1. ALL ELECTRICAL EQUIPMENT SHALL BE INSTALLED IN CONFORMANCE WITH NFPA 70 (NEC MOST CURRENT ISSUE IN FORCE), THE RESPECTIVE EQUIPMENT MANUFACTURER'S DIRECTIONS AND ALL OTHER APPLICABLE LOCAL CODES, LAWS, ORDINANCES AND REQUIREMENTS IN FORCE. ANY INSTALLATIONS WHICH VOID THE U.L. LISTING (OR OTHER THIRD PARTY LISTING) AND/OR THE MANUFACTURER'S WARRANTY OF A DEVICE SHALL NOT BE PERMITTED.
2. LOW VOLTAGE WIRING (600V & BELOW) SHALL MAINTAIN SEPARATION FROM HIGH VOLTAGE WIRING (5000V) & SHALL NOT BE INSTALLED IN THE SAME RACEWAY, PULLBOX, OR HANDHOLE AS THE HIGH VOLTAGE WIRING.
3. ALL POWER OUTAGES AND/OR SHUTDOWNS TO EXISTING AIRFIELD LIGHTING SYSTEMS SHALL BE COORDINATED WITH THE AIRPORT MANAGER AND THE RESIDENT ENGINEER.
4. RELOCATION OF REILS WILL BE PAID FOR UNDER ITEM AR125967 RELOCATE REILS - PER PAIR.
5. RELOCATION OF PAPI SHALL BE PAID FOR UNDER ITEM AR125968 RELOCATE PAPI - PER EACH.

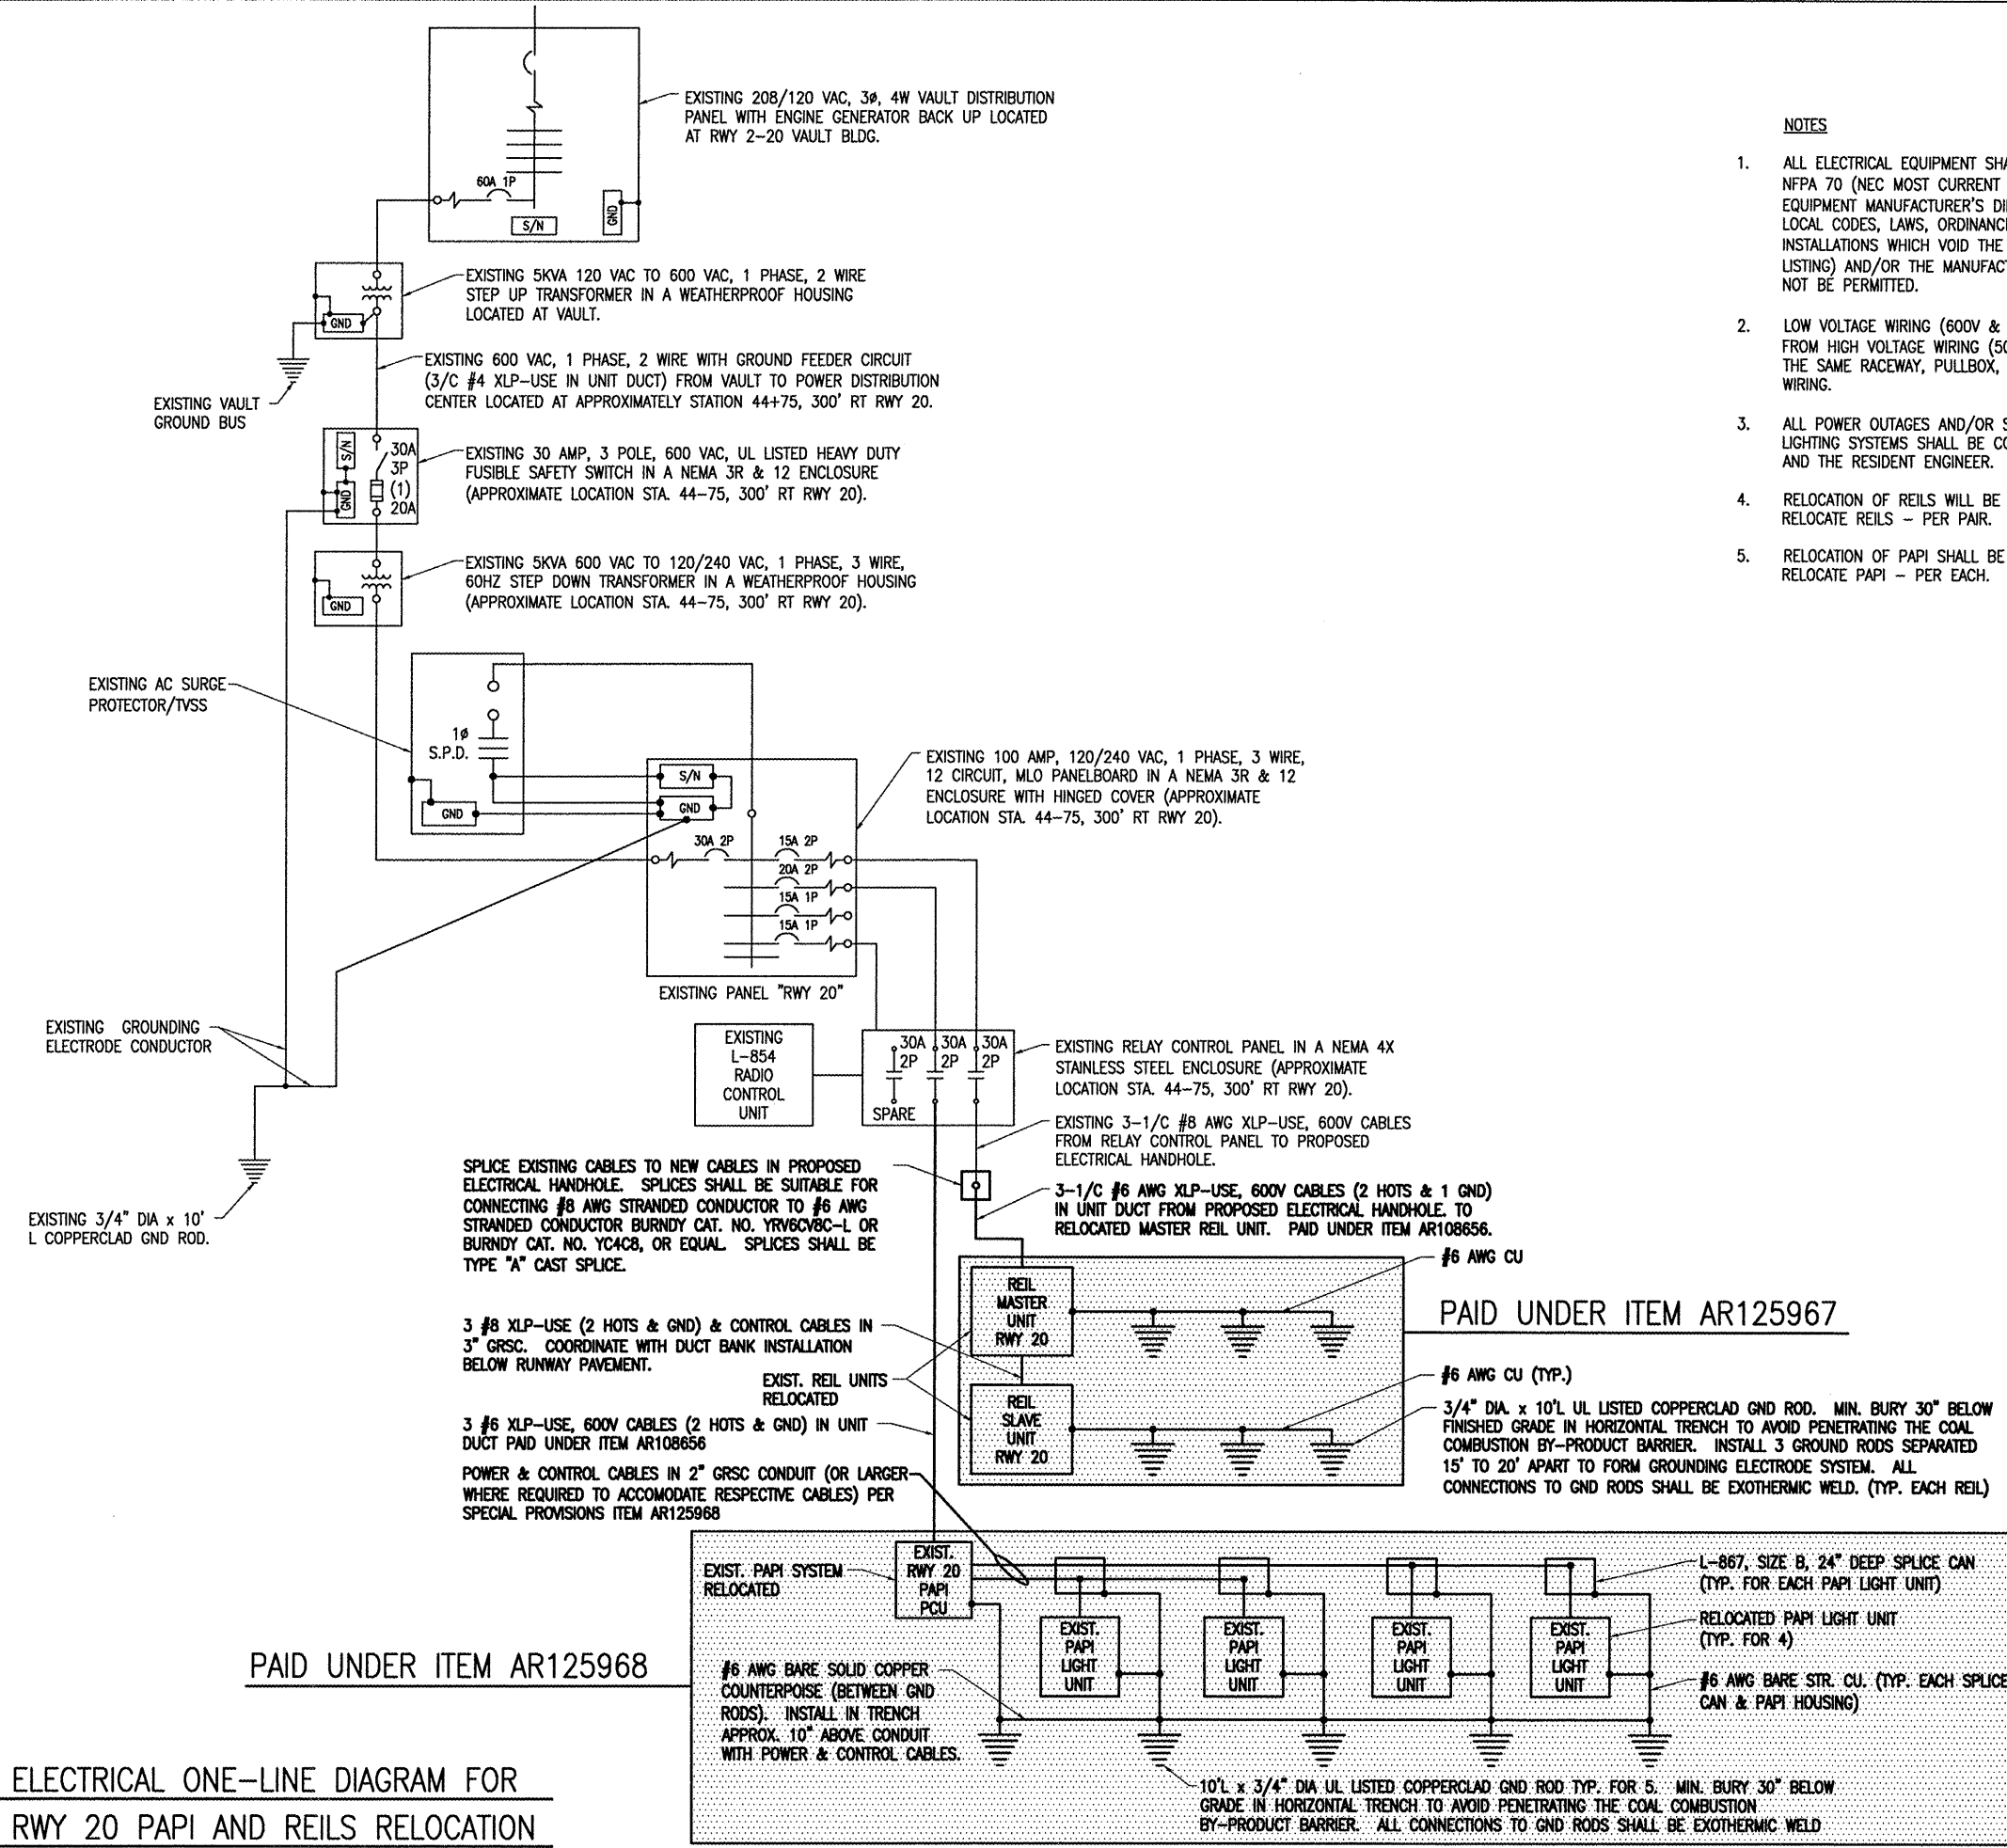

PAID UNDER ITEM AR125968

ELECTRICAL ONE-LINE DIAGRAM FOR
RWY 20 PAPI AND REILS RELOCATION

No.	Drawing Issue Description	Date	By

Date
APRIL 18, 2008
Sheet Title

ELECTRICAL ONE LINE
FOR RWY 20 PAPI AND
REILS RELOCATION

07A0166
Project Number
KNL 03/17/08
Layout By Date
KNL 03/17/08
Designed By Date
RMH 03/20/08
Reviewed By Date
MV
Drawn By Sheet No.

L:\07\0651\0804\07\01066\DRAWINGS\LSREETS\63-REIL & PAPI ONE LINE.DWG APR 18, 2008 10:19AM HAUSM0662