



HANSON PROFESSIONAL SERVICES INC.

815 Commerce Drive, Suite 200
Oak Brook, Illinois 60523
Telephone: 630.990.3800
Fax: 630.990.3801

Illinois Professional Design Firm
Registration No. 184-001084

© Copyright Hanson Professional Service Inc. 2008




JOLIET REGIONAL PORT DISTRICT

1 George Michas Drive
Romeoville, Illinois 60446
Telephone: 815.838.9497
Fax: 815.838.9524

EXTEND RUNWAY 2-20: CONSTRUCT
TAXIWAY TURNAROUND


AIP PROJECT NO. 3-17-0140-B42
IDA PROJECT NO. LOT-3792

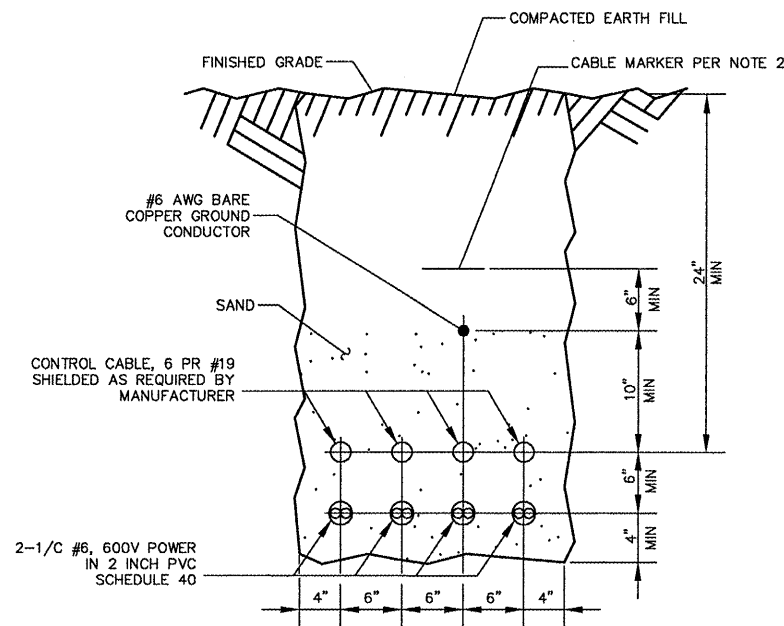

NOTES:

1. THIS DETAIL IS INTENDED ONLY TO SHOW THE REQUIRED SEPARATION OF THE VARIOUS CABLES WITHIN THE TRENCH. FOR EXACT NUMBER OF CABLES RUNNING TO EACH PAPI UNIT, SEE WIRING DIAGRAM BY MANUFACTURER.
2. CABLE MARKER TAPE, PN 0761315 MANUFACTURED BY ALLEN SYSTEMS, OR EQUAL, SHALL BE PLACED IN ALL CABLE TRENCHES AT 6" ABOVE GROUNDING CONDUCTOR


PAPI CABLES TRENCH DETAIL

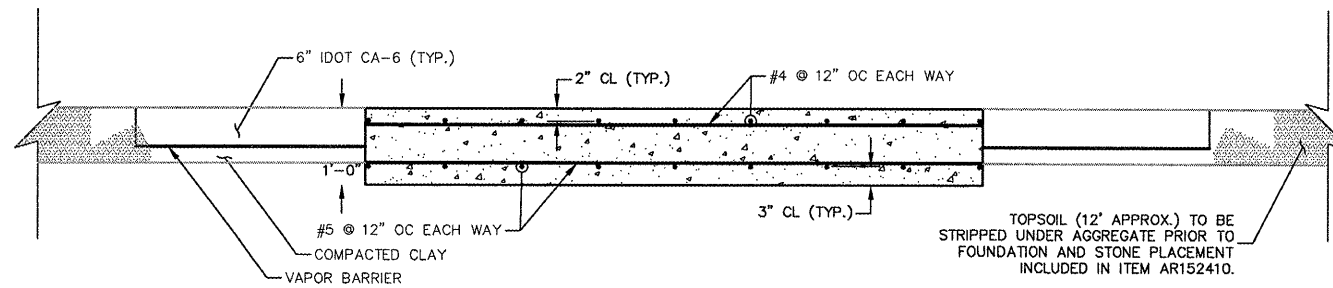

PAPI FOUNDATION SECTION

NOTES:

1. COMPACTED STONE TO BE PAID SEPERATELY UNDER ITEM AR208606. VAPOR BARRIER TO BE PAID SEPERATELY UNDER ITEM AR800968.

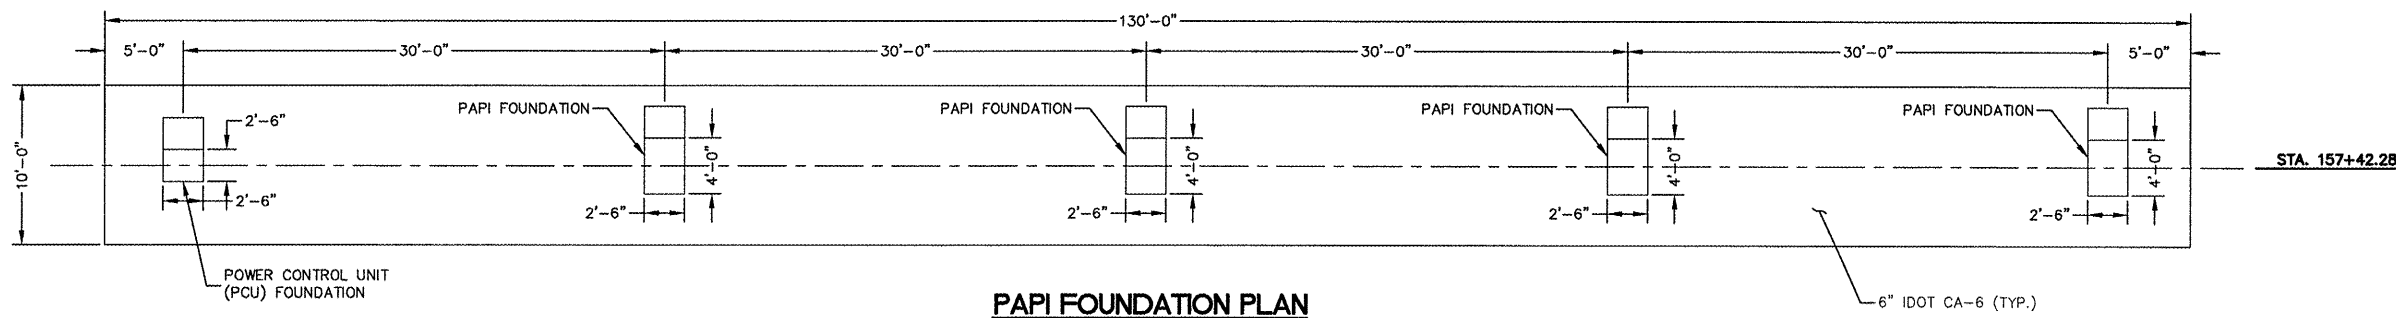

PAPI FOUNDATION PLAN

DETAILS SHOWN ARE NOT TO SCALE

No.	Drawing Issue Description	Date	By

Date
APRIL 18, 2008
Sheet Title

**PAPI FOUNDATION
DETAILS**

07A0166
Project Number
LDH 03/07/08
Layout By Date
LDH 03/07/08
Designed By Date
RMH 03/20/08
Reviewed By Date
Drawn By Date

66

I:\07\005\00840\07A0166\DR\DWG\DETAILS.DWG APR 18, 2008 10:20AM HANSON0802