

F.A.U. RTE.	SECTION	COUNTY	TOTAL SHEETS	SHEET NO.
2652	00-00069-00-PV	DUPAGE	146	1
STA. 10+70.70		TO STA. 66+16.00		
FED. ROAD DIST. NO.		ILLINOIS	FED. AID PROJECT	
CONTRACT NO. 83781				

INDEX OF SHEETS:

- 1 COVER SHEET
- 2 GENERAL NOTES, STANDARDS
- 3-7 SUMMARY OF QUANTITIES
- 8-9 TYPICAL SECTIONS
- 10-13 SCHEDULE OF QUANTITIES
- 14 ALIGNMENT, TIES, AND BENCHMARKS
- 15-24 PLAN AND PROFILE
- 25-34 SUGGESTED MAINTENANCE OF TRAFFIC
- 35-39 EROSION CONTROL PLANS
- 40-55 DRAINAGE AND UTILITIES
- 56-60 WATER MAIN PLAN AND PROFILE
- 61-68 RIGHT-OF-WAY PLATS
- 69-73 PAVEMENT MARKING PLANS
- 74-82 LIGHTING PLANS
- 83-89 MISCELLANEOUS DETAILS
- 90-146 CROSS SECTIONS

**STATE OF ILLINOIS
DEPARTMENT OF TRANSPORTATION
DIVISION OF HIGHWAYS**

**PROPOSED
HIGHWAY PLANS**

**FAU RTE 2652 - SOUTH VILLA AVENUE
(ROOSEVELT ROAD TO MADISON STREET)**

SECTION: 00-00069-00-PV

PROJECT: CMM-M-8003 (C334)

**JOB NUMBER: C 91-052-04 VILLAGE OF VILLA PARK
DU PAGE COUNTY**



HIGHWAY STANDARDS: SHEET 2 OF 146

TRAFFIC DATA:

VILLA AVENUE:
2,900-4,900 VEHICLES (2000)
4,000-6,000 VEHICLES (2020)


POSTED SPEED LIMIT:

VILLA AVENUE:
30 mph

DESIGN DESIGNATION:

600 (20) COLLECTOR 0.5 (FD-20)

THE WORK UNDER THIS CONTRACT SHALL CONSIST OF:
STAGED RECONSTRUCTION AND WIDENING OF VILLA AVENUE
INCLUDING ENCLOSED DRAINAGE, CURB AND GUTTER AND
SIDEWALK.

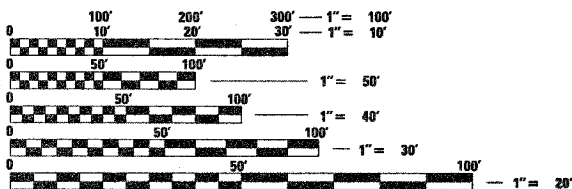


FULL SIZE PLANS HAVE BEEN PREPARED USING STANDARD
ENGINEERING SCALES. REDUCED SIZED PLANS WILL NOT
CONFORM TO STANDARD SCALES. IN MAKING MEASUREMENTS
ON REDUCED PLANS, THE ABOVE SCALES MAY BE USED.

J.U.L.I.E.
JOINT UTILITY LOCATION INFORMATION FOR EXCAVATION
1-800-892-0123

CONTRACT NO. 83781



FEDERAL AID DESIGN ENGINEER: MAZHAR KHAN (847)705-4179

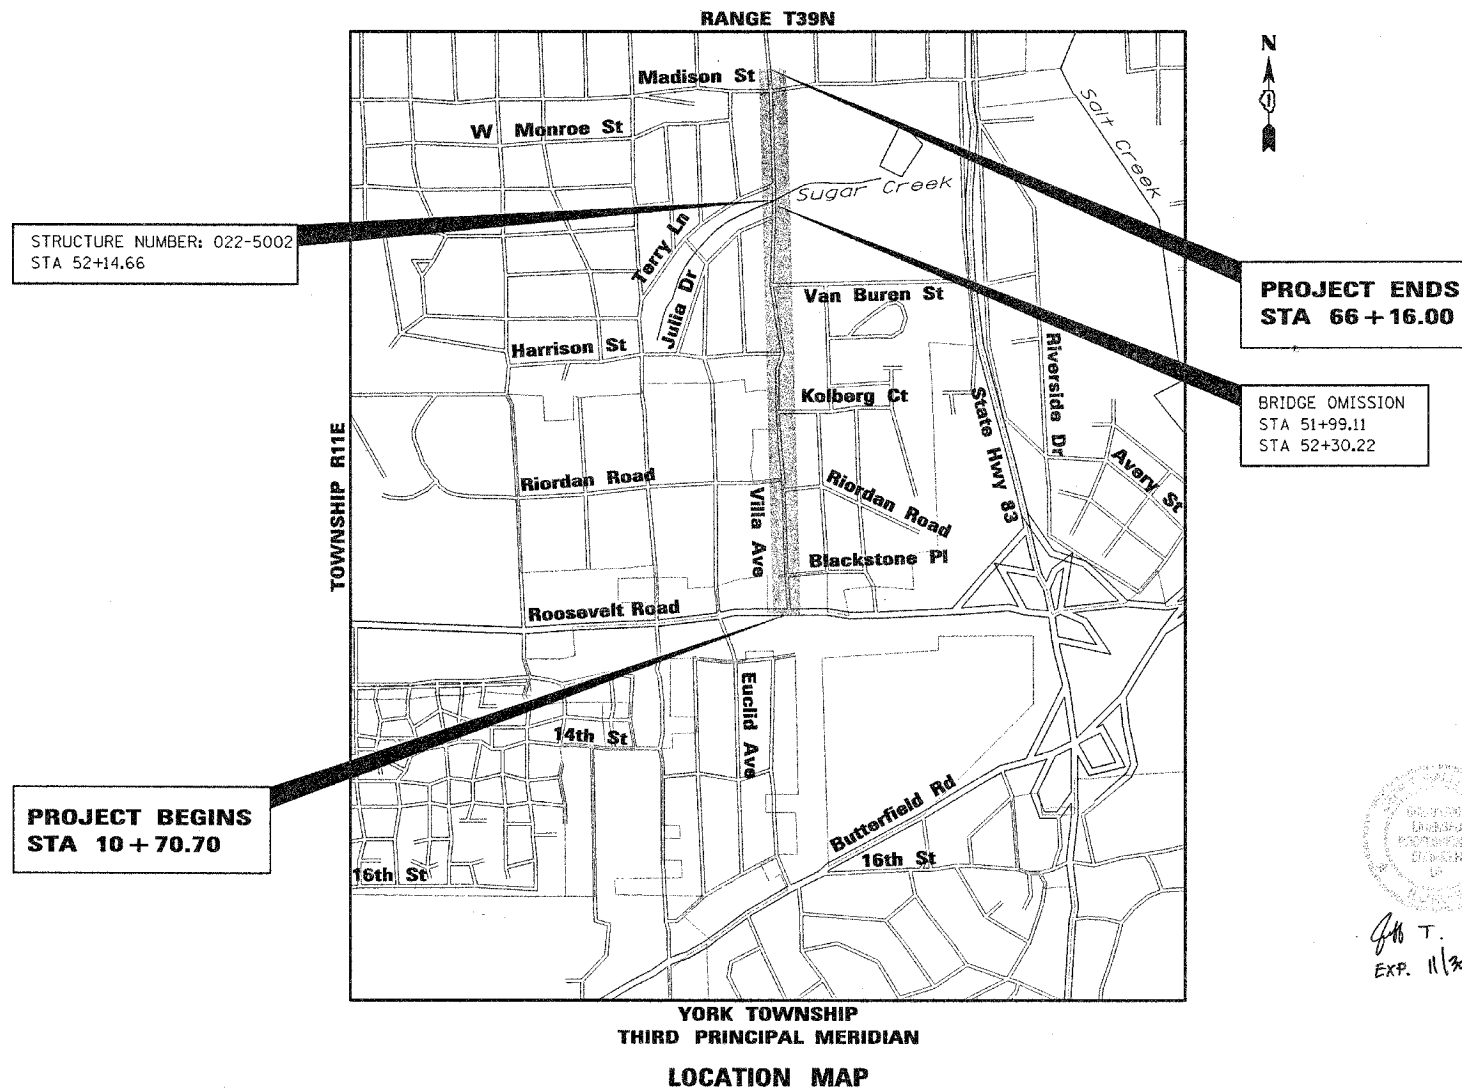

YORK TOWNSHIP
THIRD PRINCIPAL MERIDIAN
LOCATION MAP

MAP SCALE 0 0.5 MILE

GROSS LENGTH OF PROJECT: 5,545.3 FT (1.05 MILES)
BRIDGE OMISSION: 31 FT (0.01 MILES)
NET LENGTH OF PROJECT: 5,514.3 FT (1.04 MILES)

John T. Callaghan
EXP. 11/30/05

STATE OF ILLINOIS
DEPARTMENT OF TRANSPORTATION
DIVISION OF HIGHWAYS

SUBMITTED 11-10 20 04

Dydas Juskeles DIRECTOR PUBLIC WORKS
LOCAL AGENCY OFFICIAL

20

DISTRICT ENGINEER OF LOCAL ROADS AND STREETS

November 12, 20 04

Dina O'Keefe DISTRICT ENGINEER

**PRINTED BY THE AUTHORITY
OF THE STATE OF ILLINOIS**