
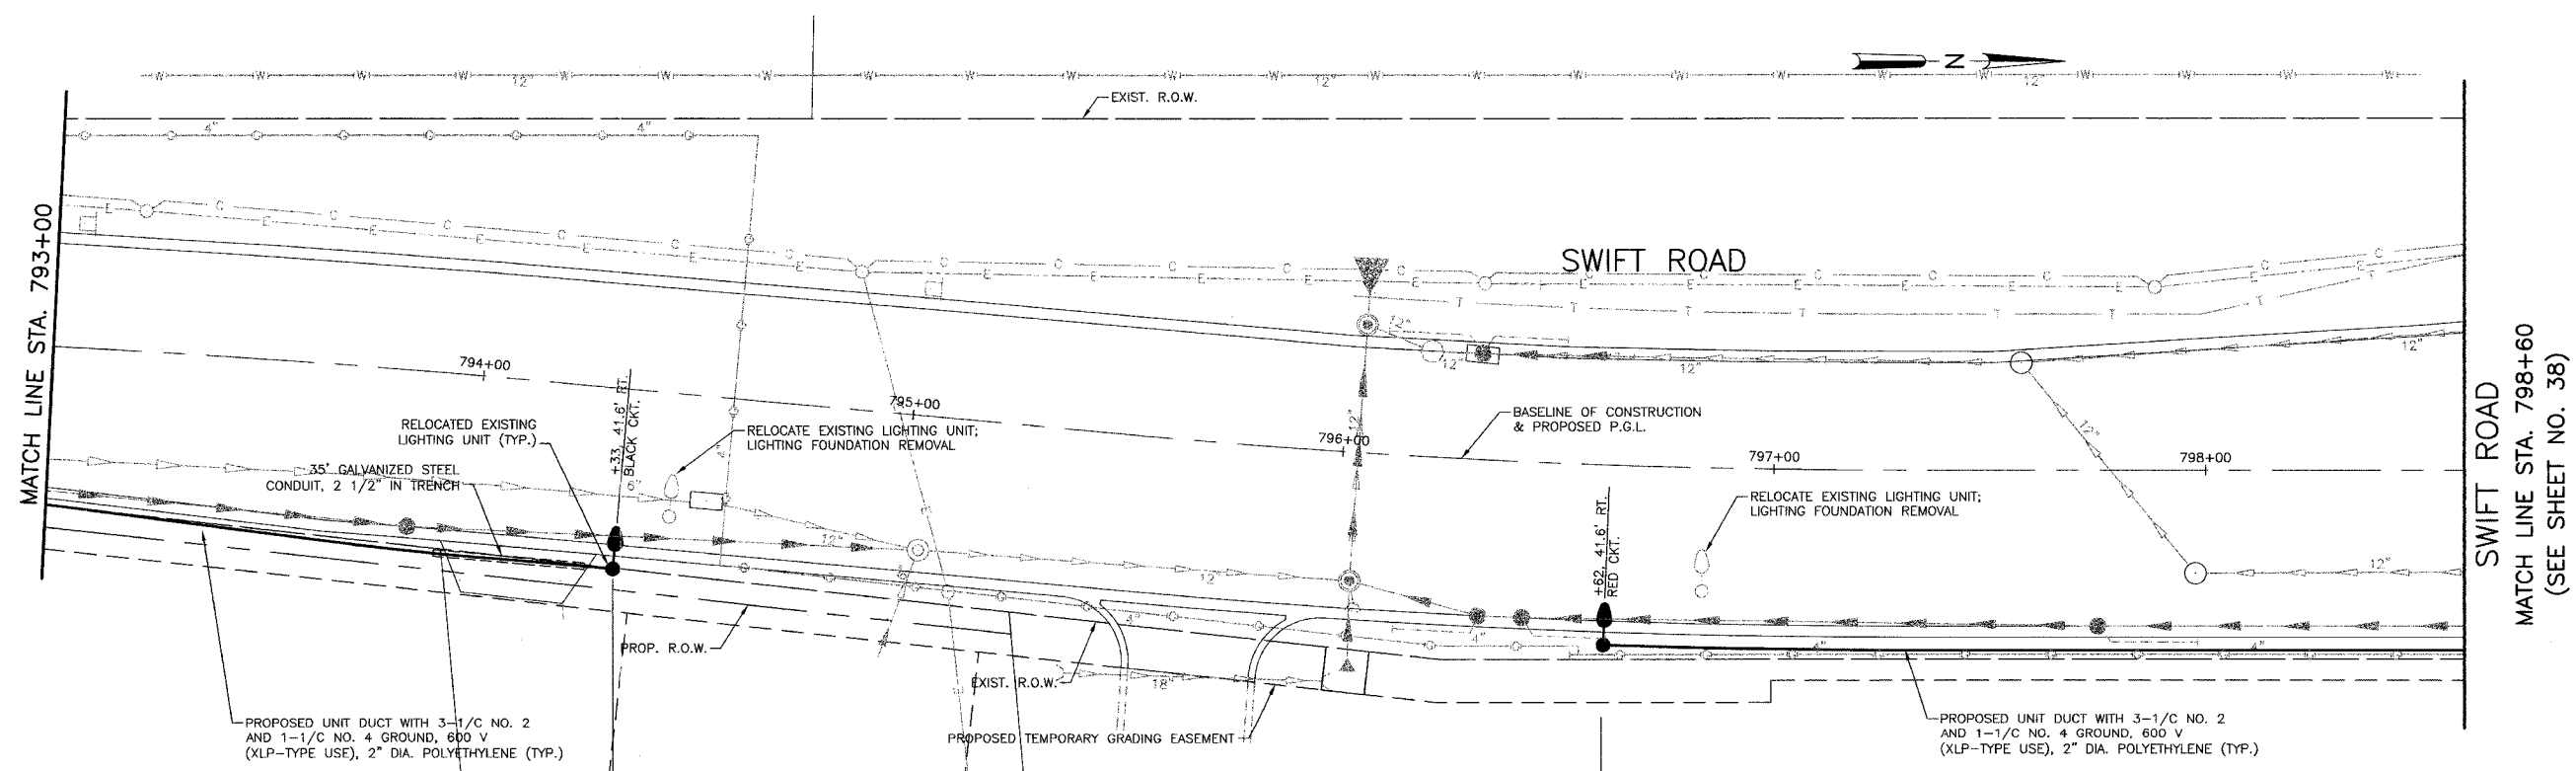


SECTION	COUNTY	TOTAL SHEETS	SHEET NO.
00-00086-00-TL	DUPAGE	58	39
789+00		798+60	
FED. ROAD DISTRICT	ILLINOIS	FED. AID PROJECT	
CONTRACT NO. 83794			

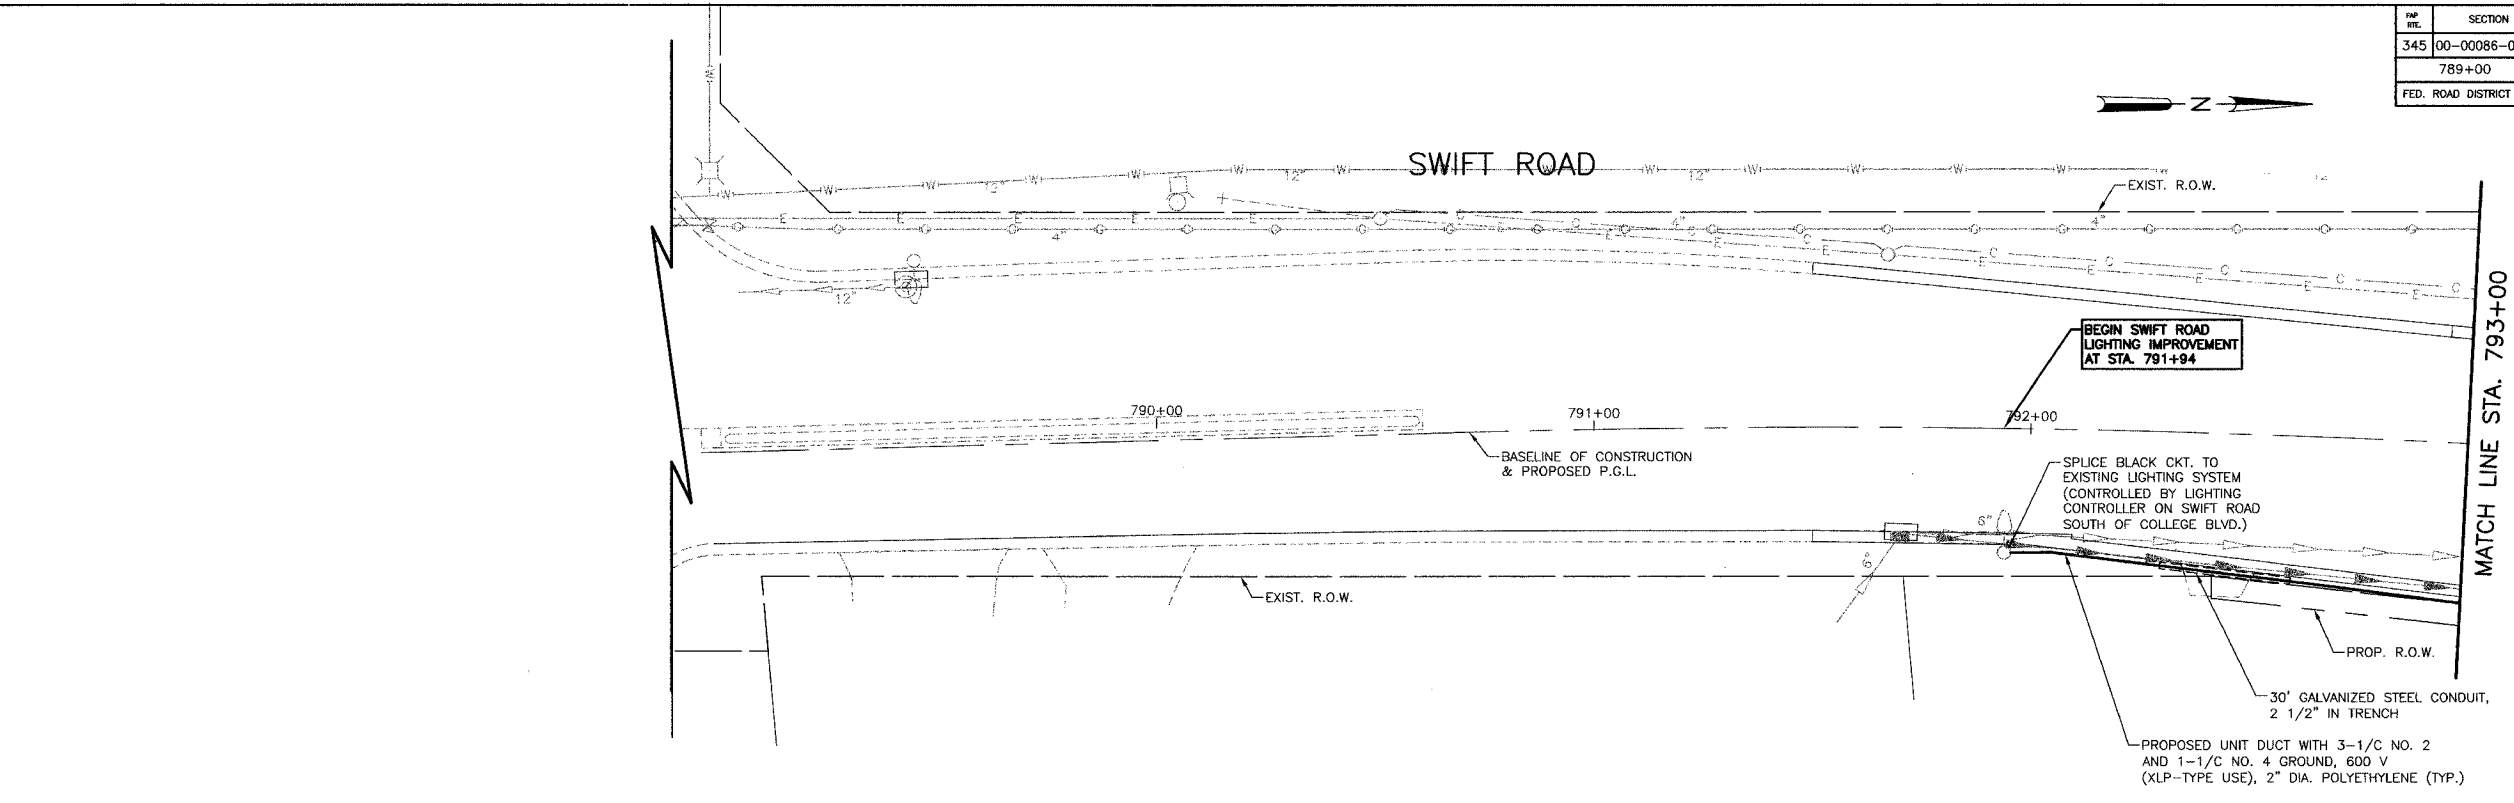

VILLAGE OF ADDISON LIGHTING SYSTEM TO EXISTING CONTROLLER ON SWIFT ROAD SOUTH OF COLLEGE BLVD. SEE WIRING DIAGRAM IN LIGHTING DETAIL SHEET

VILLAGE OF ADDISON LIGHTING SYSTEM TO EXISTING CONTROLLER AT LAKE STREET AND MEDINAH ROAD SEE WIRING DIAGRAM IN LIGHTING DETAIL SHEET

REVISIONS	
NAME	DATE

VILLAGE OF ADDISON
LIGHTING PLAN
SWIFT ROAD

HORIZ: 20
VERT: 5
SCALE IN FEET

DATE: 4/01/05
DESIGNED BY: S.J.C.
CHECKED BY: D.N.M.