 

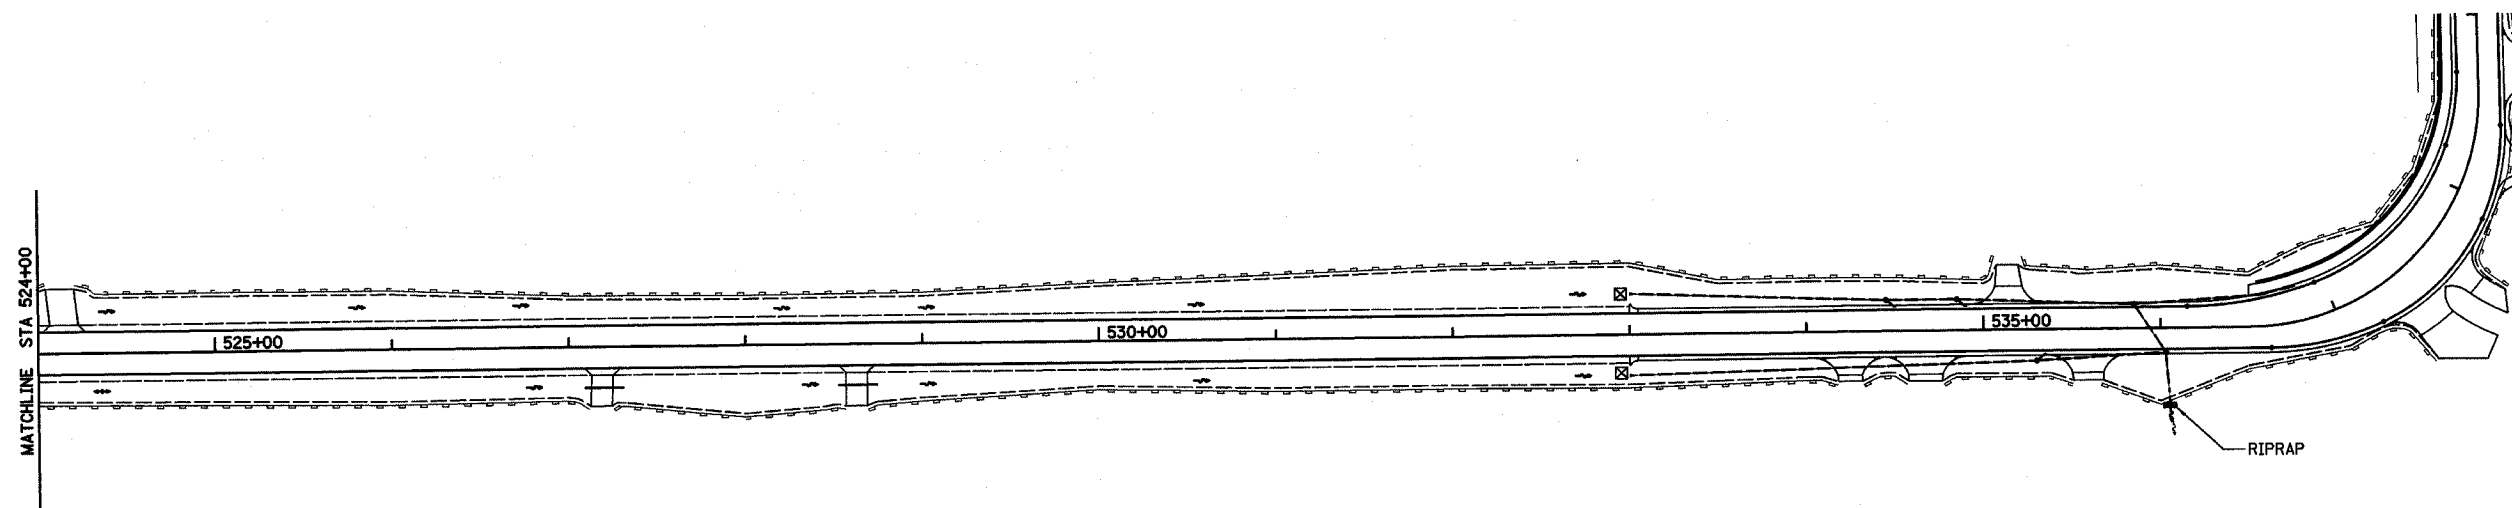
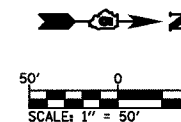


91325

ROUTE NO.	SECTION	COUNTY	TOTAL SHEETS	SHEET NO.
CH 31	*	MACON	162	58
FED. ROAD DIST. NO.	ILLINOIS	PROJECT		

* 02-00175-00-PV

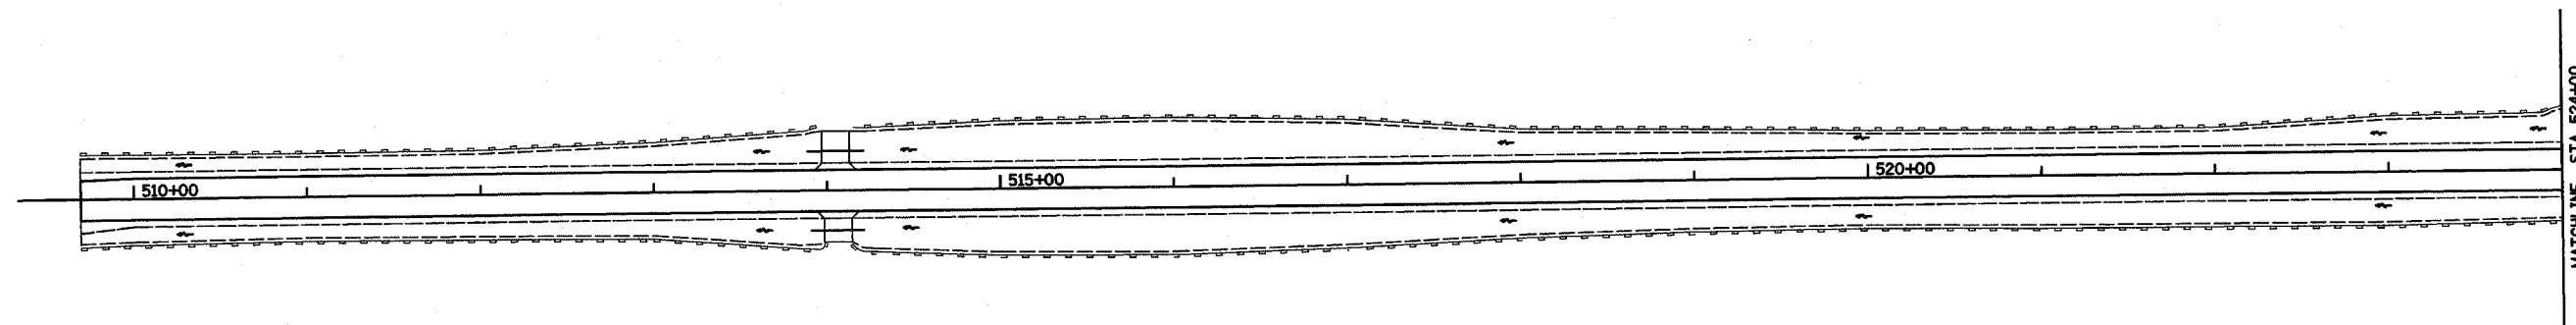

EROSION CONTROL PLAN		
TURPIN ROAD CONNECTOR (CH 31) MACON COUNTY, ILLINOIS		DRAWN BY: DLB DATE: 5/04 CHECKED BY: [blank] DATE: [blank]
REVISIONS NO. DATE INITIALS 1 2 3 4 5 6 7 8 9 10	HOMER L. CHASTAIN & ASSOCIATES, LLP CONSULTING ENGINEERS 184-00187	DECATUR (317) 422-8544 CHICAGO (773) 714-0050
	BOOK NUMBER: 471 PROJECT NO.: 4805 SHEET NO.: [blank]	