



HANSON PROFESSIONAL SERVICES INC.


815 Commerce Drive, Suite 200  
Oak Brook, Illinois 60523  
Telephone: 630.990.3800  
Fax: 630.990.3801



3580 North McAree Road  
Waukegan, Illinois 60087  
Phone: 847.244.0055  
Fax: 847.244.3813

### HANGAR AND TAXIWAY PAVEMENT REHABILITATION, HANGAR SITE PREPARATION, AND SERVICE ROAD OVERLAY

A.I.P. PROJ.: (TO BE ASSIGNED)  
I.L. PROJ.: (TO BE ASSIGNED)

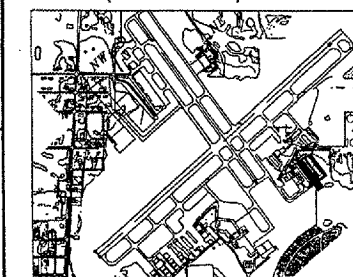


KEY MAP

No.	Drawing Issue Description	Date	By

Date: MAY 06, 2005  
Sheet Title:



### PLAN & PROFILE SHEET TAXILANE ALIGNMENT 10

83104TXVD	
Project Number	
AAP	02/28/05
Layout By	Date
AAP	02/28/05
Designed By	Date
TMM	04/07/05
Reviewed By	Date
AAP	
Drawn By	
	Sheet No.

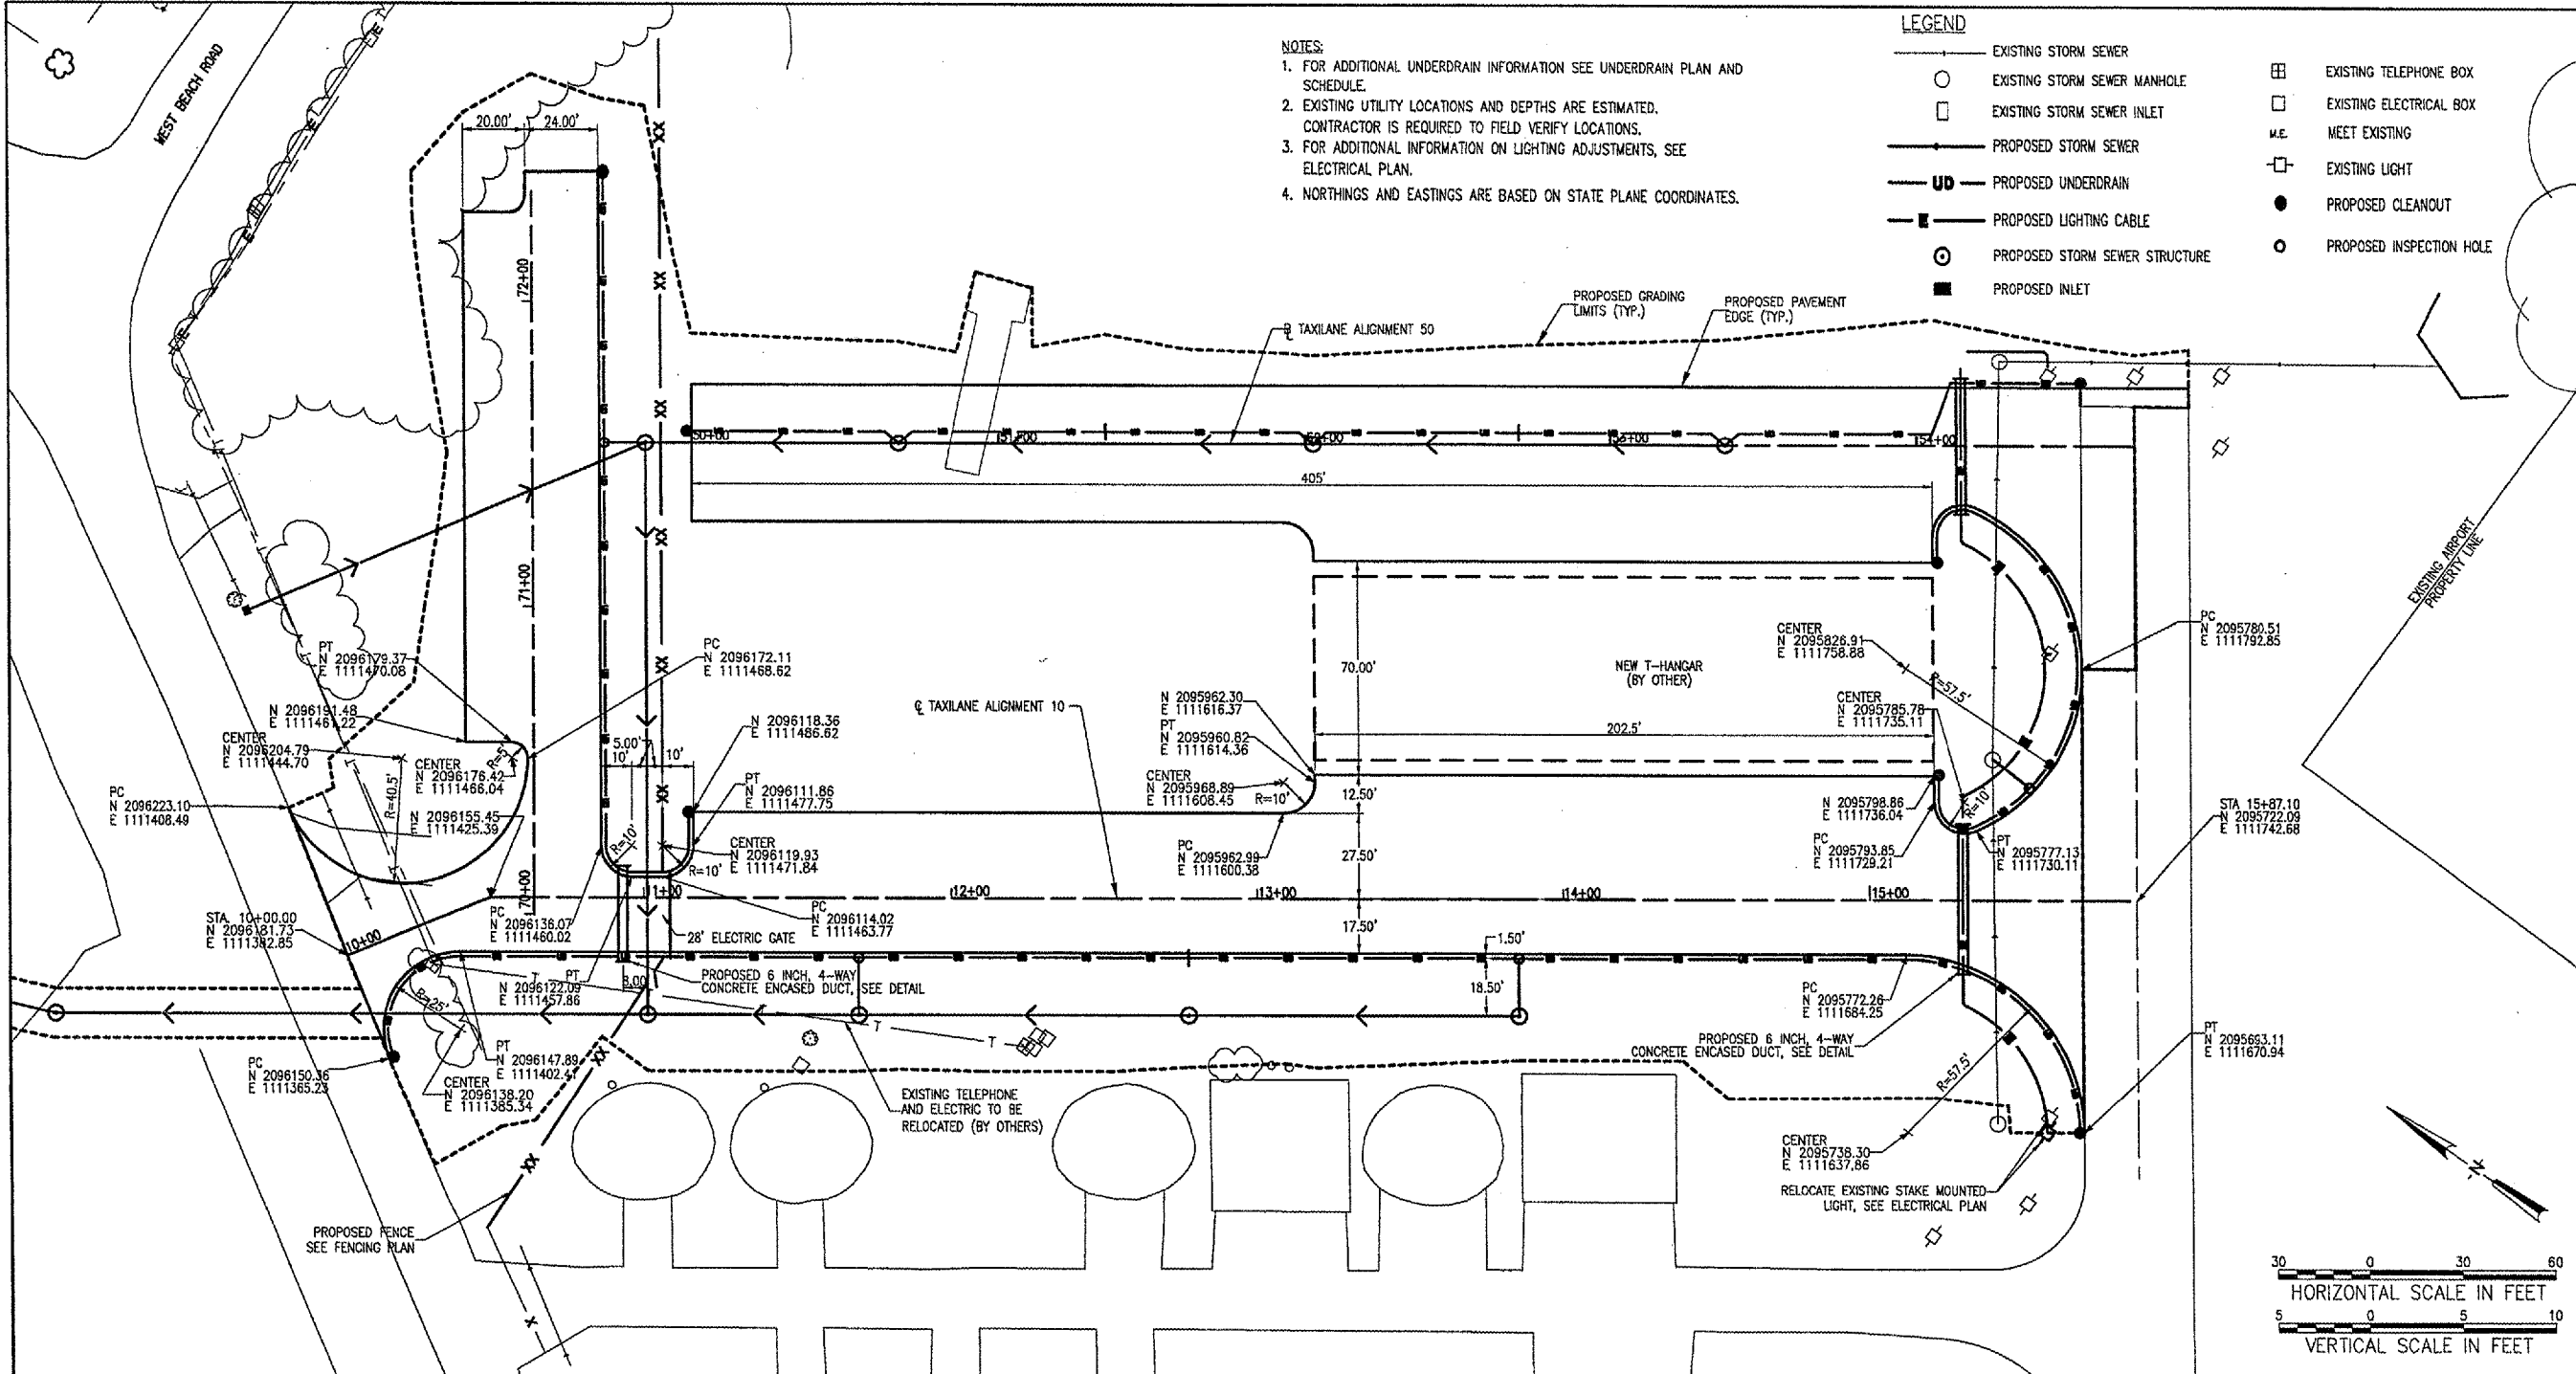

- NOTES:
- FOR ADDITIONAL UNDERDRAIN INFORMATION SEE UNDERDRAIN PLAN AND SCHEDULE.
  - EXISTING UTILITY LOCATIONS AND DEPTHS ARE ESTIMATED. CONTRACTOR IS REQUIRED TO FIELD VERIFY LOCATIONS.
  - FOR ADDITIONAL INFORMATION ON LIGHTING ADJUSTMENTS, SEE ELECTRICAL PLAN.
  - NORTHINGS AND EASTINGS ARE BASED ON STATE PLANE COORDINATES.

 - LEGEND
- EXISTING STORM SEWER
  - EXISTING STORM SEWER MANHOLE
  - EXISTING STORM SEWER INLET
  - PROPOSED STORM SEWER
  - PROPOSED UNDERDRAIN
  - PROPOSED LIGHTING CABLE
  - PROPOSED STORM SEWER STRUCTURE
  - PROPOSED INLET
  - EXISTING TELEPHONE BOX
  - EXISTING ELECTRICAL BOX
  - MEET EXISTING
  - EXISTING LIGHT
  - PROPOSED CLEANOUT
  - PROPOSED INSPECTION HOLE

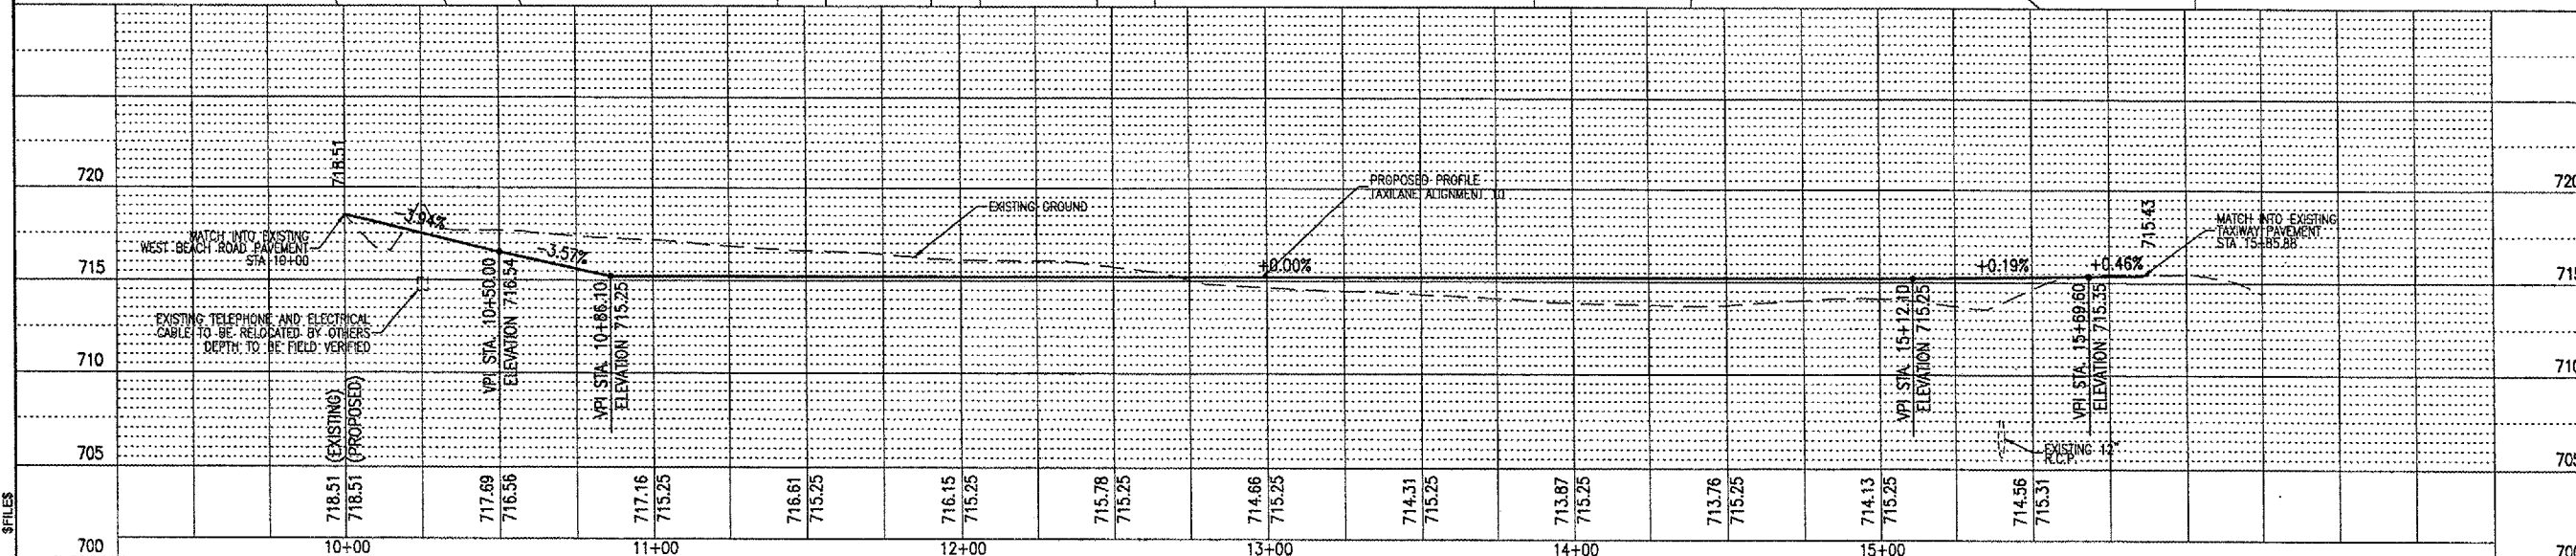

\$USERS \$FILES