


DATE TIME
USER

CONTRACT NO. 6287

F.A.I. RTE.	SECTION	COUNTY	TOTAL SHEETS	SHEET NO.
290	0305-302K-L3	COOK	63	14
STA.	TO STA.			
FED. ROAD DIST. NO.	ILLINOIS FED. AID PROJECT			

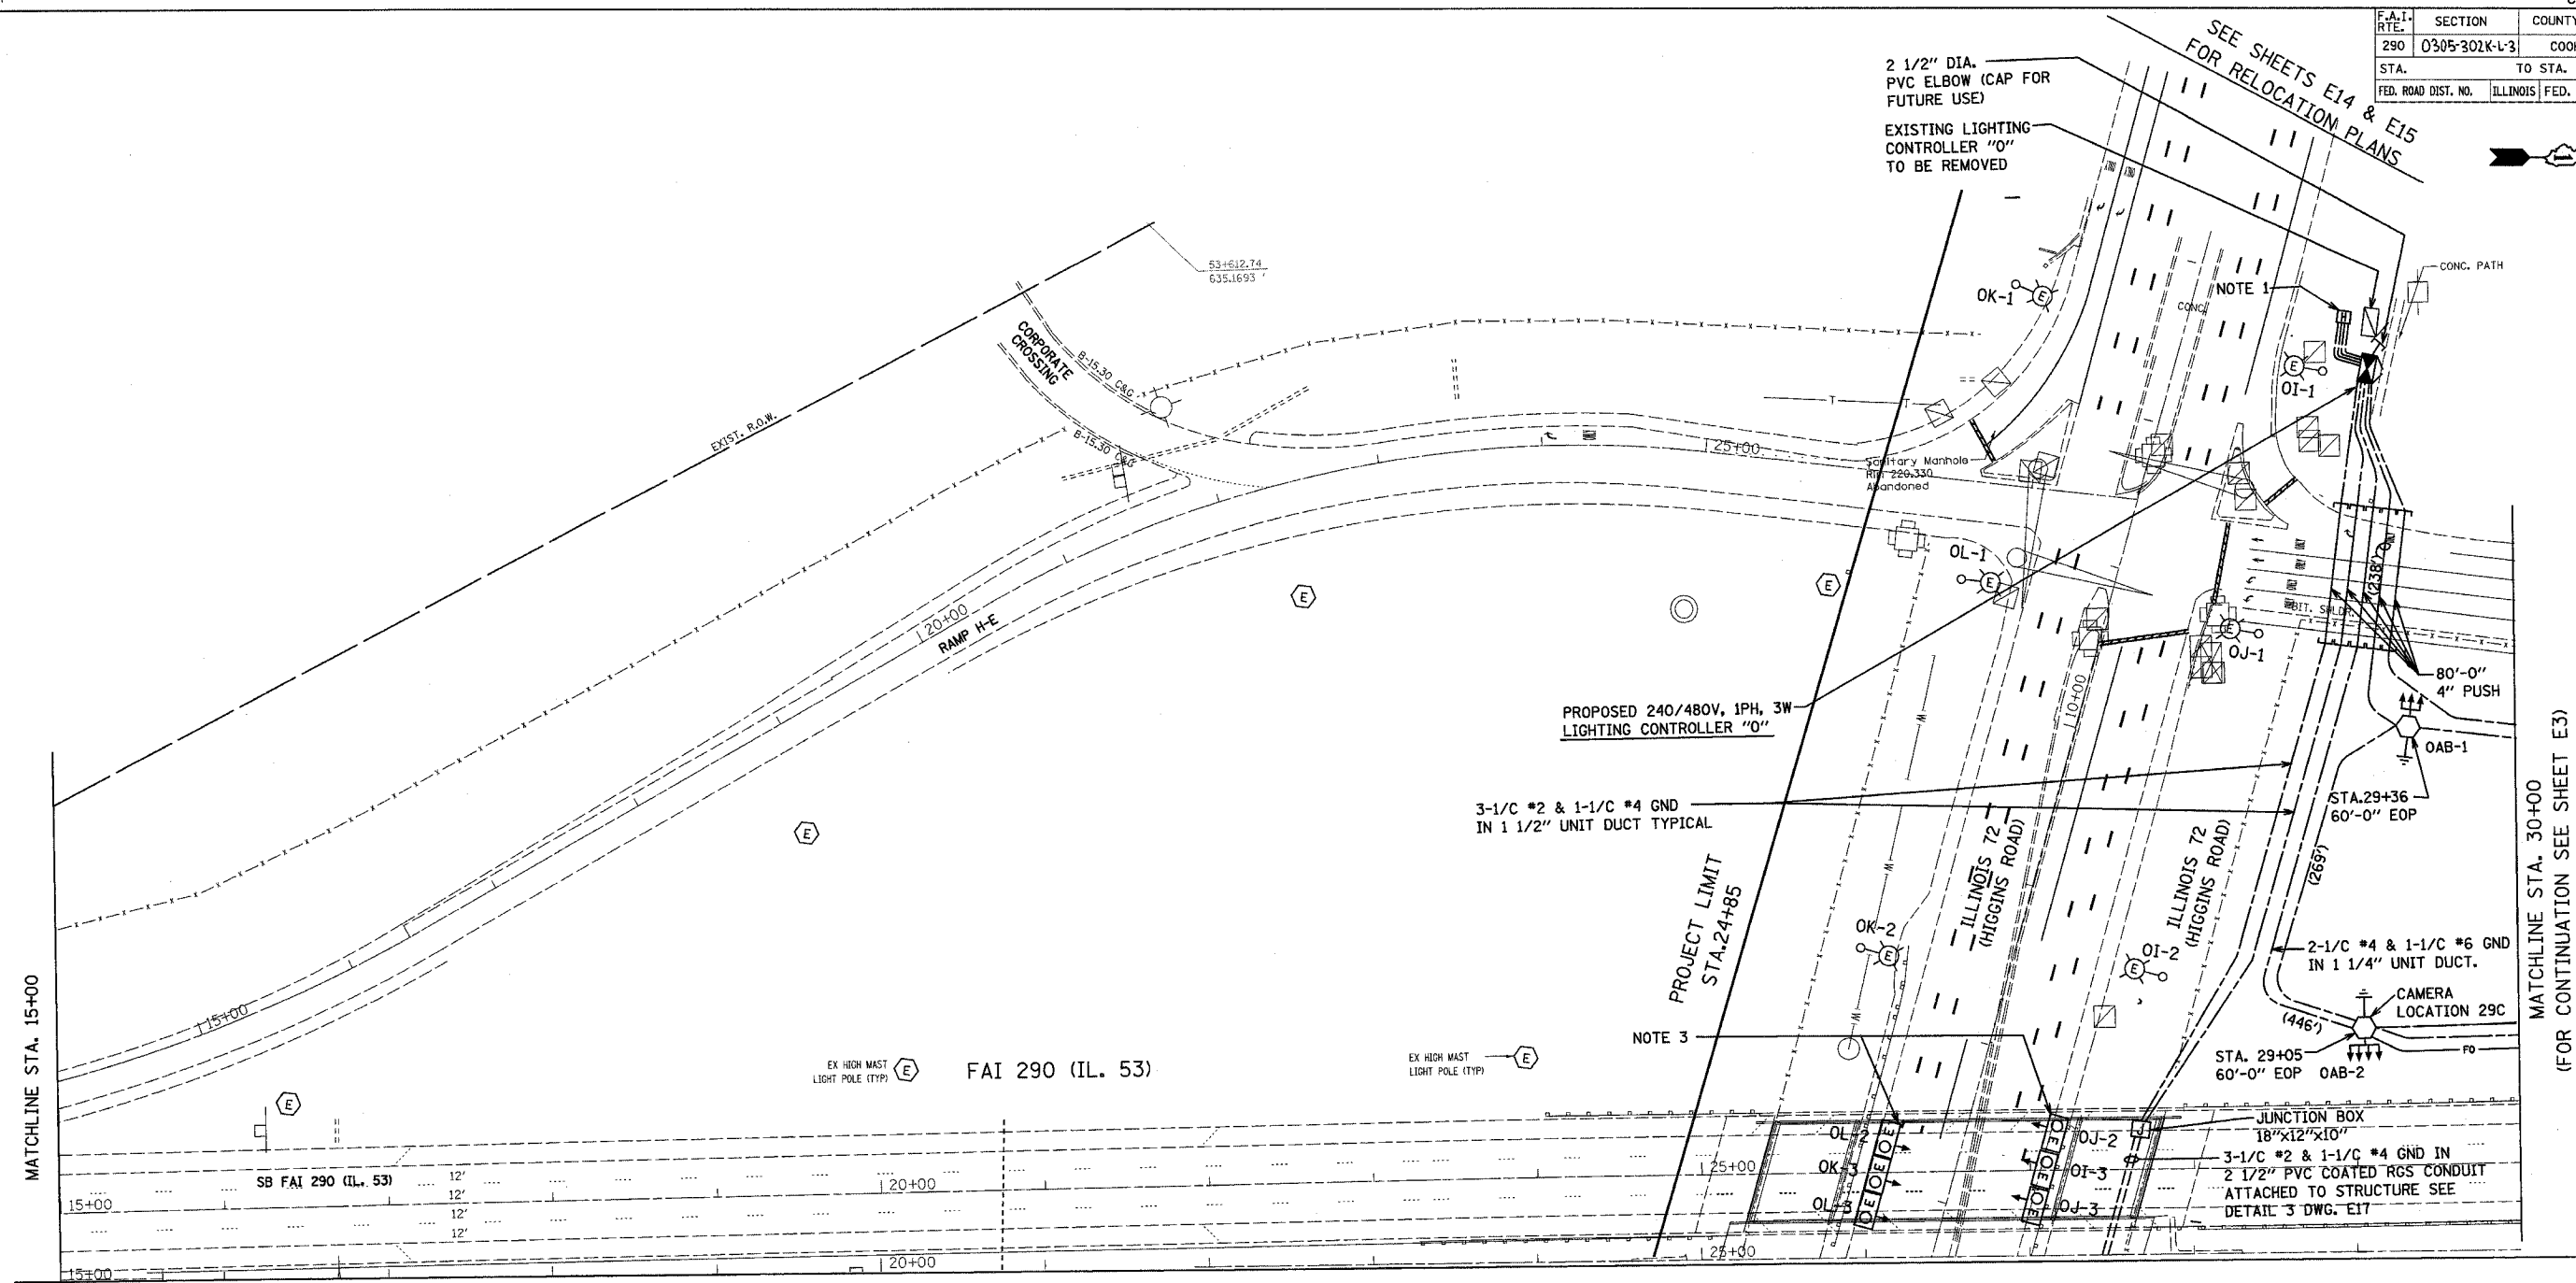

 
MATCHLINE STA. 15+00

MATCHLINE STA. 30+00
(FOR CONTINUATION SEE SHEET E3)

MATCHLINE (FOR CONTINUATION SEE SHEET E2)

NOTES:

- INTERCEPT EXISTING HIGGINS ROAD LIGHTING CIRCUITS AND RECONNECT TO PROPOSED CONTROLLER "O" IN ACCORDANCE WITH SINGLE LINE DIAGRAM, SHEET E11. RECONNECTION TO BE DONE DURING ONE DAYTIME PERIOD. IF NOT, ENGINEER MUST APPROVE TEMPORARY WIRING FOR THESE CIRCUITS AT NO ADDITIONAL COST TO THE CONTRACT. RE-LABEL ALL ASSOCIATED LUMINAIRE NUMBERING DECALS.
- REPLACE ALL LUMINAIRE HEADS ON HIGGINS RD. WITH LUMINAIRES WITH MULTI-TAP BALLASTS OF THE SAME TYPE AND WATTAGE. LUMINAIRES TO BE PROVIDED FROM STATE STOCK. SET TAPS FOR 240V OPERATION. SEE SINGLE LINE DIAGRAM, SHEET E11.
- RECONNECT UNDERPASS LUMINAIRES IN ACCORDANCE WITH SINGLE LINE DIAGRAM, SHEET E11.
- LIGHT POLES ON HIGGINS ROAD ARE TO BE RELABELLED IN ACCORDANCE WITH SINGLE LINE DIAGRAM, SHEET E11, AND RELOCATION PLANS ON SHEETS E14 AND E15.



PLOT DATE = 04/28/2005
 FILE NAME = E11.E14
 PLOT SCALE = *SCALE*
 REFERENCE = *REF*

HOH HARRY O. HEFTER - ASSOCIATES, INC.
 DESIGN AND CONSULTING ENGINEERS
 25 East Jackson Blvd.
 Chicago, Illinois 60604
 312/346-8131

REVISIONS	
NAME	DATE

ILLINOIS DEPARTMENT OF TRANSPORTATION
LIGHTING PLAN
 ILLINOIS ROUTE 53
 WEST HALF OF HIGGINS RD.
 I-53 INTERCHANGE

SCALE: VERT. 1"=50'
 HORIZ. AS SHOWN
 DATE 02-28-2005

DRAWN BY MEK
 CHECKED BY RER

E1