 



DATE TIME USER

CONTRACT NO. 62871


F.A. RTE.	SECTION	COUNTY	TOTAL SHEETS	SHEET NO.
290	0305-302K-L-3	COOK	55	15
STA.		TO STA.		
FED. ROAD DIST. NO.		ILLINOIS FED. AID PROJECT		



MATCHLINE (FOR CONTINUATION SEE SHEET E1)

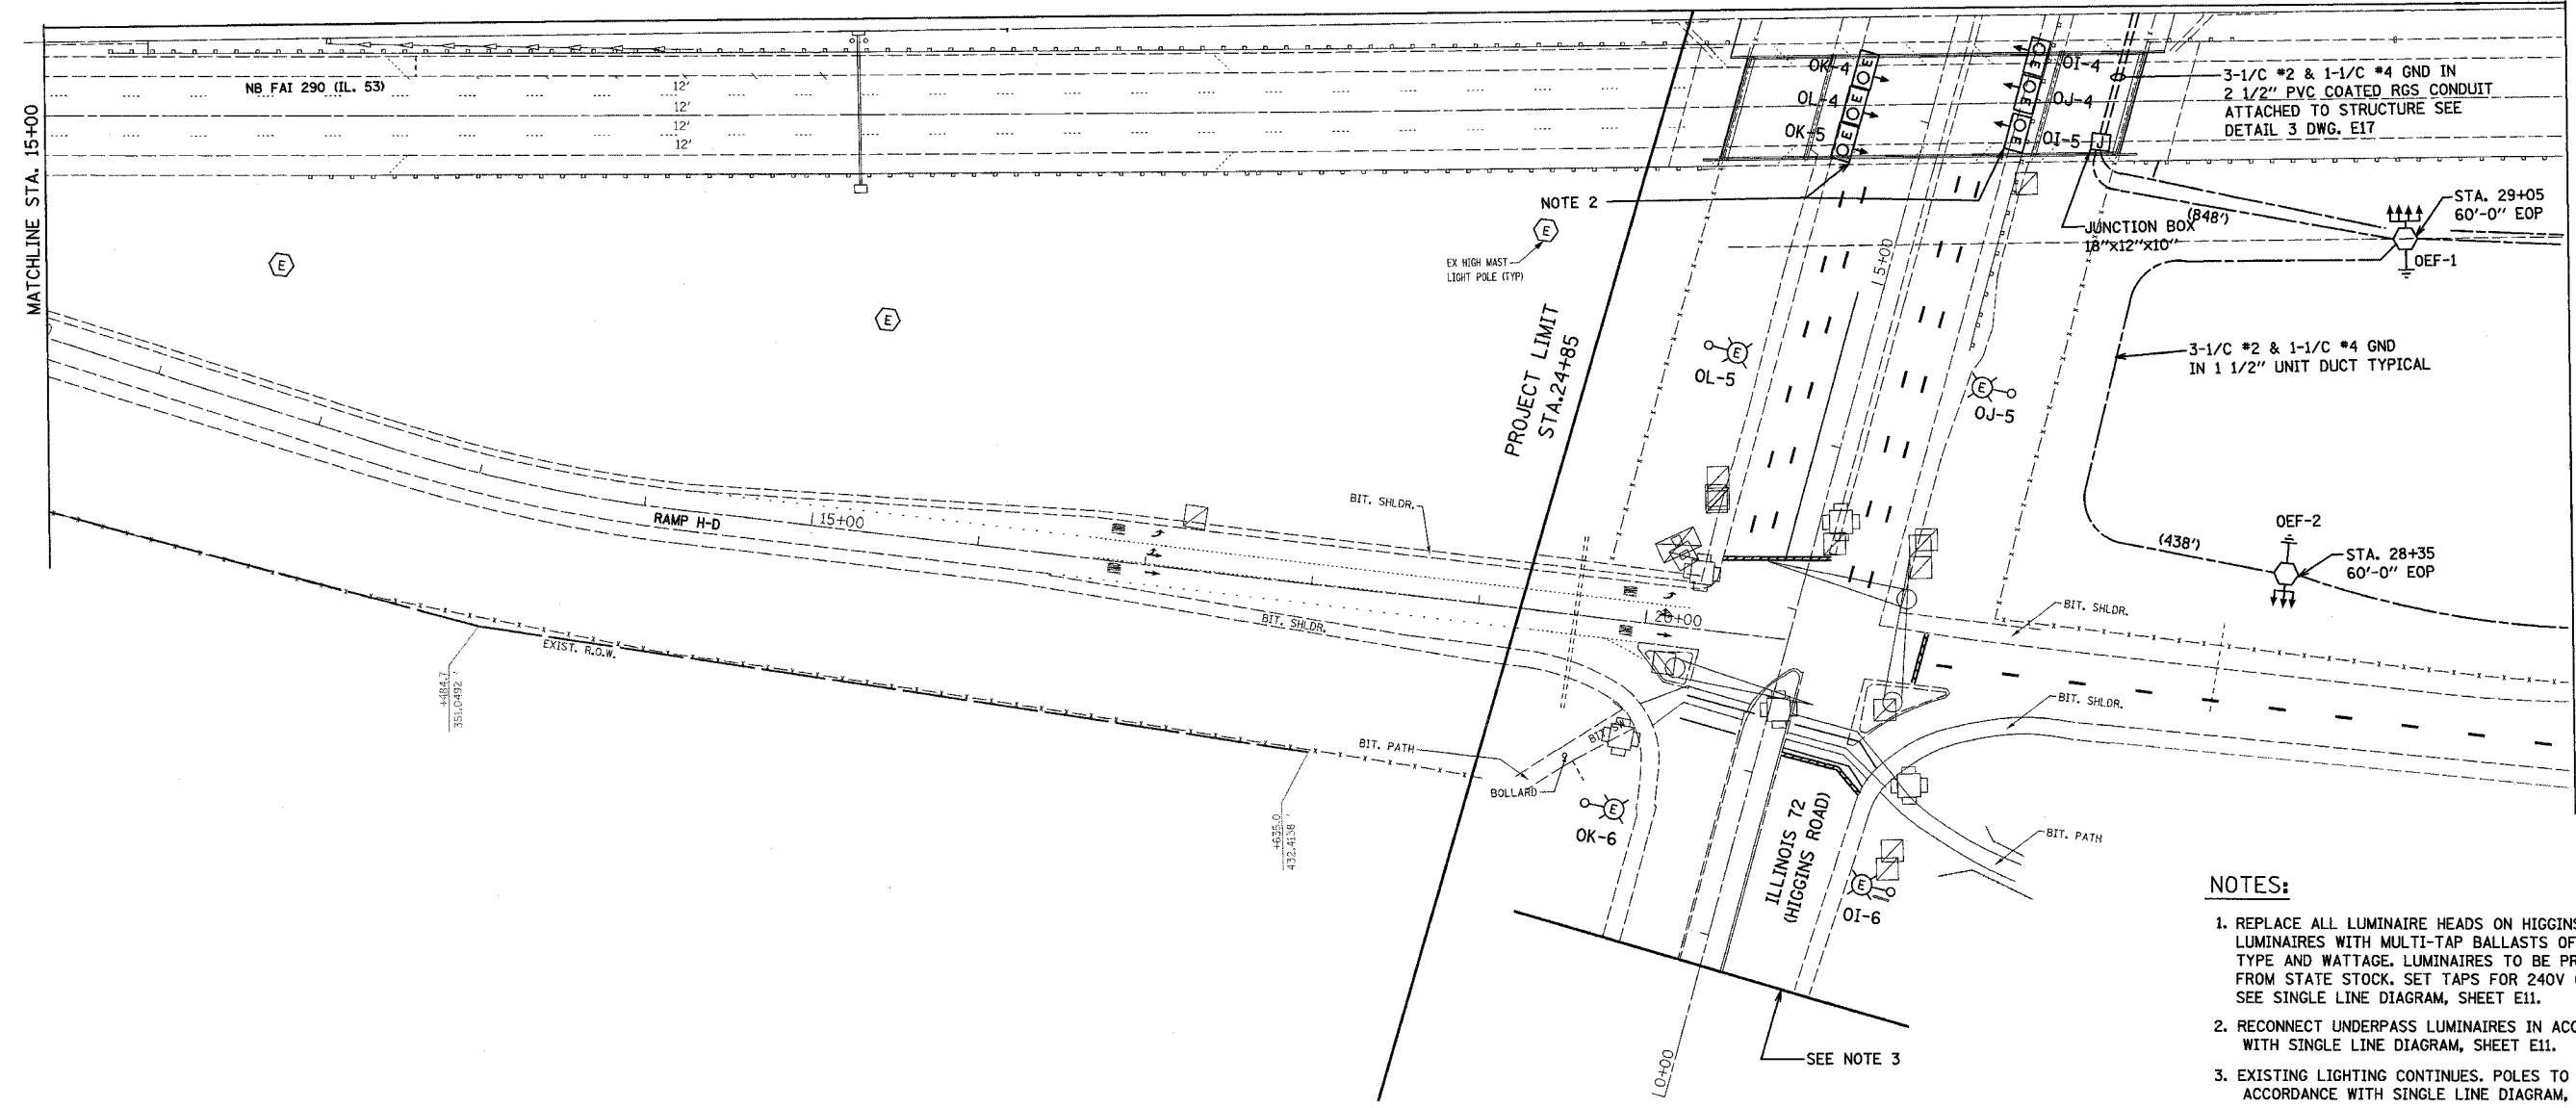

- NOTES:**
1. REPLACE ALL LUMINAIRE HEADS ON HIGGINS RD. WITH LUMINAIRES WITH MULTI-TAP BALLASTS OF THE SAME TYPE AND WATTAGE. LUMINAIRES TO BE PROVIDED FROM STATE STOCK. SET TAPS FOR 240V OPERATION. SEE SINGLE LINE DIAGRAM, SHEET E11.
  2. RECONNECT UNDERPASS LUMINAIRES IN ACCORDANCE WITH SINGLE LINE DIAGRAM, SHEET E11.
  3. EXISTING LIGHTING CONTINUES. POLES TO BE RELABELLED IN ACCORDANCE WITH SINGLE LINE DIAGRAM, SHEET E11.

 

EAST HALF OF INTERCHANGE

PLOT DATE = 04/28/2005  
 FILE NAME = #FILE#  
 PLOT SCALE = #SCALE#  
 REFERENCE = #REF#

**HOH** HARRY O. HETTER - ASSOCIATES, INC.  
 DESIGN AND CONSULTING ENGINEERS  
 98 East Jackson Blvd.  
 Chicago, IL 60604  
 312/348-8131

REVISIONS	
NAME	DATE

ILLINOIS DEPARTMENT OF TRANSPORTATION  
**LIGHTING PLAN**  
 ILLINOIS ROUTE 53  
 EAST HALF OF HIGGINS RD.  
 I-53 INTERCHANGE

SCALE: VERT. 1"=50'  
 HORIZ. 1"=50'  
 DATE 02-28-2005

DRAWN BY MEK  
 CHECKED BY RER

E2