
 


F.A.I. RTE.	SECTION	COUNTY	TOTAL SHEETS	SHEET NO.
290	0305-302K-L-3	COOK		18
STA.		TO STA.		
FED. ROAD DIST. NO.		ILLINOIS FED. AID PROJECT		

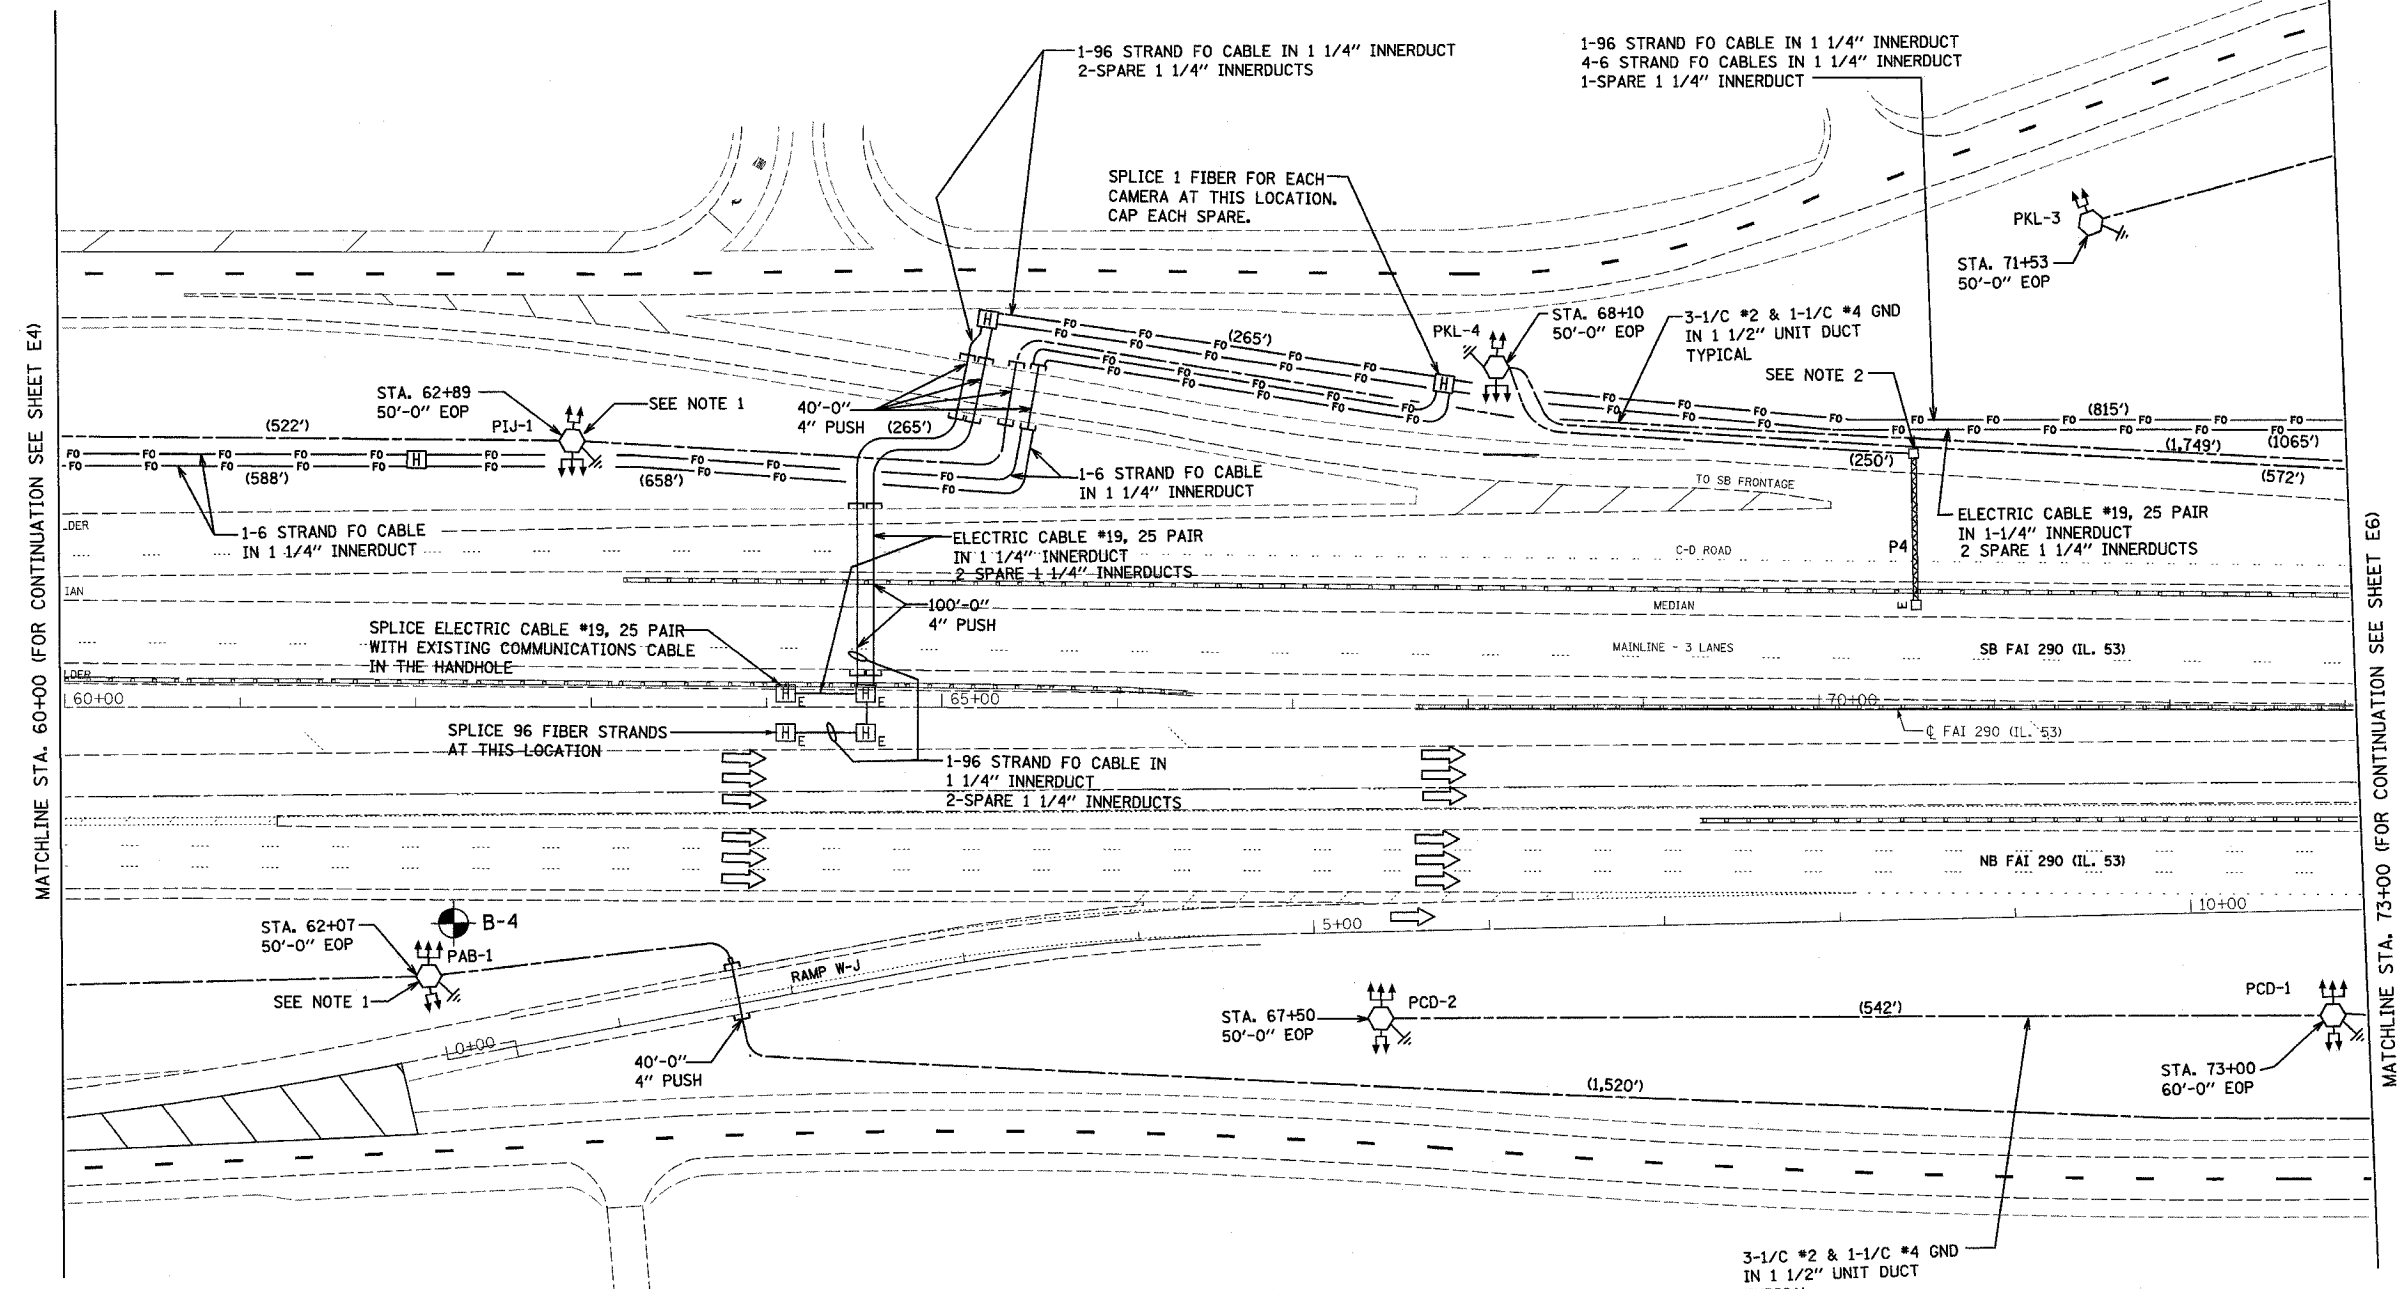

- NOTES:**
1. MOUNT BUCK-BOOST TRANSFORMERS INSIDE TOWER CLOSED CIRCUIT TELEVISION CABINET. CONNECT IN ACCORDANCE WITH CIRCUIT DIAGRAM, SHEET E11.
 2. REMOVE EXISTING STEP-DOWN TRANSFORMERS. EXTEND SIGN LUMINAIRE CIRCUITS TO LOAD SIDE OF EXISTING DISCONNECT SWITCH. CONNECT LINE SIDE OF EXISTING DISCONNECT SWITCH TO PROPOSED LIGHTING CIRCUIT IN ACCORDANCE WITH CIRCUIT DIAGRAM, SHEET E12.



3-1/C #2 & 1-1/C #4 GND
IN 1 1/2" UNIT DUCT
TYPICAL

REVISIONS	
NAME	DATE

ILLINOIS DEPARTMENT OF TRANSPORTATION
LIGHTING PLAN
ILLINOIS ROUTE 53

SCALE: VERT. 1"=50'
HORIZ. 1"=50'

DATE 02-28-2005

DRAWN BY MEK
CHECKED BY RER

HOH
HARRY O. HEFTER - ASSOCIATES, INC.
DESIGN AND CONSULTING ENGINEERS

2672

PROJECT: 02/28/05/ILL_04_01_05/SEGMENT 1/LIGHTING

DATE: 02/28/05
FILE: 02/28/05
SCALE: 1"=50'
REFERENCE: SHEET E11, E12

MATCHLINE STA. 60+00 (FOR CONTINUATION SEE SHEET E4)

MATCHLINE STA. 73+00 (FOR CONTINUATION SEE SHEET E6)