



F.A.I. RTE.	SECTION	COUNTY	TOTAL SHEETS	SHEET NO.
290	0305-302K-L-3	COOK		19
STA.	TO STA.			
FED. ROAD DIST. NO.	ILLINOIS	FED. AID PROJECT		

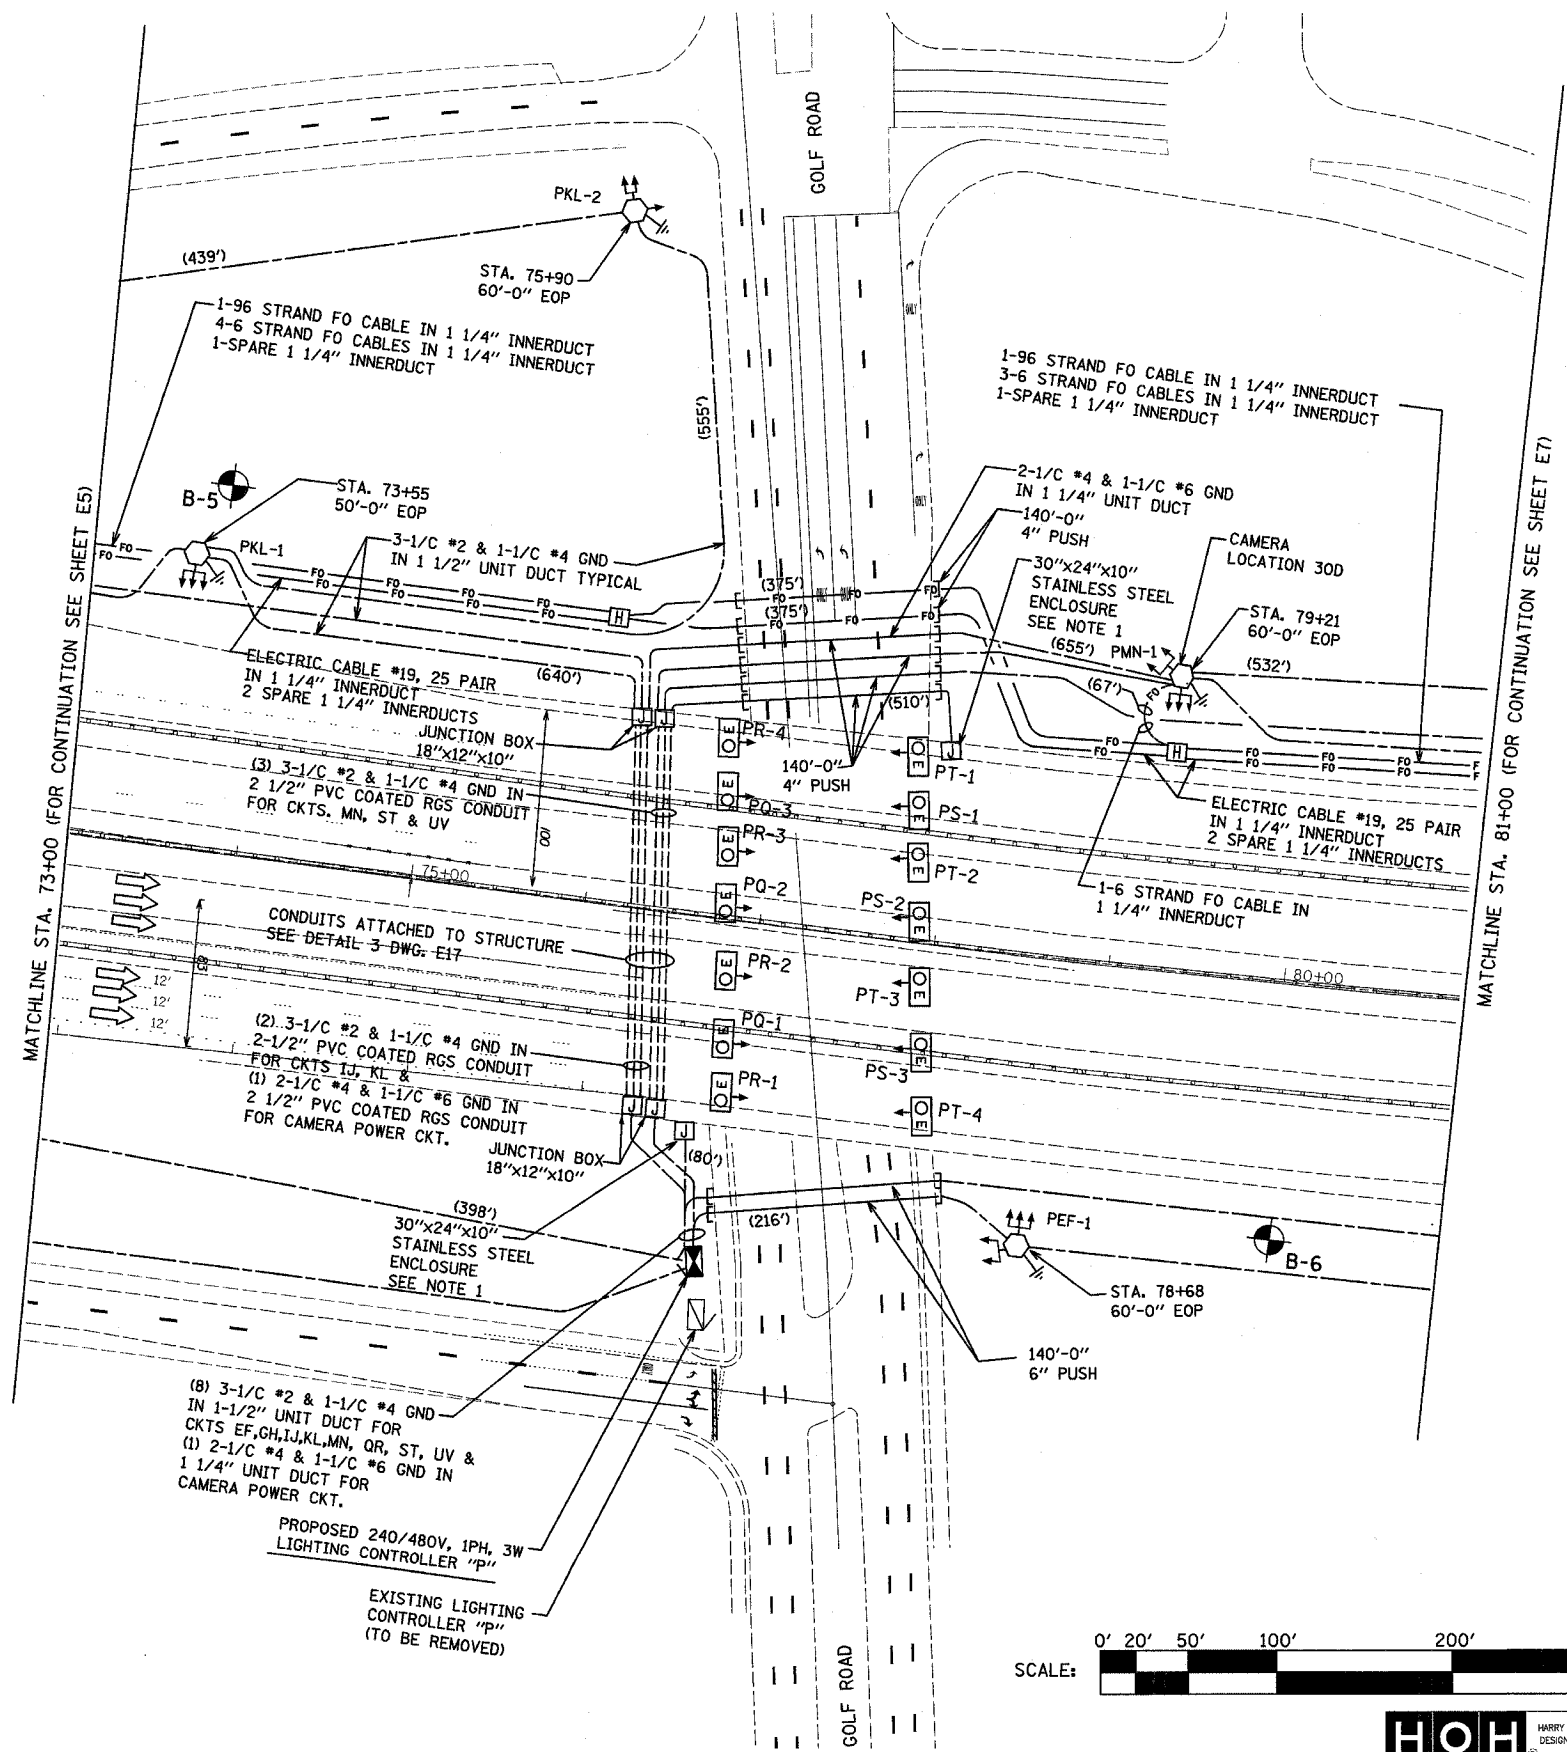

NOTES:

1. RE-CONNECT UNDERPASS LIGHTING CIRCUITS IN ACCORDANCE WITH CONTROLLER "P" CIRCUIT DIAGRAM SHEET E12 AND RE-LABEL ALL ASSOCIATED LUMINAIRE NUMBERING DECALS. SEE DETAIL#1 SHEET E16 FOR TRANSFORMER MOUNTING DETAILS.

 PLT DATE = 04/28/2005
FILE NAME = #FILE#
PLOT SCALE = #SCALE#
REFERENCE = #REF#



HOH HARRY O. HEFTER - ASSOCIATES, INC.
DESIGN AND CONSULTING ENGINEERS
55 East Jackson Blvd.
Chicago, Illinois 60604
312/346-8131

REVISIONS	
NAME	DATE

ILLINOIS DEPARTMENT OF TRANSPORTATION

LIGHTING PLAN
ILLINOIS ROUTE 53
I-53 AT GOLF ROAD

SCALE: VERT. 1"=50'
HORIZ. DATE 02-28-2005

DRAWN BY MEK
CHECKED BY RER