


DATE TIME
USER

(FOR CONTINUATION, SEE NORTHWEST TOLLWAY SHEET

CONTRACT NO. 62871				
F.A.I. RTE.	SECTION	COUNTY	TOTAL SHEETS	SHEET NO.
290	0305-302K-L-3	COOK		21
STA.	TO STA.			
FED. ROAD DIST. NO.	ILLINOIS	FED. AID PROJECT		

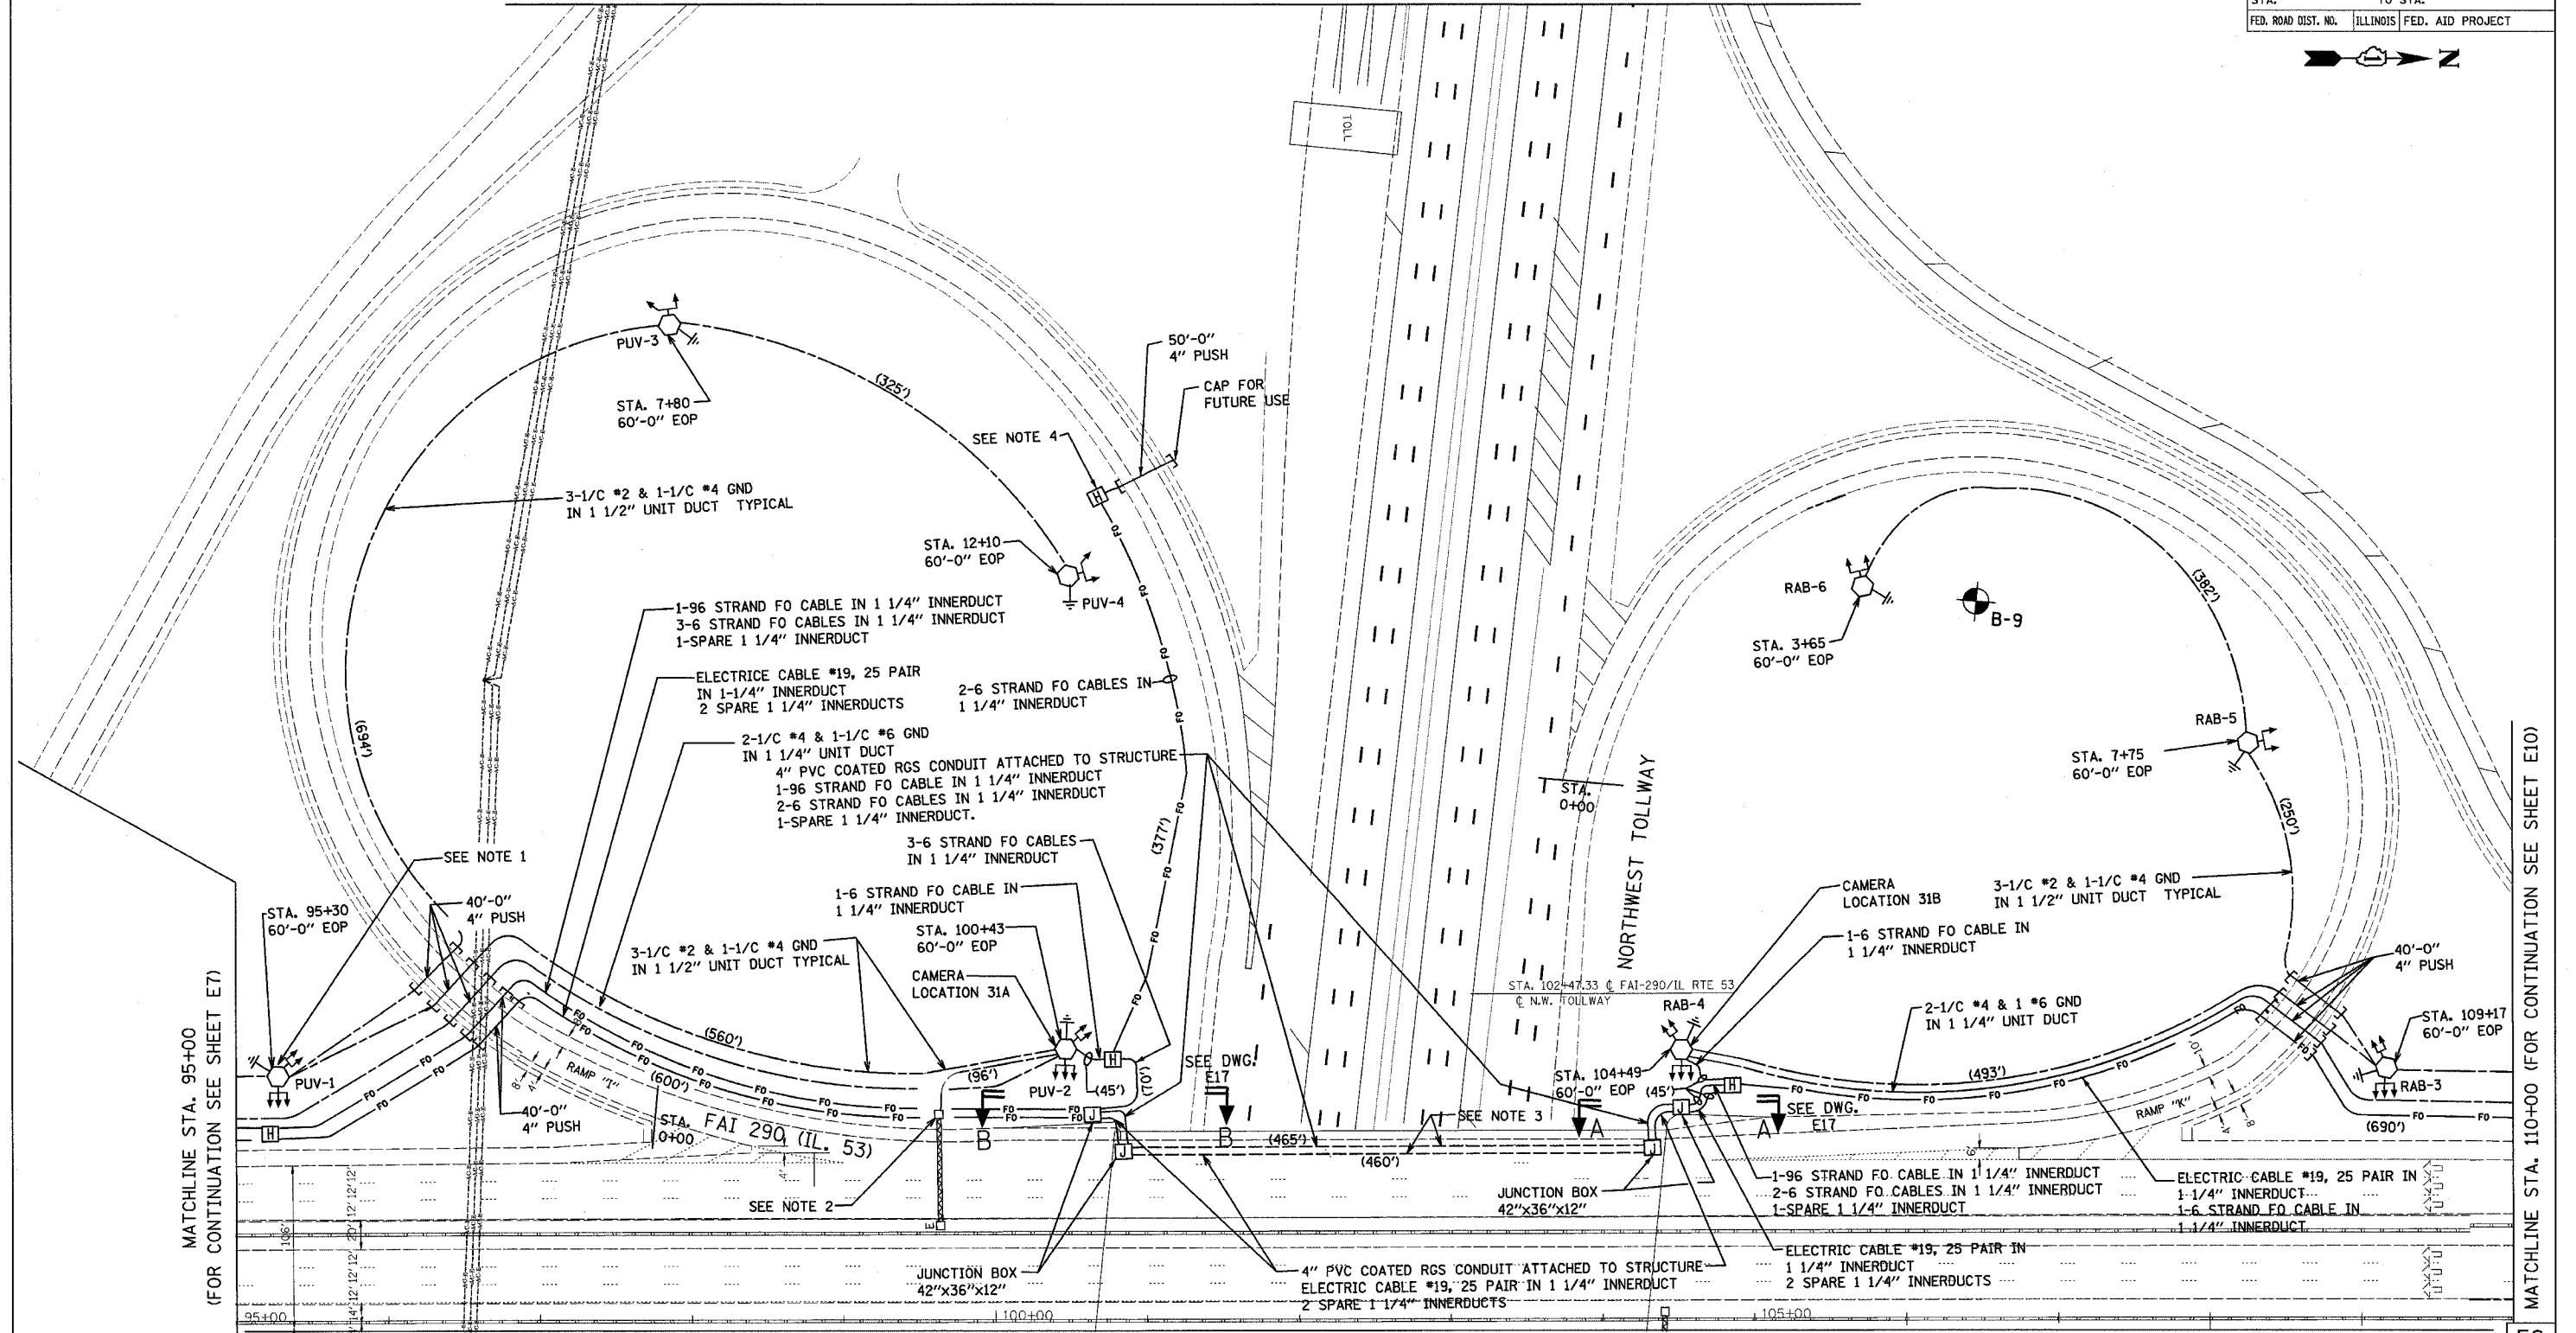

MATCHLINE STA. 95+00
(FOR CONTINUATION SEE SHEET E7)

 
MATCHLINE STA. 110+00 (FOR CONTINUATION SEE SHEET E10)

NOTES:

1. MOUNT BUCK-BOOST TRANSFORMERS INSIDE TOWER CLOSED CIRCUIT TELEVISION CABINET. CONNECT IN ACCORDANCE WITH CIRCUIT DIAGRAM, SHEET E12.
2. REMOVE EXISTING STEP-DOWN TRANSFORMERS. EXTEND SIGN LUMINAIRE CIRCUITS TO LOAD SIDE OF EXISTING DISCONNECT SWITCH. CONNECT LINE SIDE OF EXISTING DISCONNECT SWITCH TO PROPOSED LIGHTING CIRCUIT IN ACCORDANCE WITH CIRCUIT DIAGRAM, SHEET E-12.
3. 4" CONDUITS RUNNING IN THE NORTH / SOUTH DIRECTION SHALL BE ROUTED ALONG THE WEB OF THE SECOND BEAM FROM THE WEST SIDE OF THE OVERPASS.

4. COORDINATE EXACT LOCATION OF THE HANDHOLE WITH THE ENGINEER. COIL AN EXTRA 300 FEET OF FIBER OPTIC CABLE IN HANDHOLE FOR FUTURE EXTENSION.

(FOR CONTINUATION SEE EAST HALF OF INTERCHANGE SHEET E9)



HOH HARRY O. HEFFER - ASSOCIATES, INC.
DESIGN AND CONSULTING ENGINEERS
2672
65 East Jackson Blvd.
Chicago, Illinois 60604
312/348-8133
0:\PROJECTS\0872\0872\FINAL\04_01_05\SEGMENT 1\LIGHTING

REVISIONS	
NAME	DATE

ILLINOIS DEPARTMENT OF TRANSPORTATION
LIGHTING PLAN
ILLINOIS ROUTE 53
WEST HALF OF I-90/
I-53 INTERCHANGE
SCALE: VERT. 1"=50'
HORIZ. DATE 02-28-2005
DRAWN BY MEK
CHECKED BY RER

PLOT DATE = 04/28/2005
FILE NAME = #FILE#
PLOT SCALE = #SCALE#
REFERENCE = #REF#